

LAMPIRAN



Resepsionis View 1


Sumber : Dokumen Pribadi 2018



Resepsionis View 2

Sumber : Dokumen Pribadi 2018

LAMPIRAN

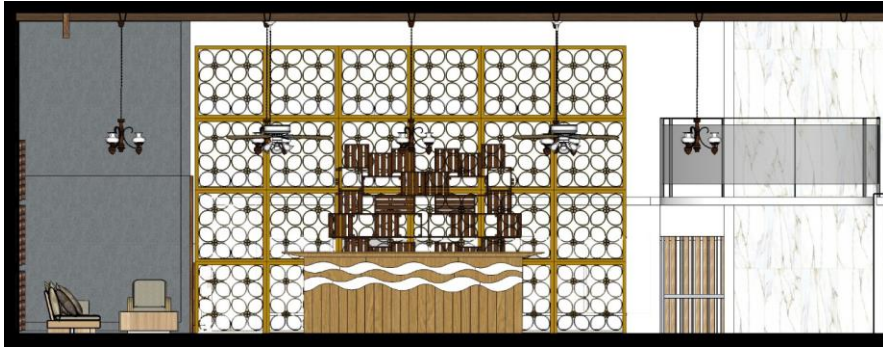

Tampak Potongan C-C Resepsionis Area

Sumber : Dokumen Pribadi 2018



Tampak Potongan D-D Resepsionis Area

Sumber : Dokumen Pribadi 2018



Tampak Atas Resepsionis Area

Sumber : Dokumen Pribadi 2018

LAMPIRAN



Erick Room View 1

Sumber : Dokumen Pribadi 2018



Erick Room View 2

Sumber : Dokumen Pribadi 2018

LAMPIRAN



Tampak Potongan E-E Erick Room Area

Sumber : Dokumen Pribadi 2018



Tampak Potongan F-F Erick Room Area

Sumber : Dokumen Pribadi 2018



Tampak Atas Erick Room Area

Sumber : Dokumen Pribadi 2018

LAMPIRAN



Restoran View 1

Sumber : Dokumen Pribadi 2018



Restoran View 2

Sumber : Dokumen Pribadi 2018

LAMPIRAN



Tampak Potongan A-A Restoran Area

Sumber : Dokumen Pribadi 2018





Tampak Potongan A-A Restoran Area

Sumber : Dokumen Pribadi 2018



Tampak Atas Restoran Area



Sumber : Dokumen Pribadi 2018

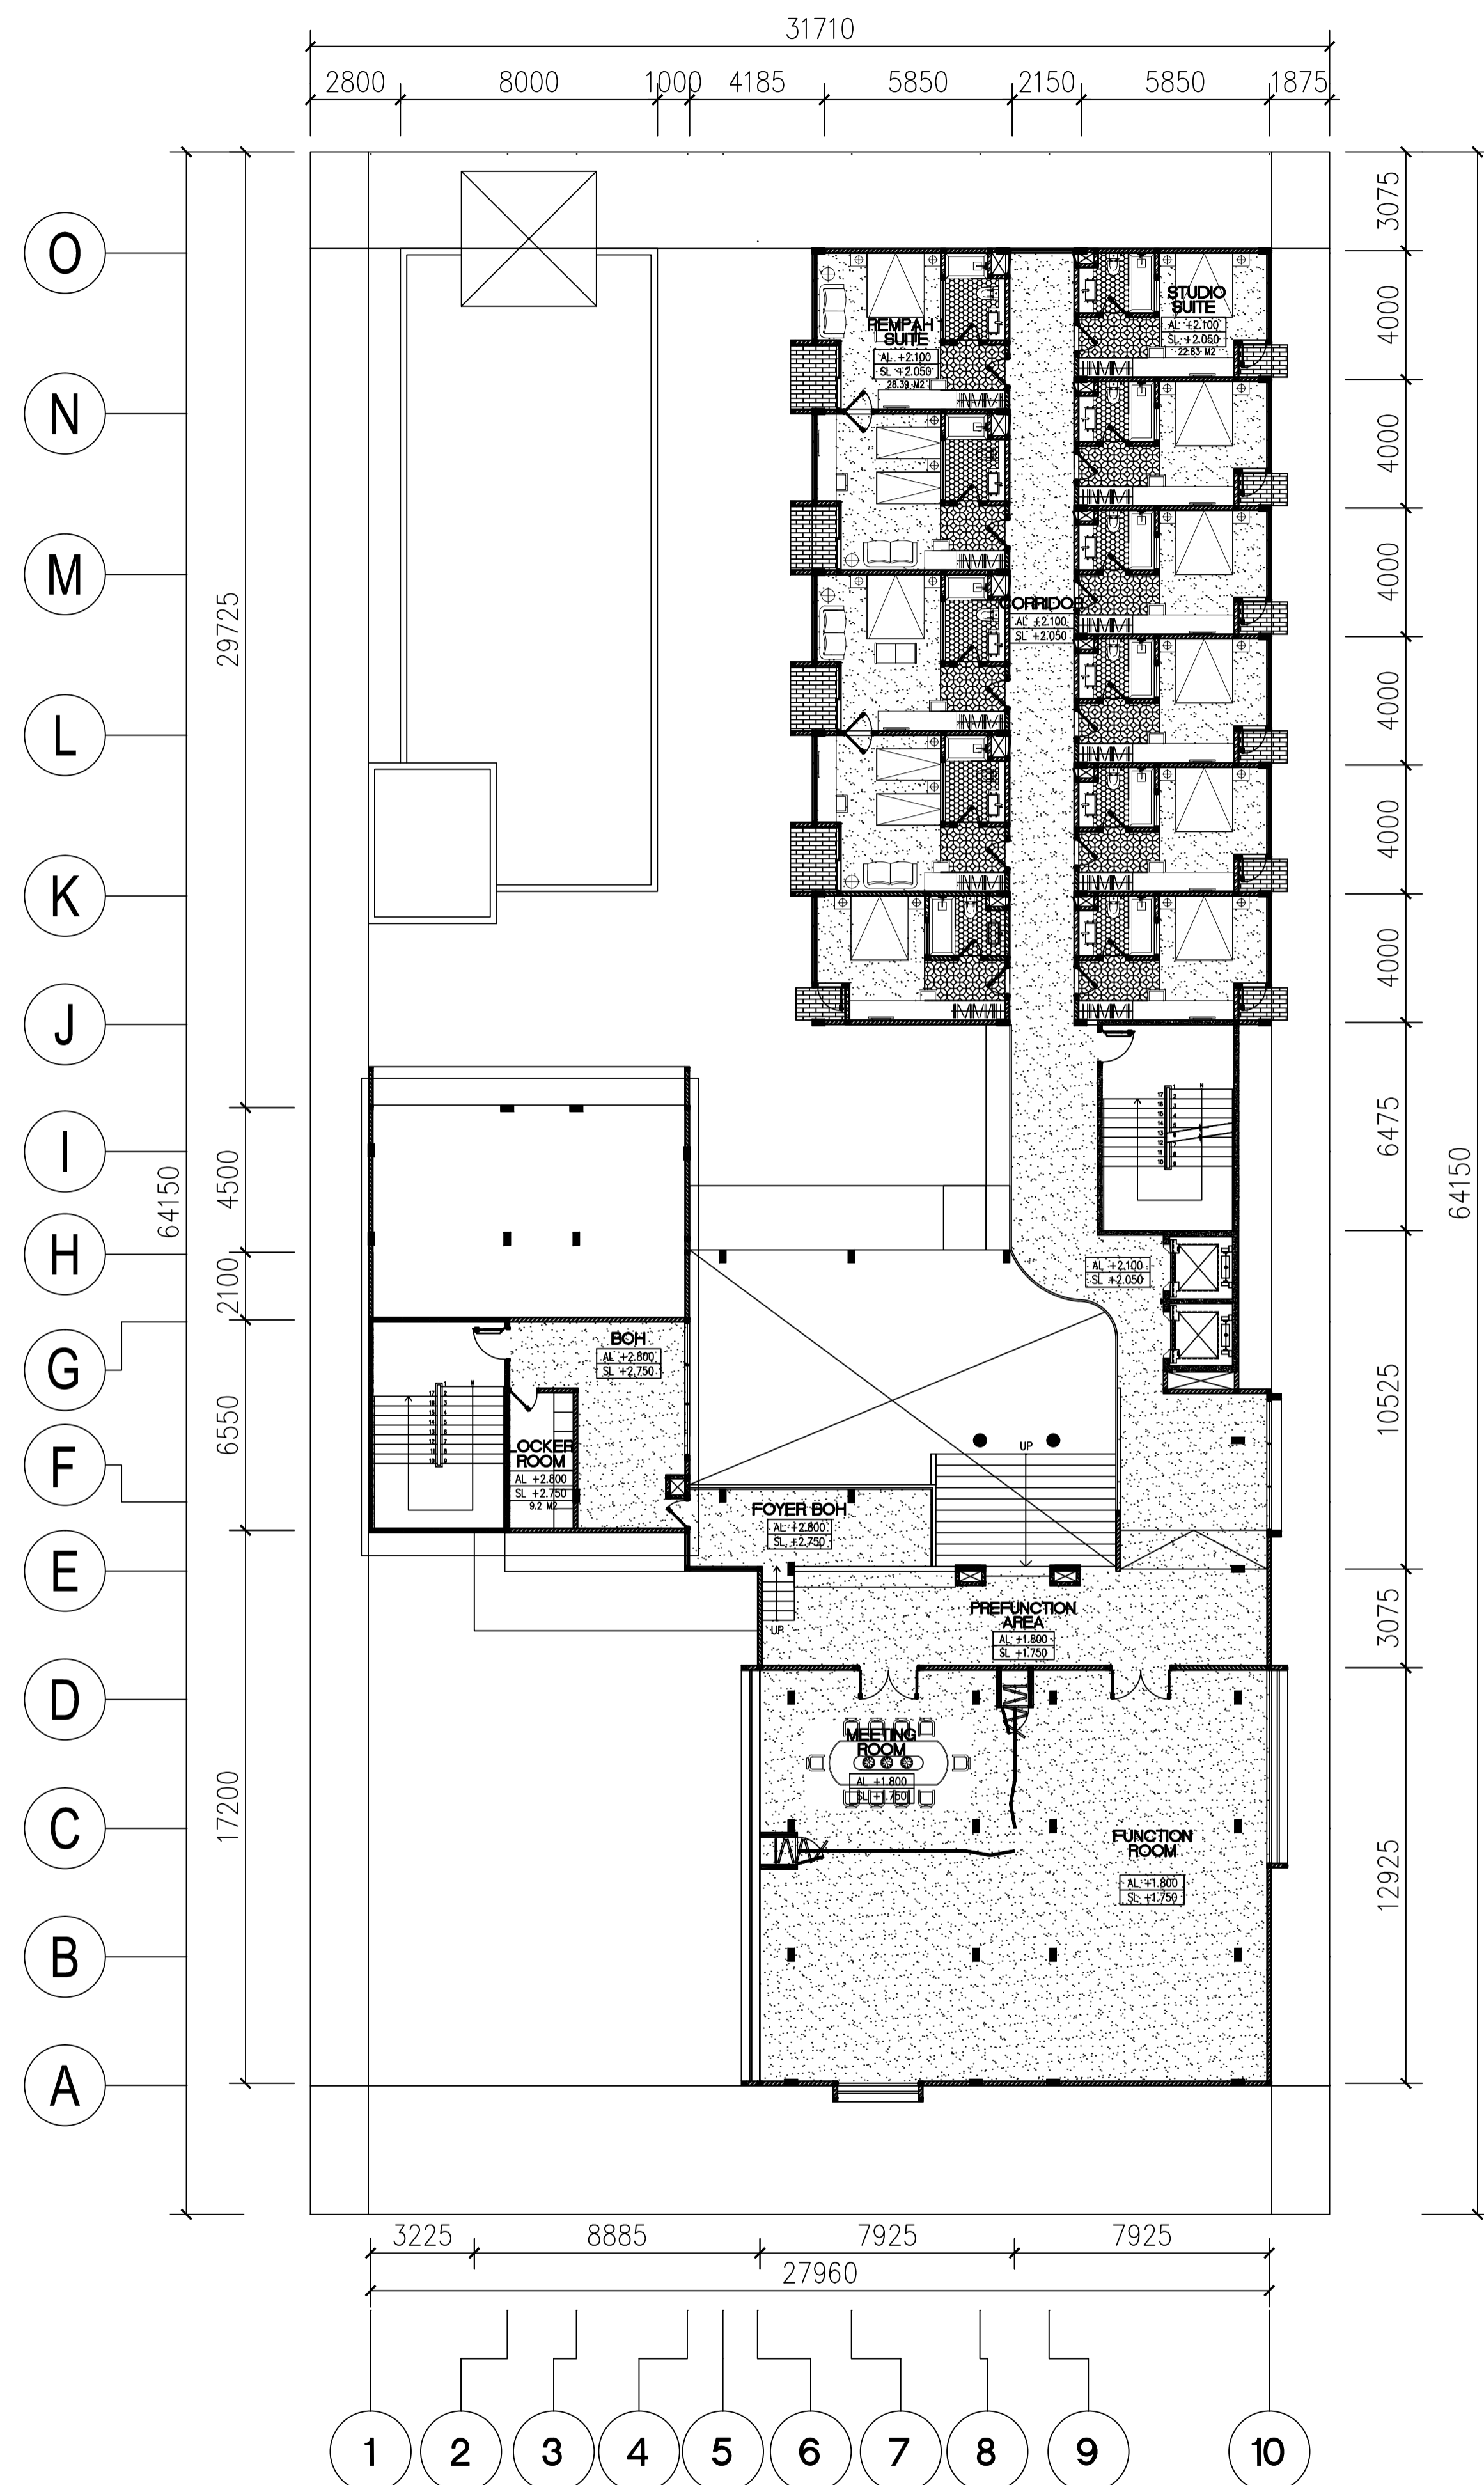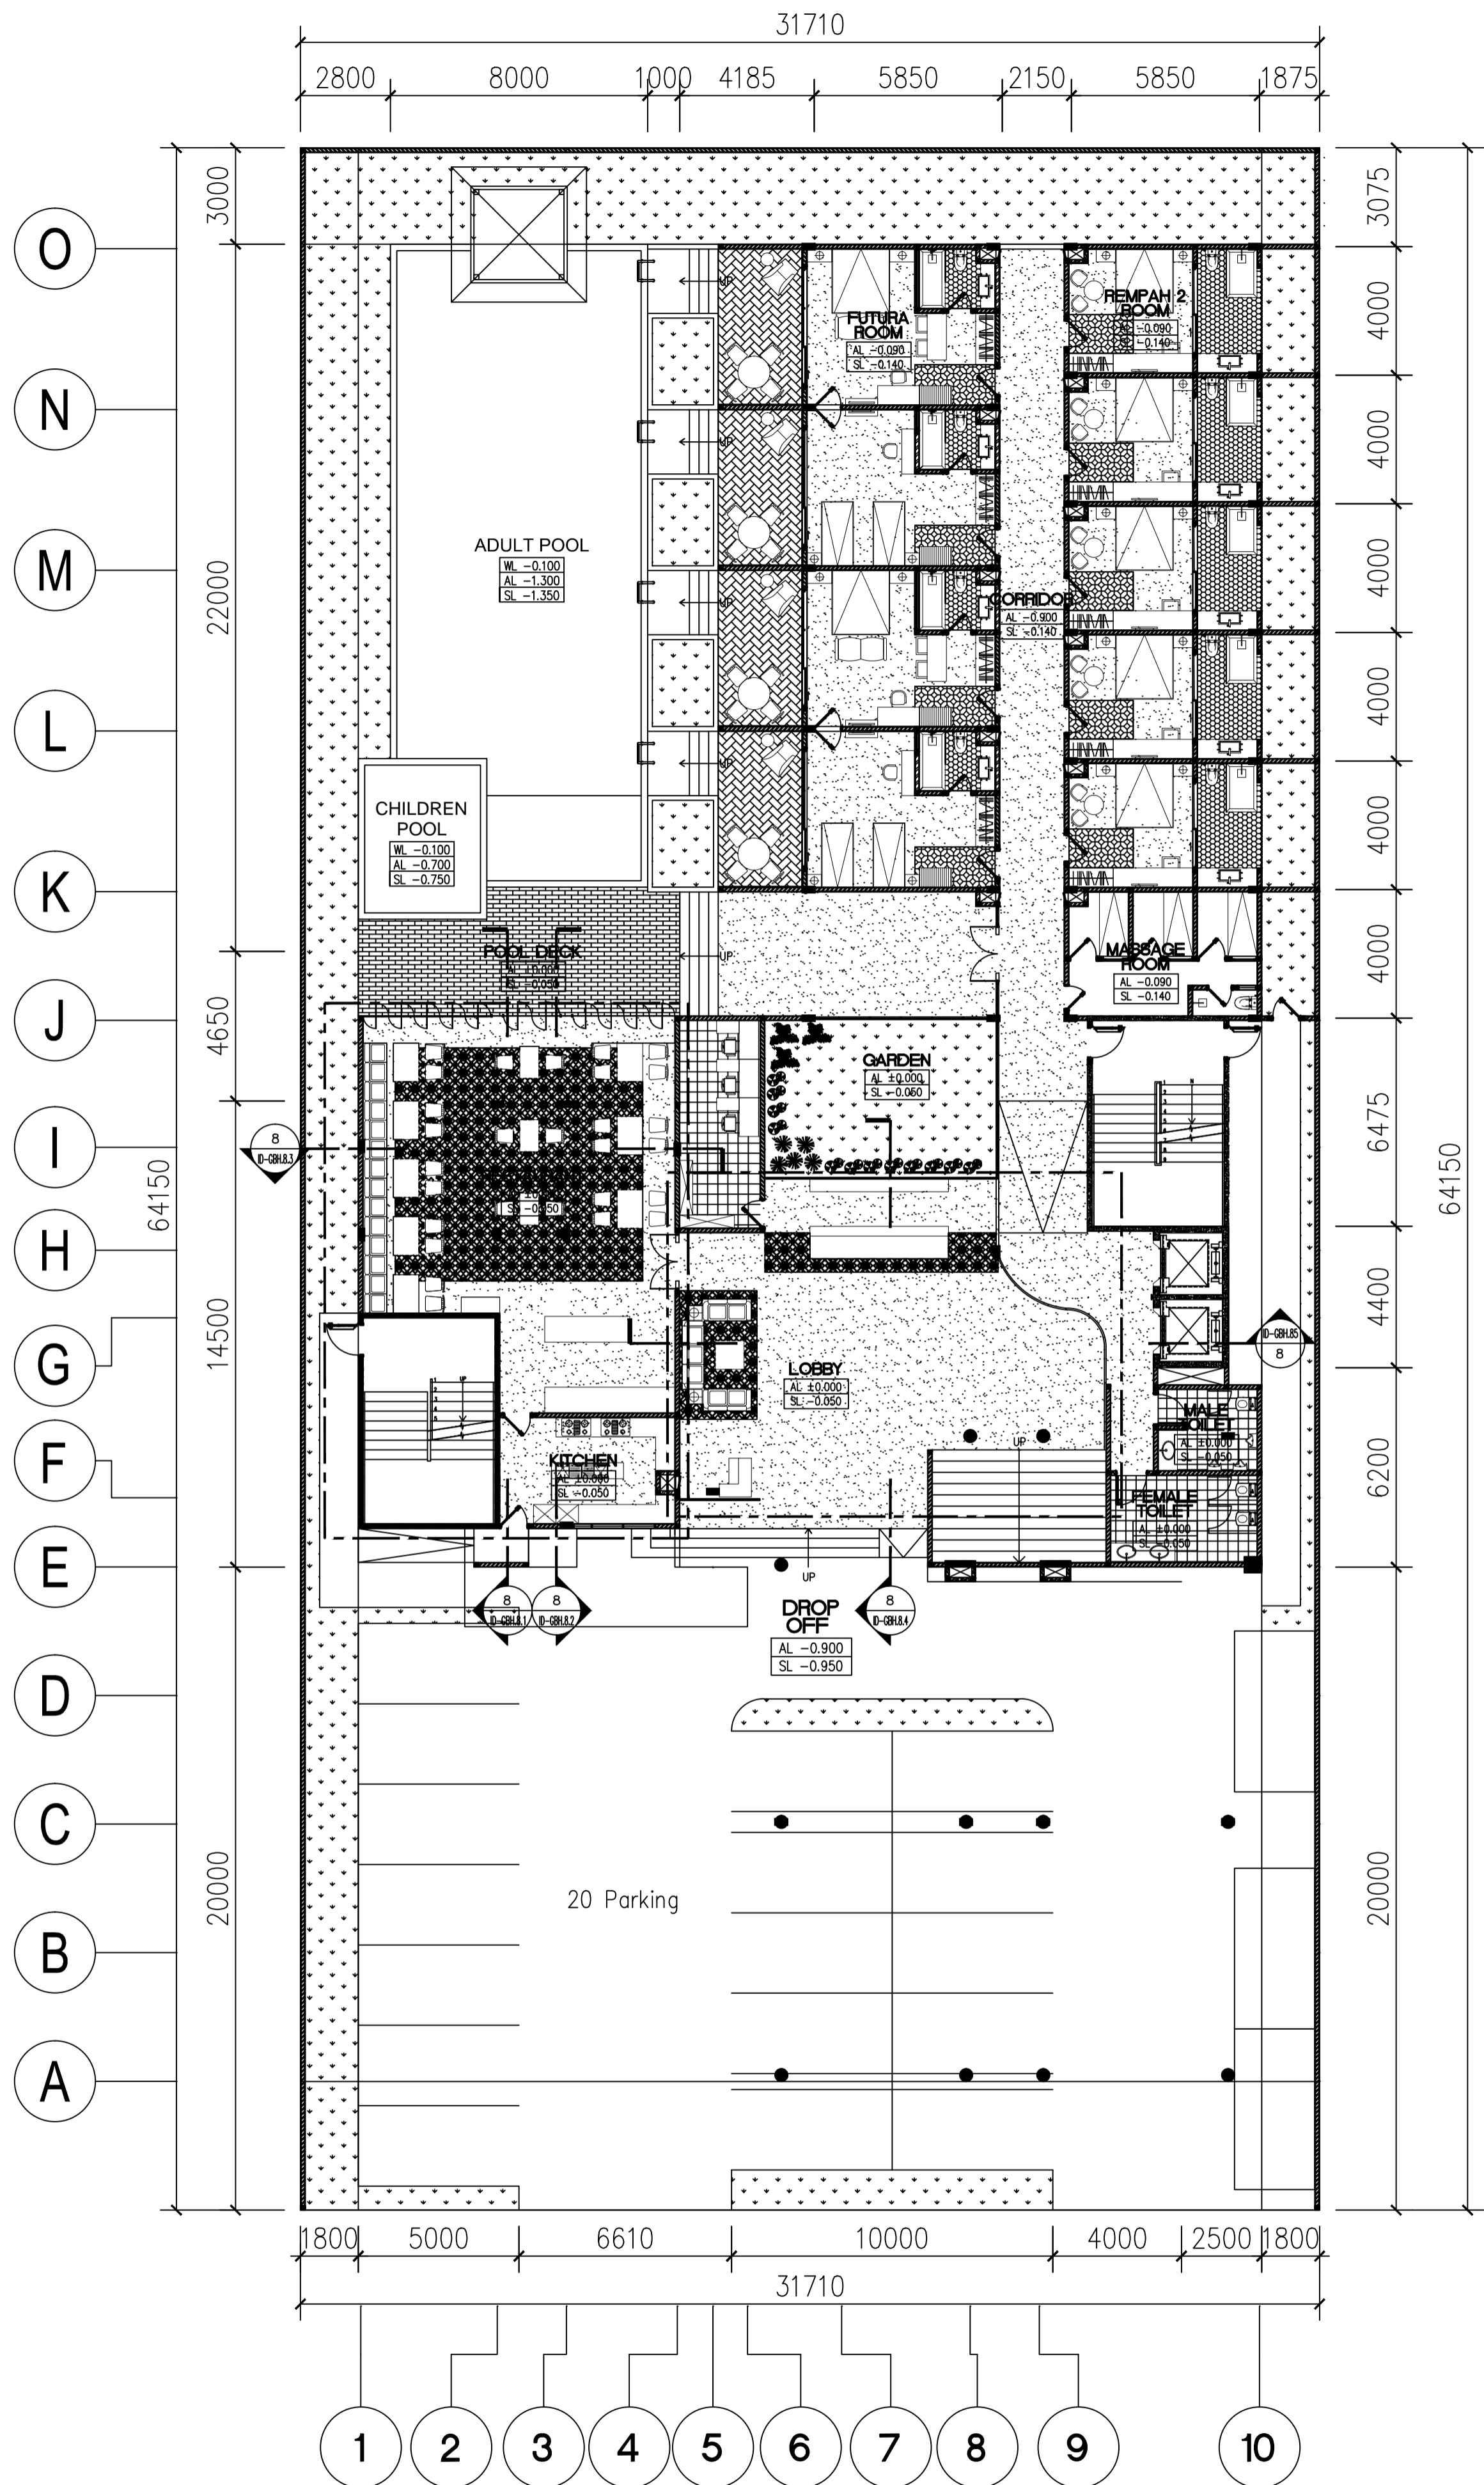


1
ID-GHB.1.0
GROUND FLOOR
LAYOUT PLAN
SCALE 1:150

1
ID-GHB.1.1
FIRST FLOOR
LAYOUT PLAN
SCALE 1:150

LEGEND	
 UNIVERSITAS MERCU BUANA	
NAMA PROYEK :	
PERANCANGAN INTERIOR GREENHOST BOUTIQUE HOTEL	
JUDUL GAMBAR :	
LAYOUT KESELURUHAN LT. GROUND & LT. SATU	
NAMA :	
FARID FADILAH	
NIM :	
41714010020	
DOSEN PEMBIMBING :	
YOHANES NUGROHO UTOMO, Drs, M.Ds	
SKALA :	1 : 150
JUMLAH GAMBAR :	NOMOR GAMBAR :
1/21	ID-GBH.1.0 ID-GBH.1.1
NILAI :	PARAF :

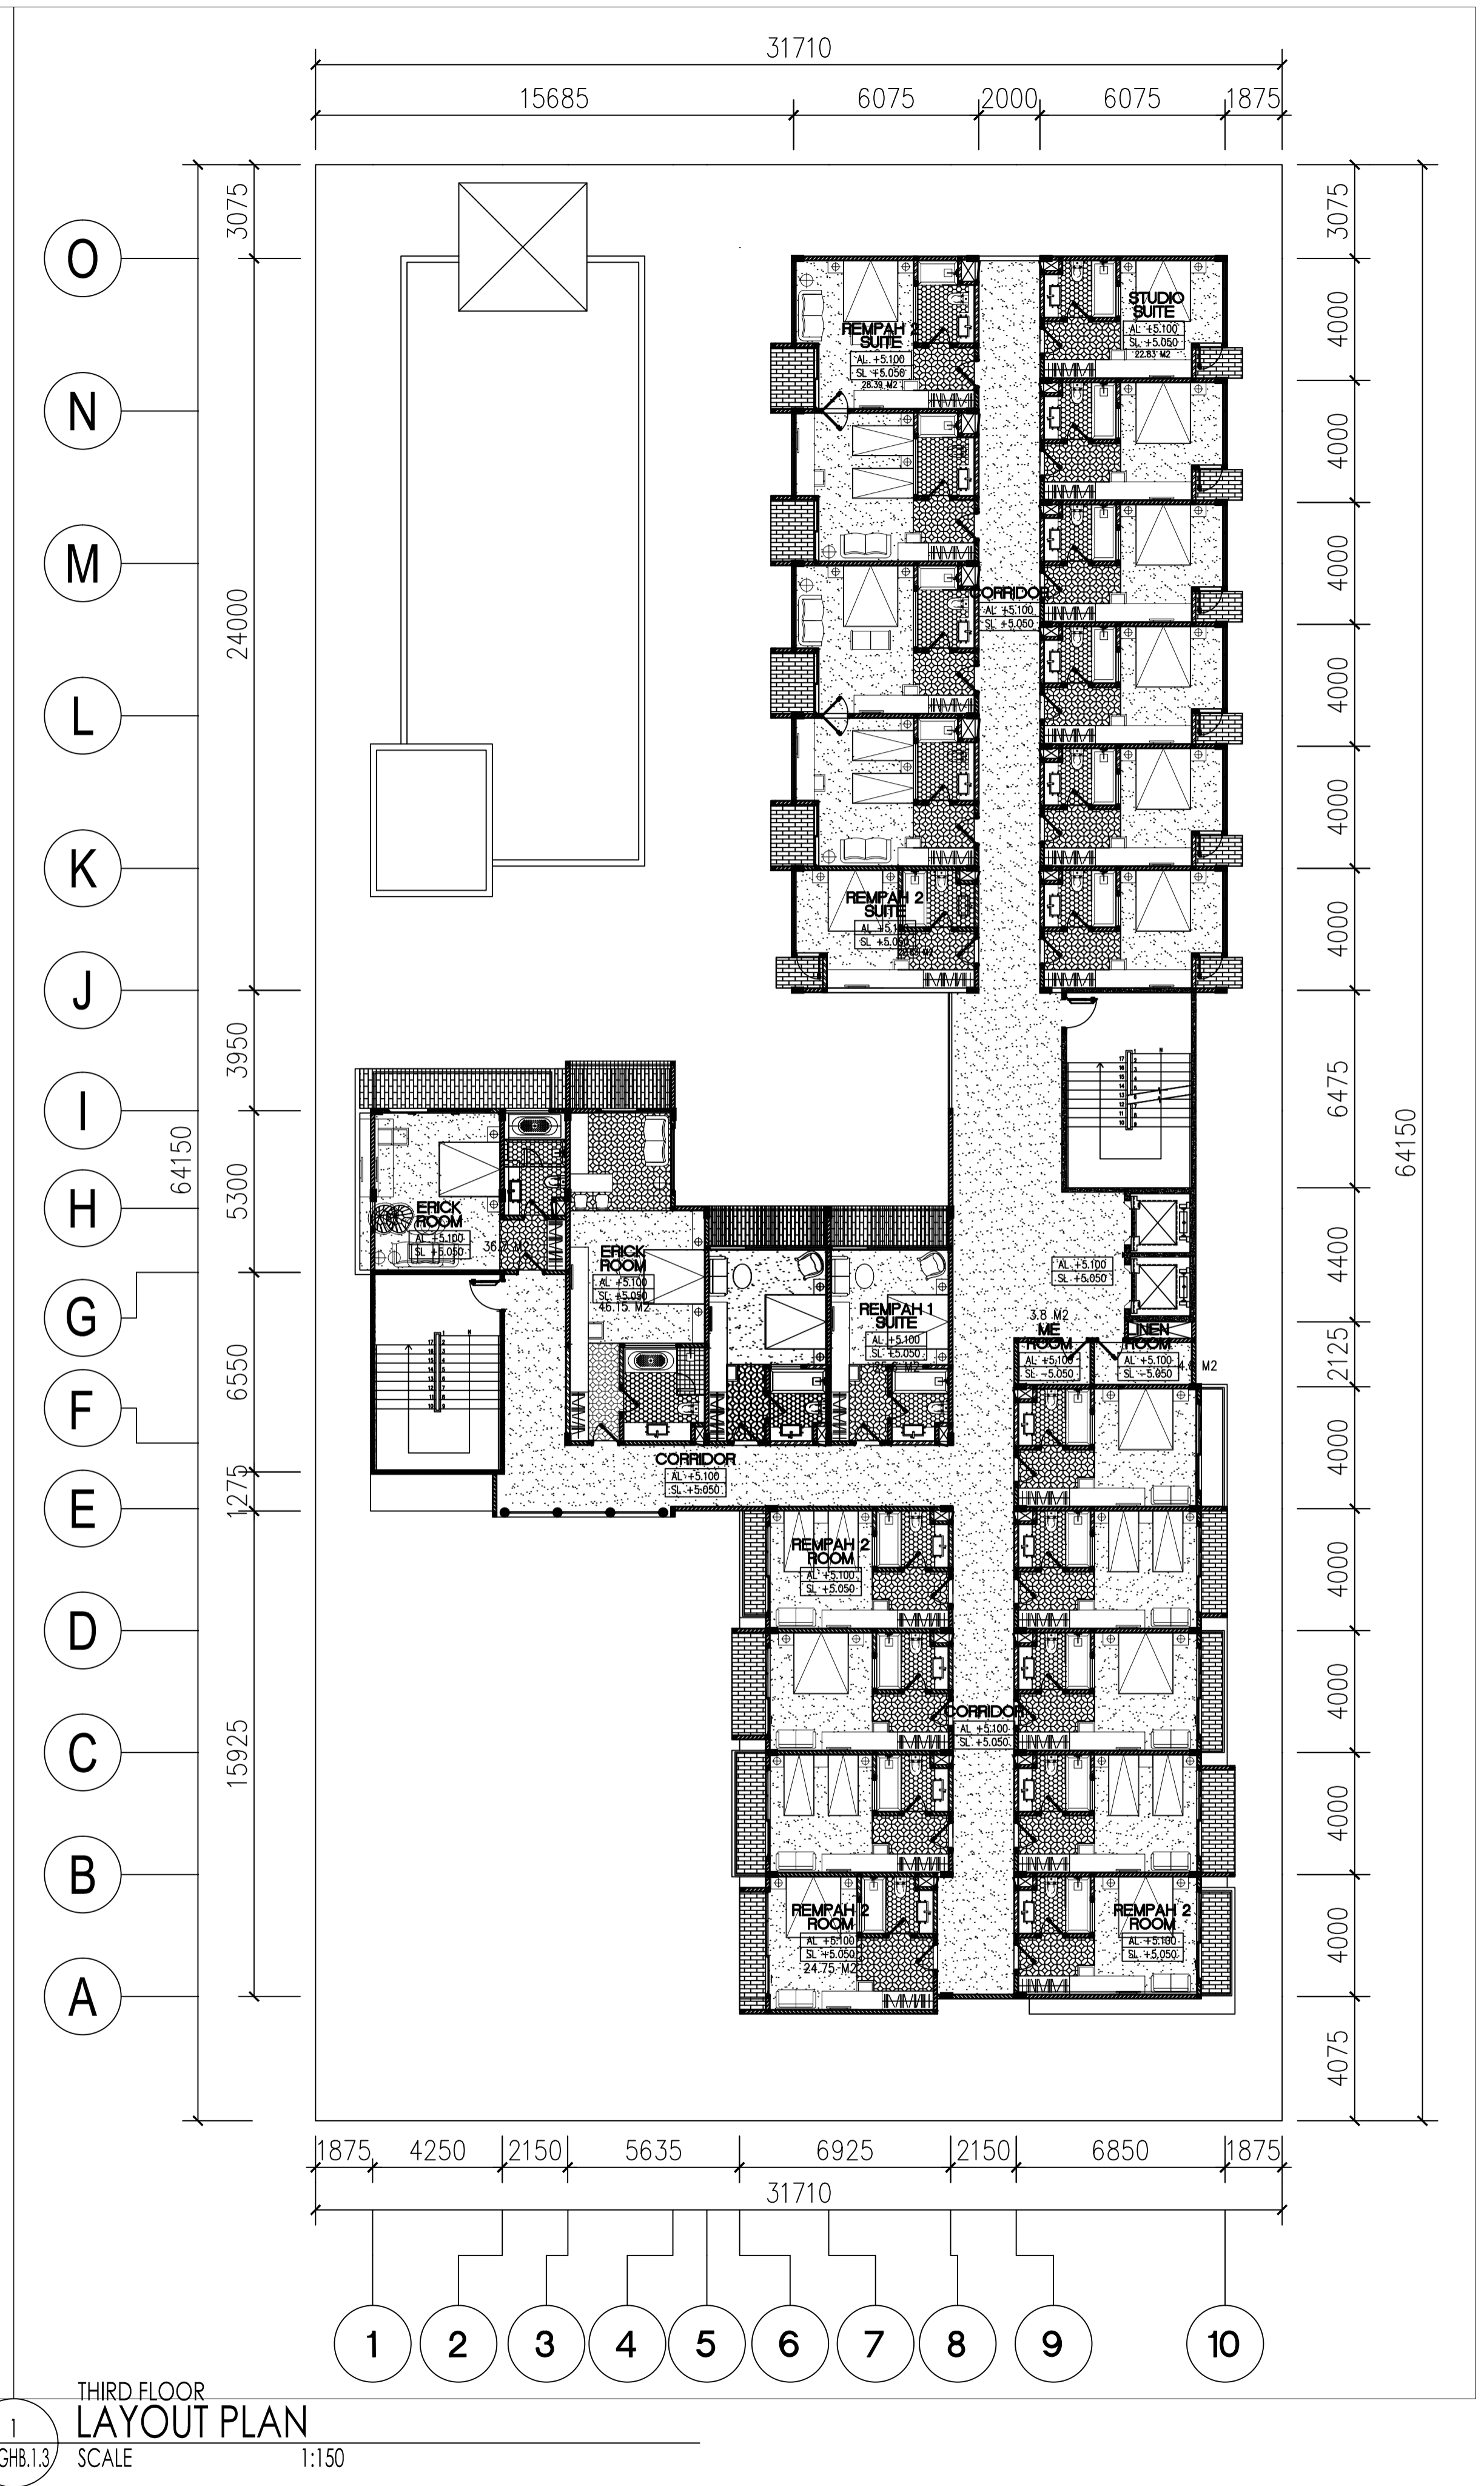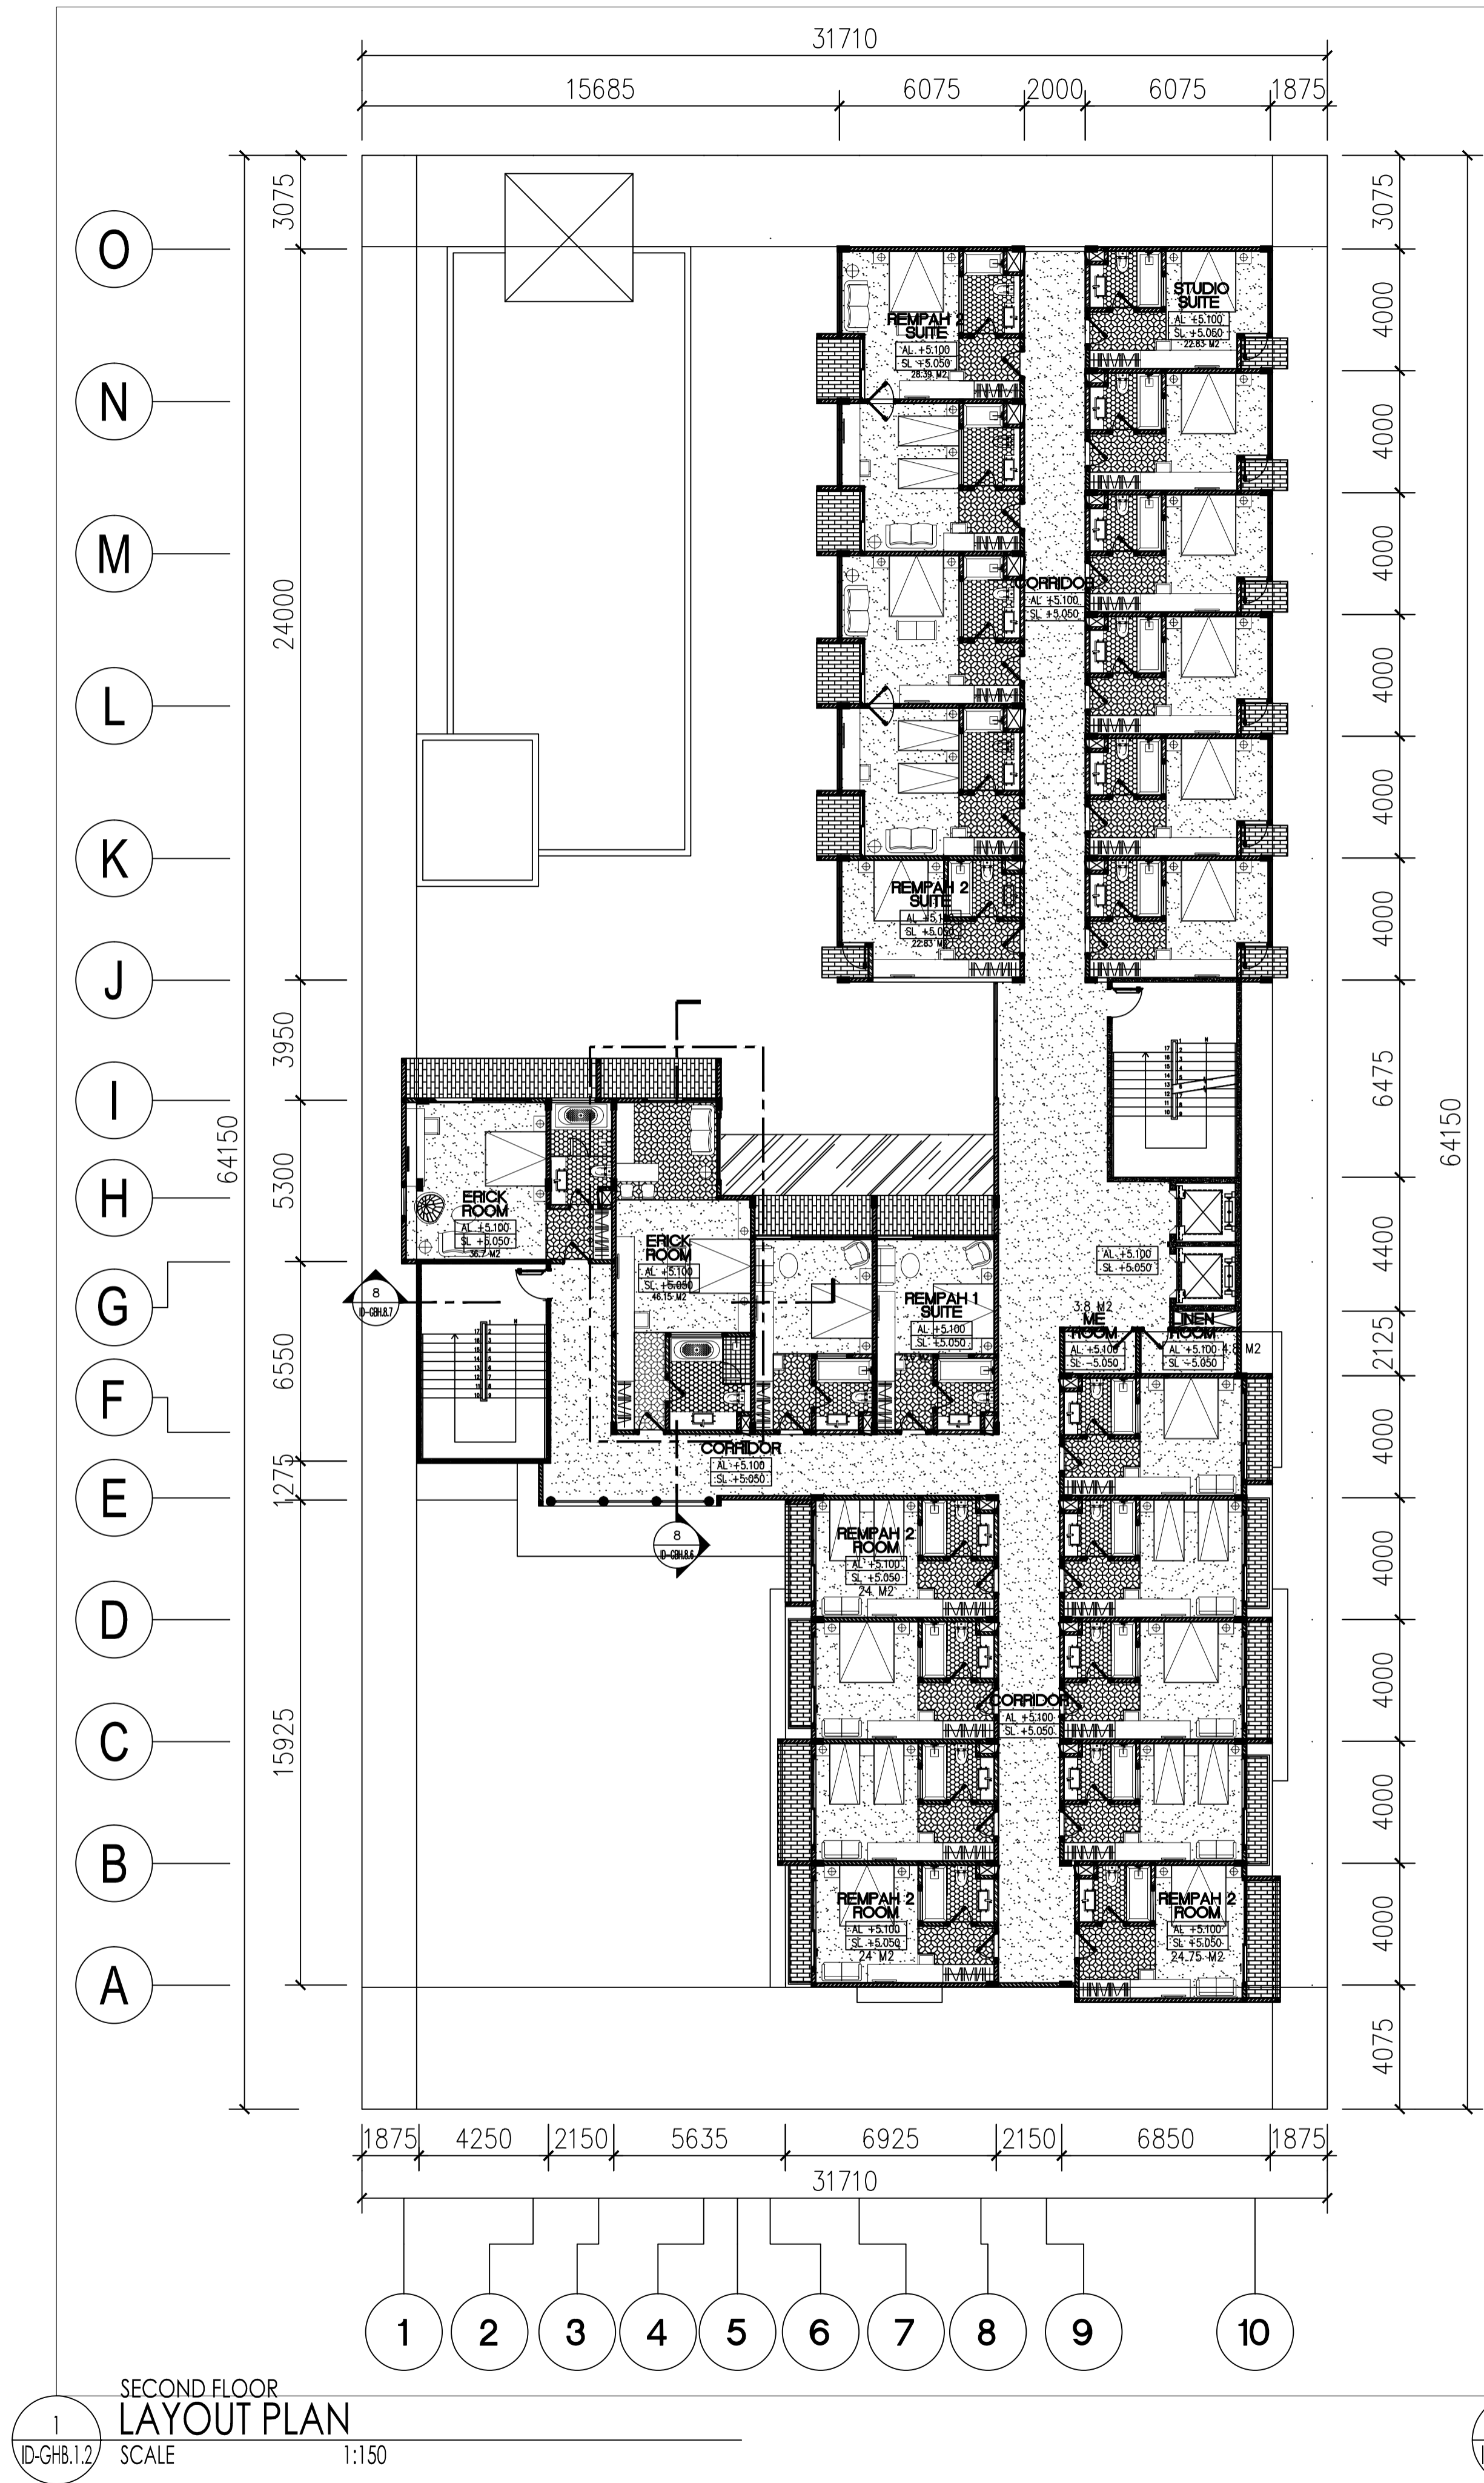

LEGEND

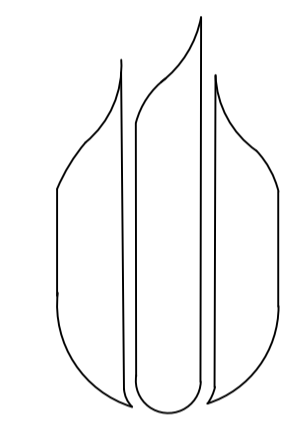

UNIVERSITAS
MERCU BUANA

NAMA PROYEK :

PERANCANGAN INTERIOR
GREENHOST BOUTIQUE HOTEL

JUDUL GAMBAR :

LAYOUT KESELURUHAN
LT. DUA & LT. TIGA

NAMA :

FARID FADILAH

NIM :

41714010020

DOSEN PEMBIMBING :


YOHANES NUGROHO UTOMO, Drs, M.Ds

SKALA : 1 : 150

JUMLAH GAMBAR : NOMOR GAMBAR :


2/21 ID-GBH.1.2
ID-GBH.1.3

NILAI : PARAF :

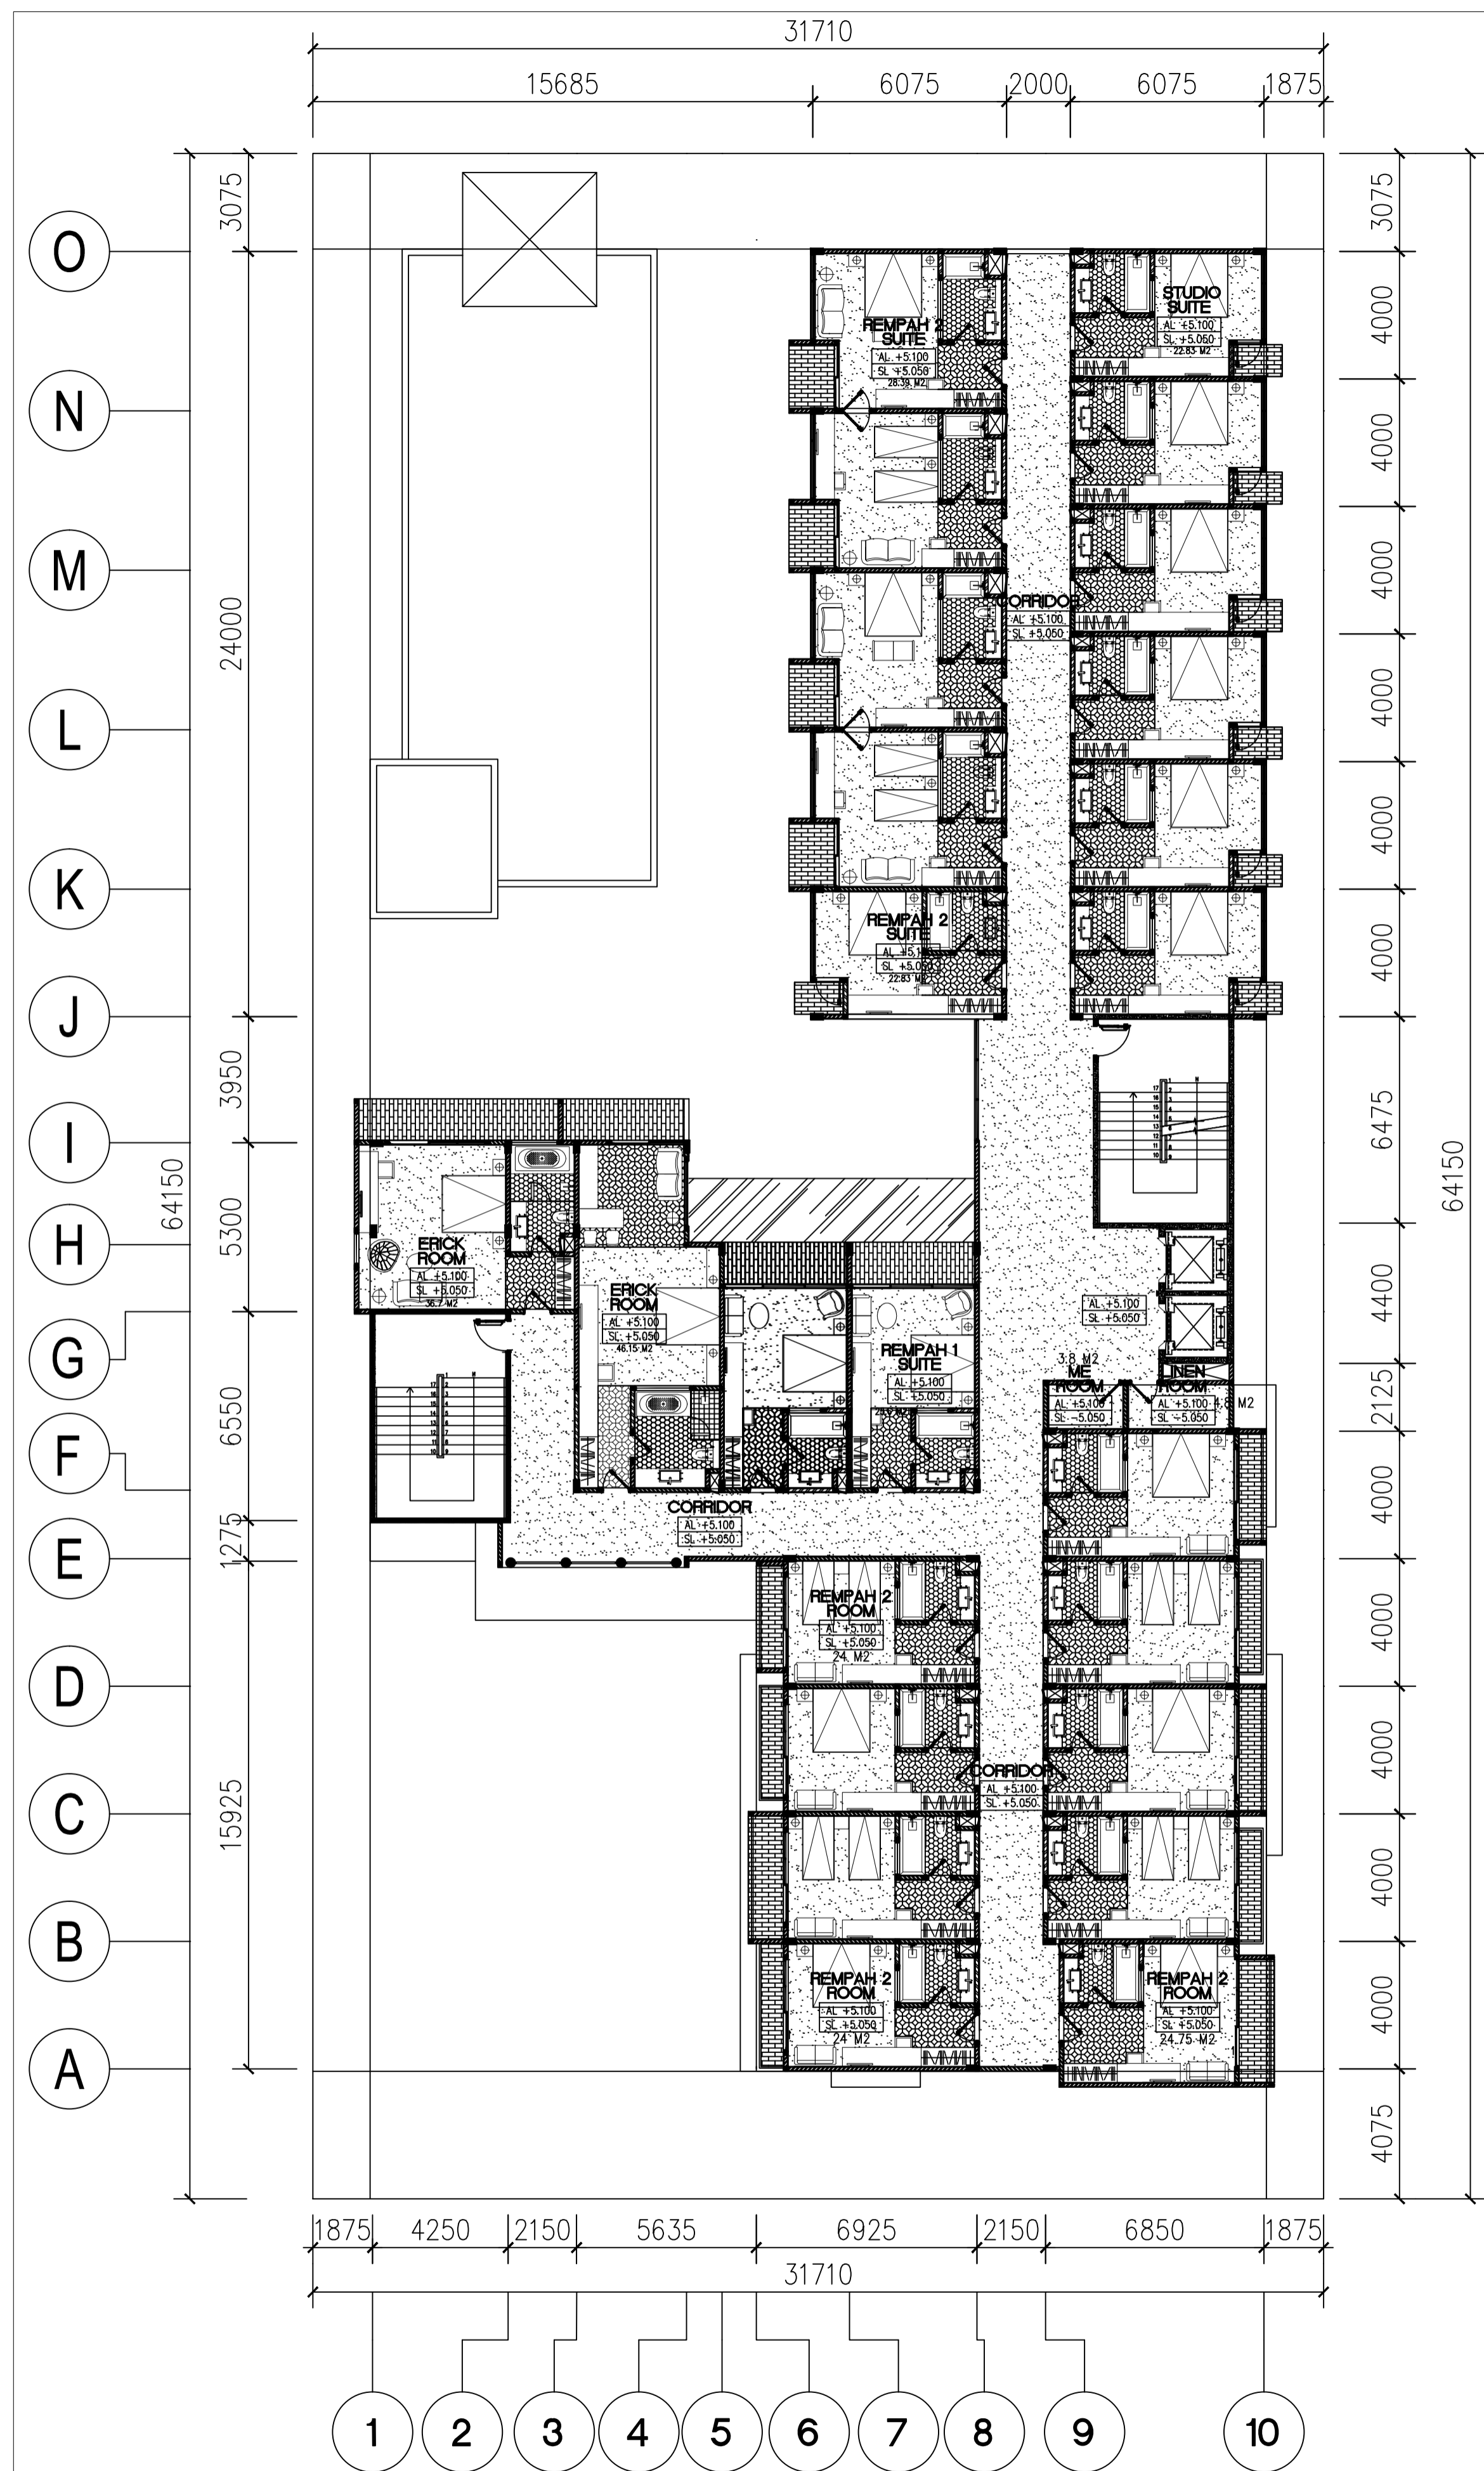

1
ID-GHB.1.4


FOURTH FLOOR
LAYOUT PLAN
SCALE 1:150

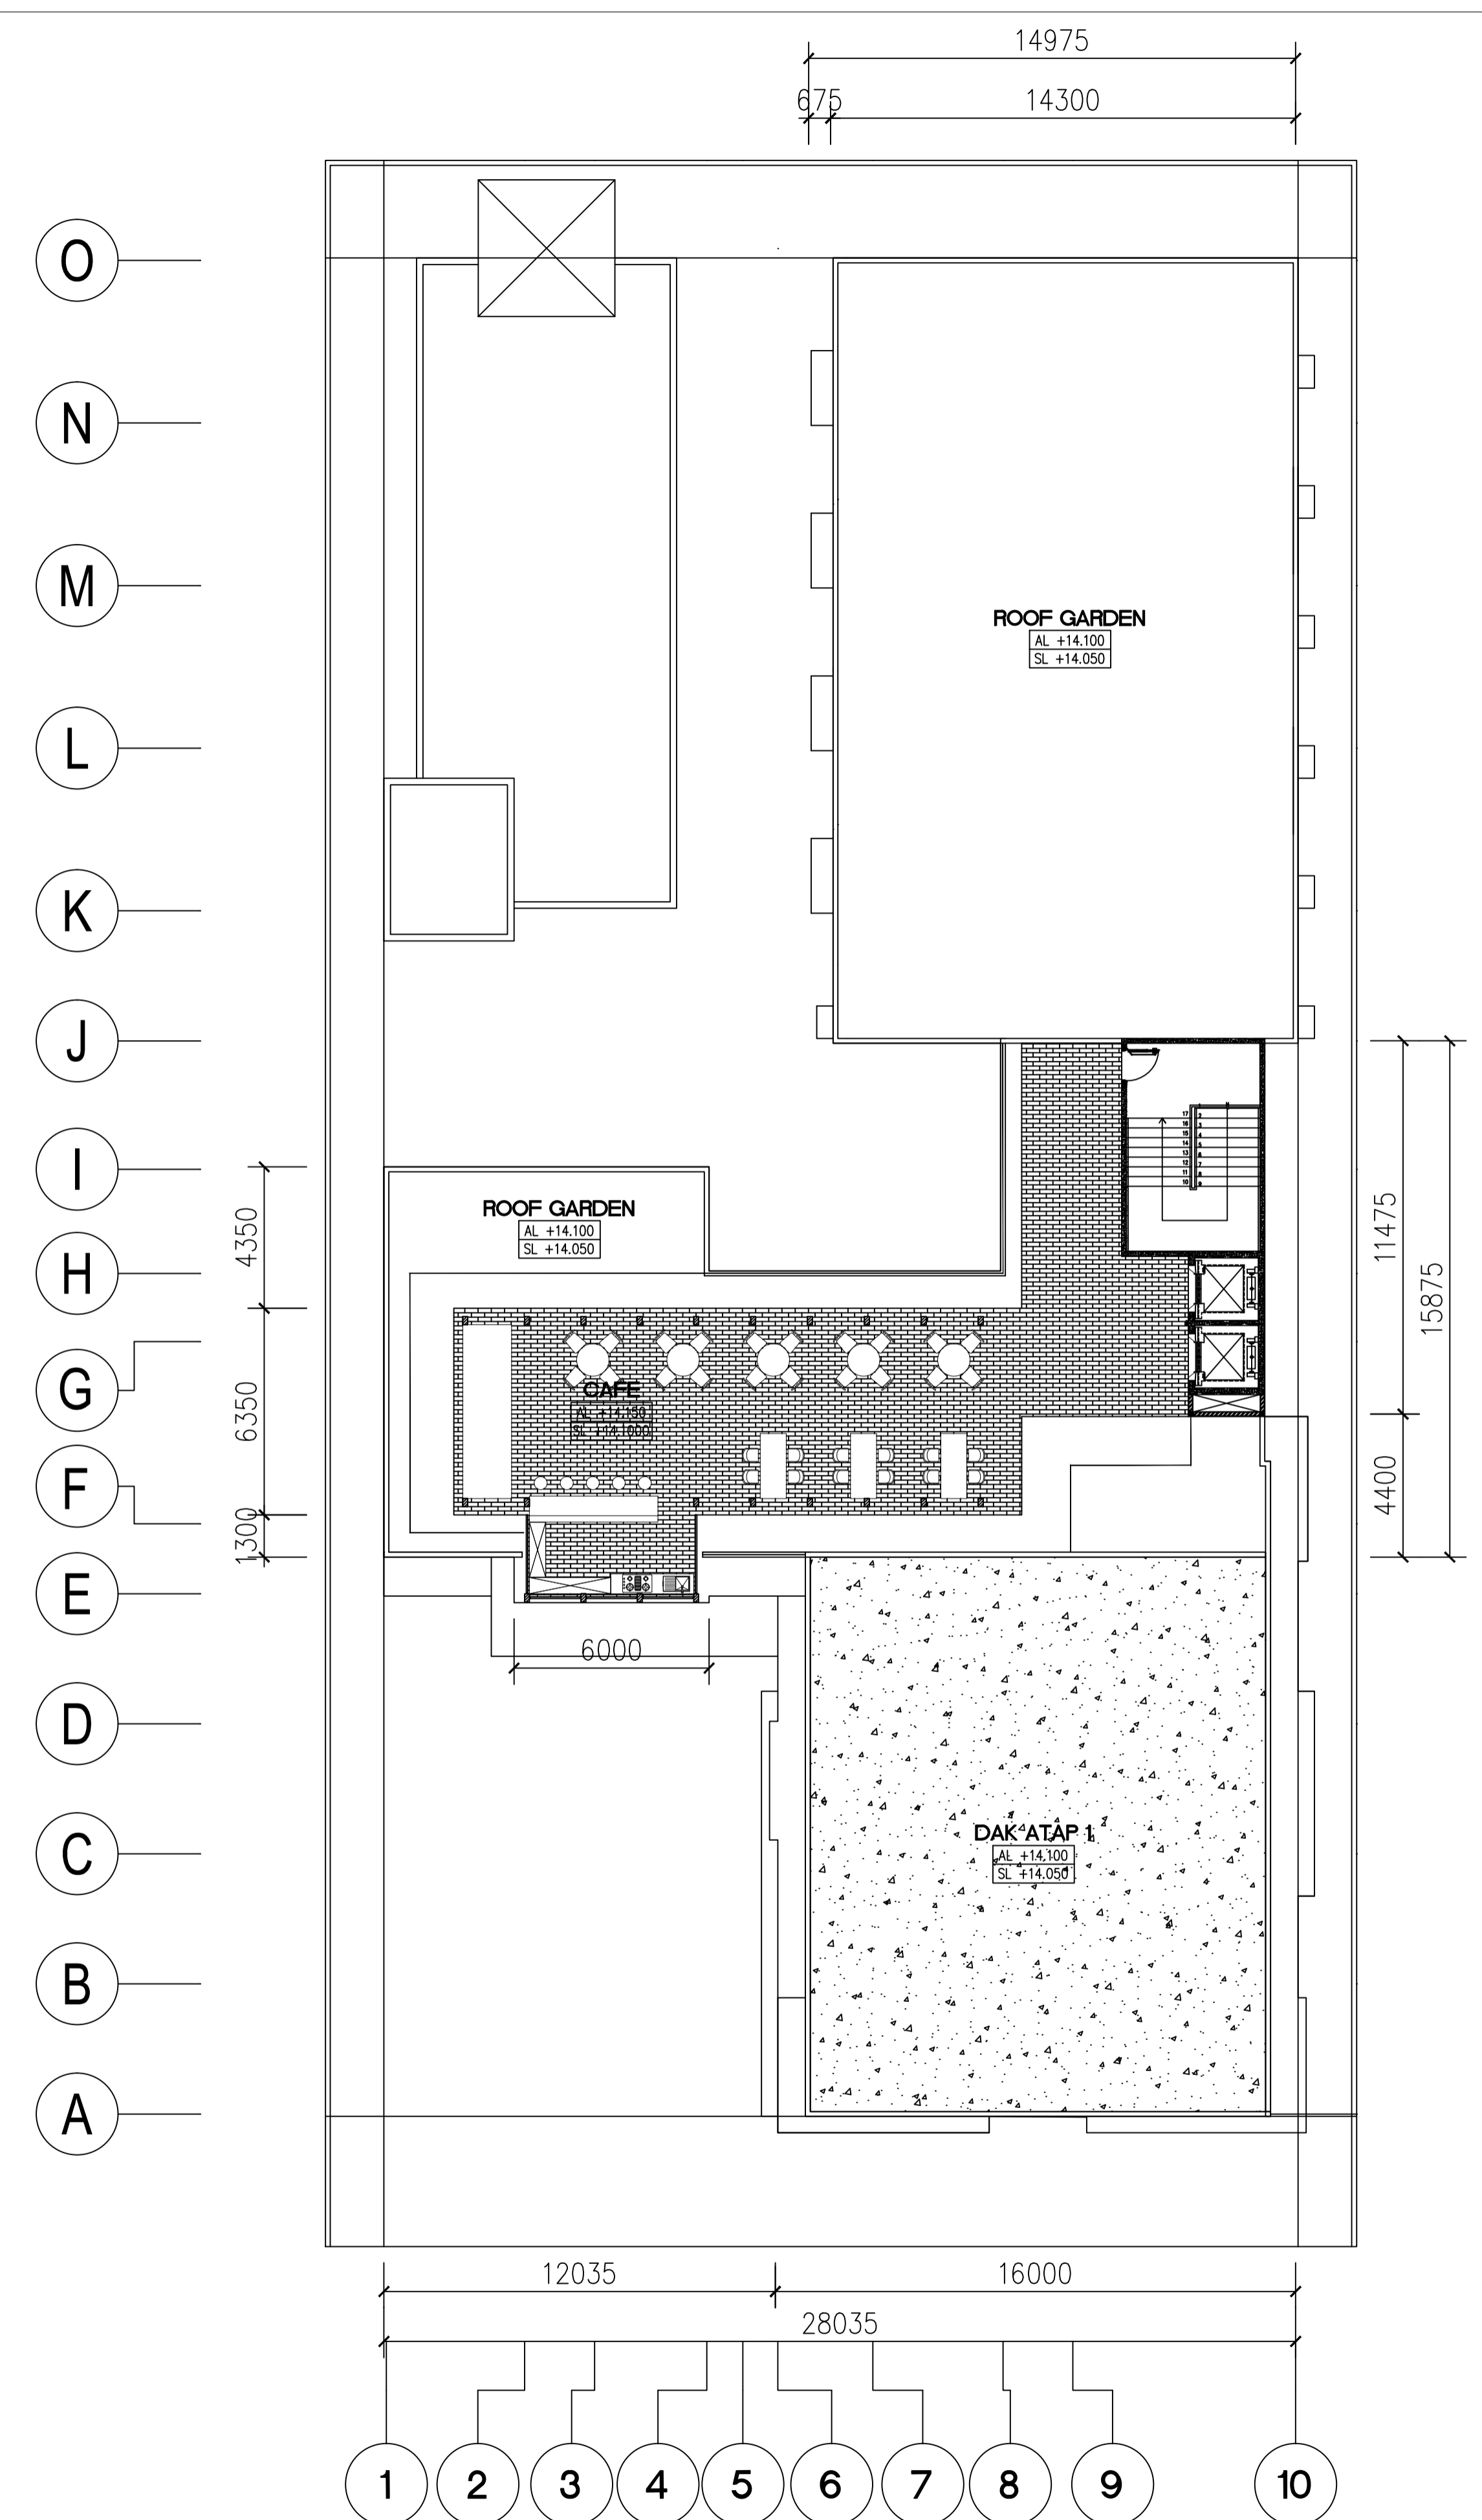

1
ID-GHB.1.5

FIFTH FLOOR
LAYOUT PLAN
SCALE 1:150

LEGEND

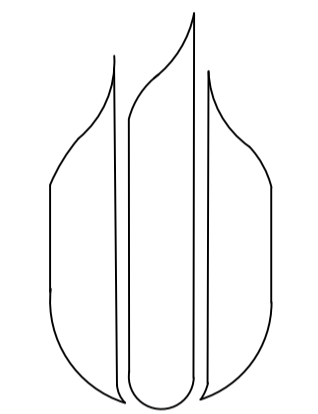

UNIVERSITAS
MERCU BUANA

NAMA PROYEK :

PERANCANGAN INTERIOR
GREENHOST BOUTIQUE HOTEL

JUDUL GAMBAR :

LAYOUT KESELURUHAN
LT. EMPAT & LT. LIMA

NAMA :

FARID FADILAH

NIM :

41714010020

DOSEN PEMBIMBING :

YOHANES NUGROHO UTOMO, Drs, M.Ds

SKALA : 1 : 150


JUMLAH GAMBAR : NOMOR GAMBAR :

3/21


ID-GBH.1.4
ID-GBH.1.5

NILAI :


PARAF :

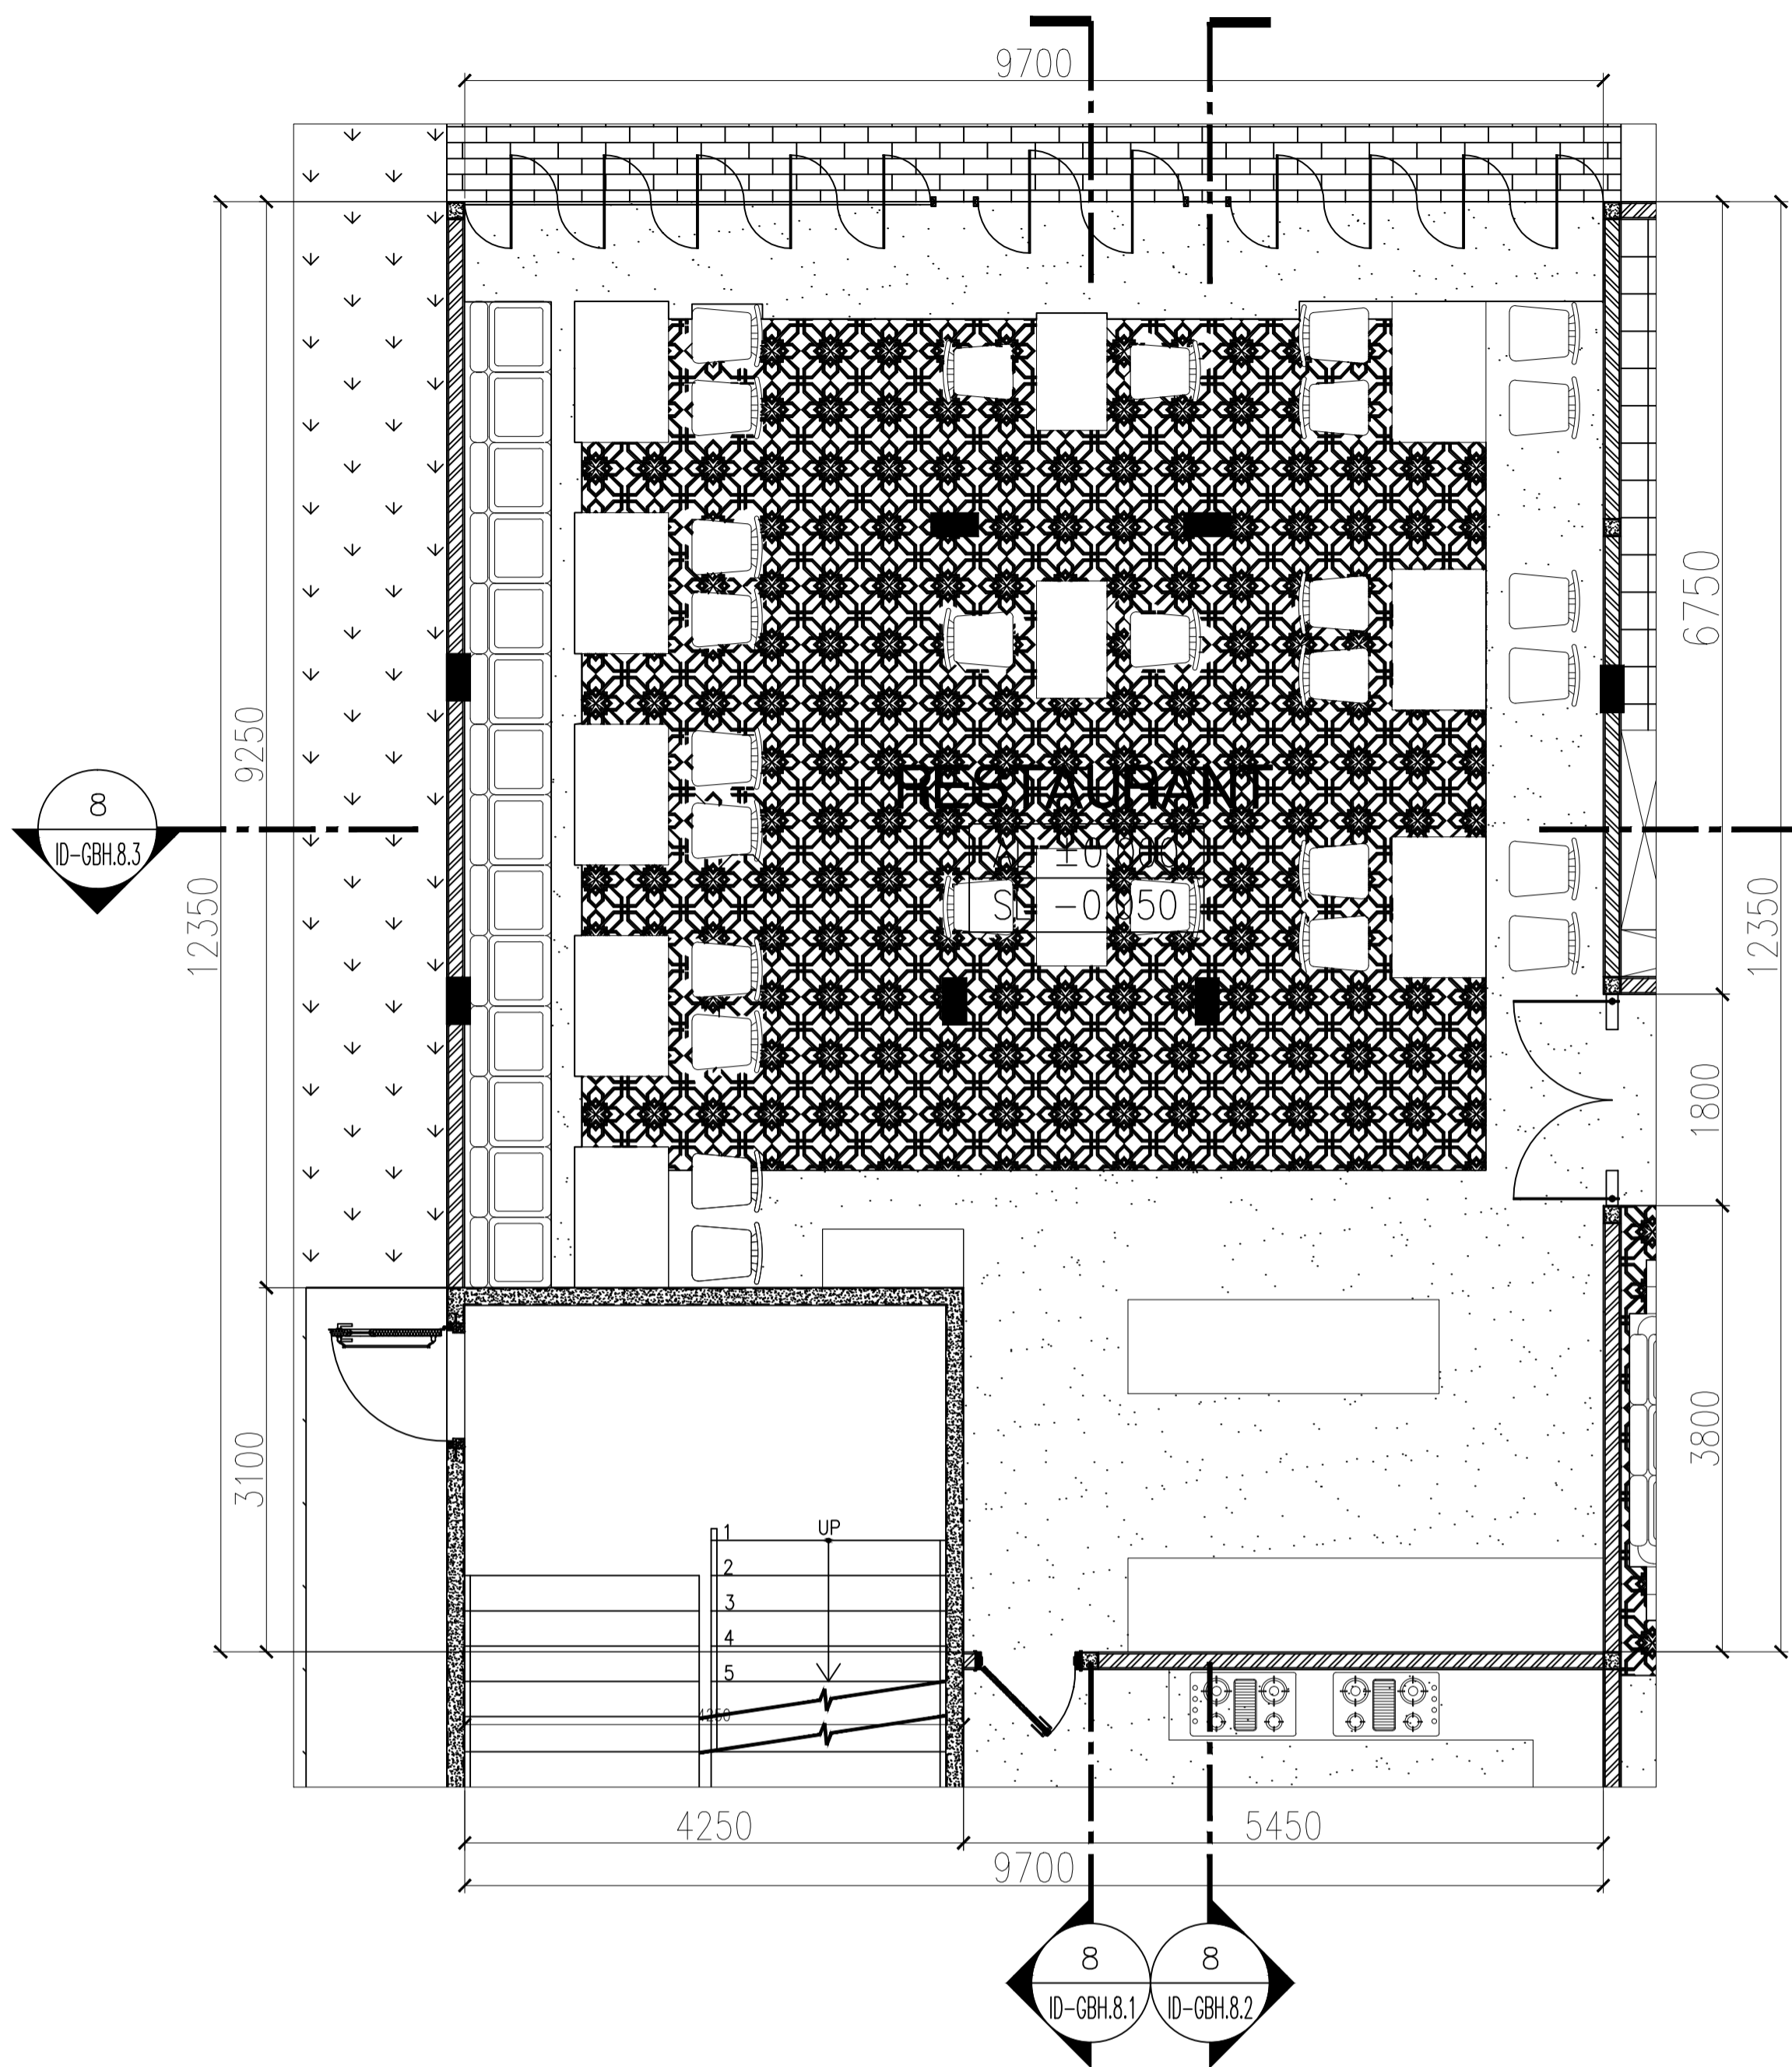


1 GORUND FLOOR RESTAURANT LAYOUT PLAN
ID-GBH.1.6 SCALE 1:50

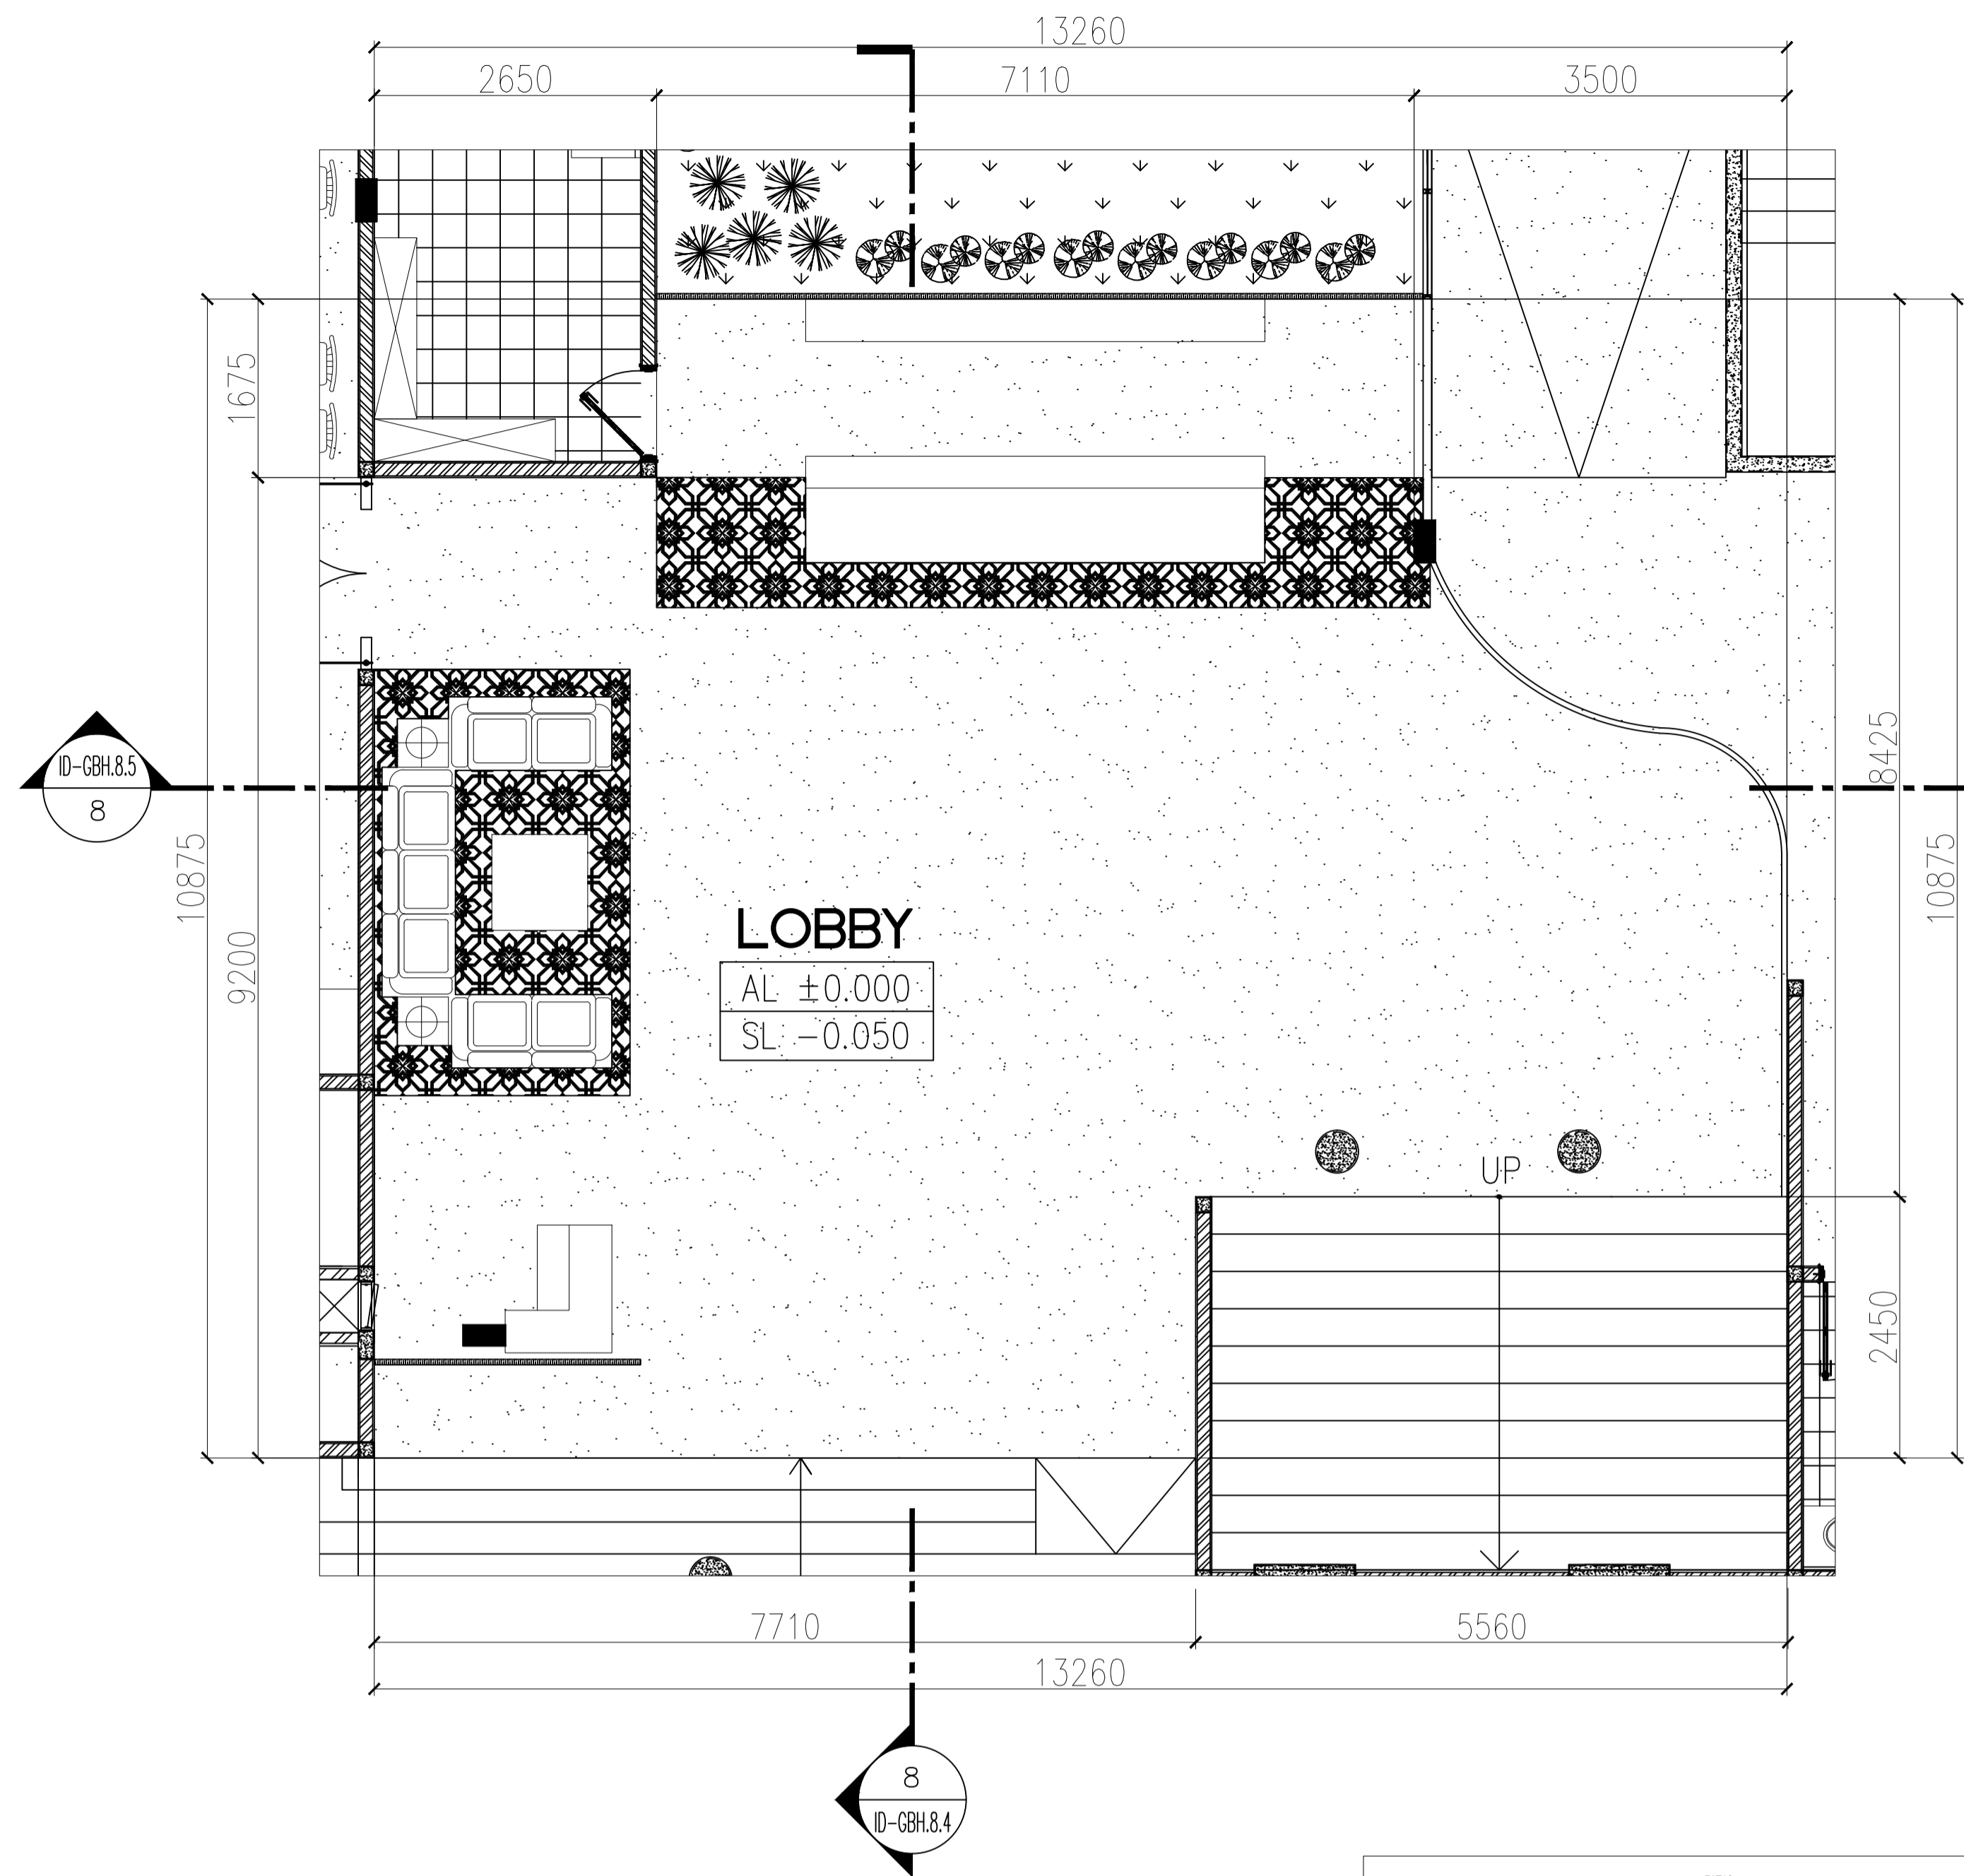

1 GORUND FLOOR RECEPTIONIST LAYOUT PLAN
ID-GBH.1.7 SCALE 1:50

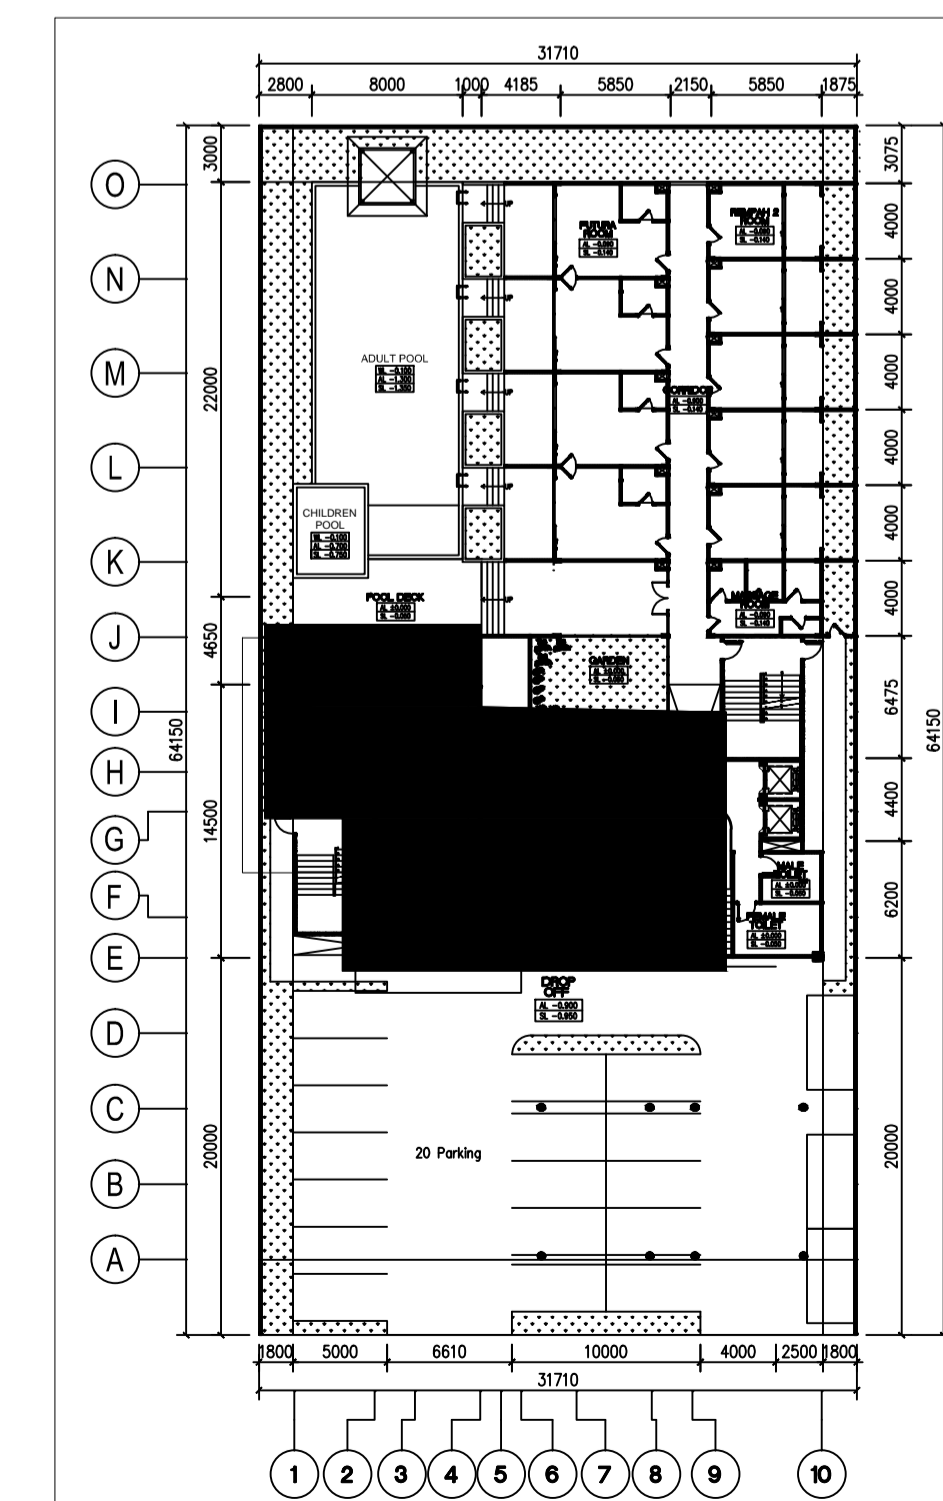

LEGEND

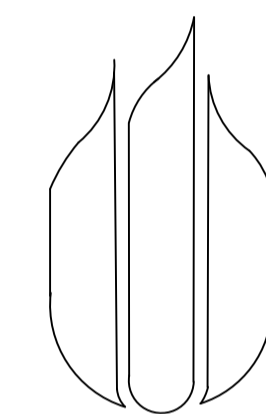

UNIVERSITAS
MERCU BUANA

NAMA PROYEK :

PERANCANGAN INTERIOR
GREENHOST BOUTIQUE HOTEL

JUDUL GAMBAR :

PARTICULAR LAYOUT LT. GROUND
(RESTAURANT & RECEPTIONIST)

NAMA :

FARID FADILAH

NIM :

41714010020

DOSEN PEMBIMBING :

YOHANES NUGROHO UTOMO, Drs, M.Ds

SKALA : 1 : 50


JUMLAH GAMBAR : NOMOR GAMBAR :

4/21


ID-GBH.1.6
ID-GBH.1.7

NILAI :


PARAF :

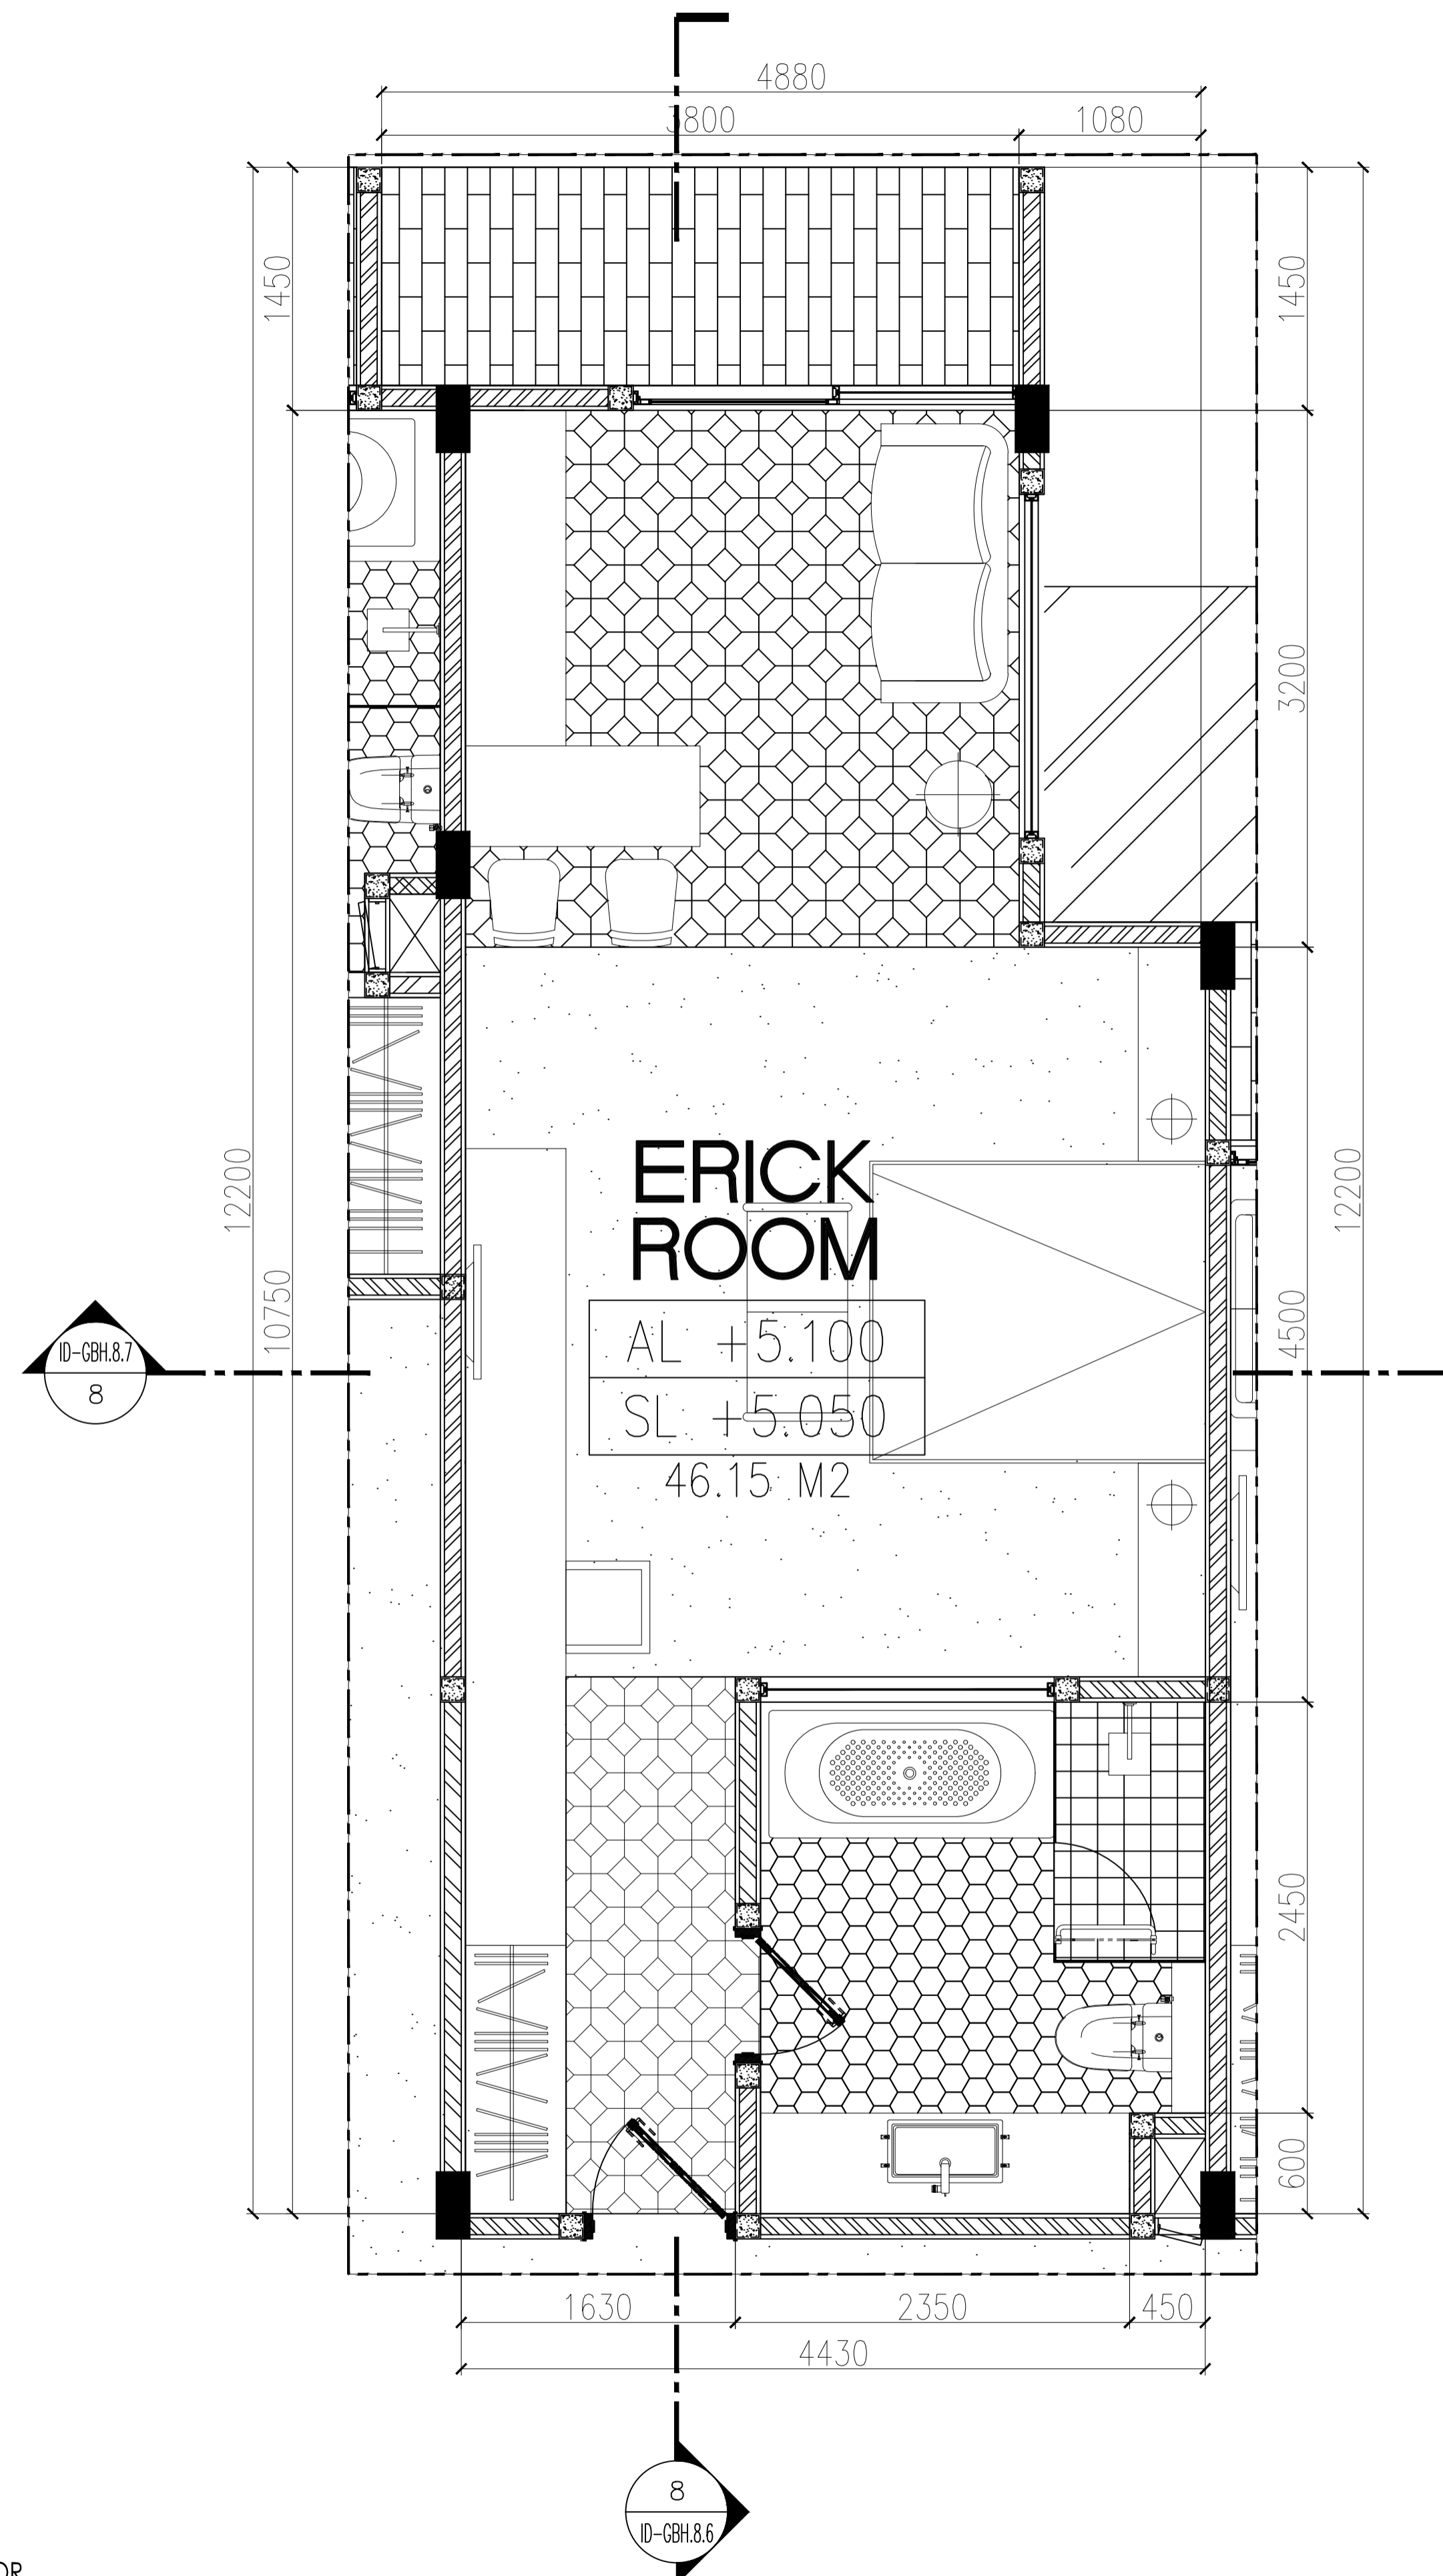

1
ID-GHB.1.8
THIRD FLOOR
ERICK ROOM LAYOUT PLAN
SCALE 1:30

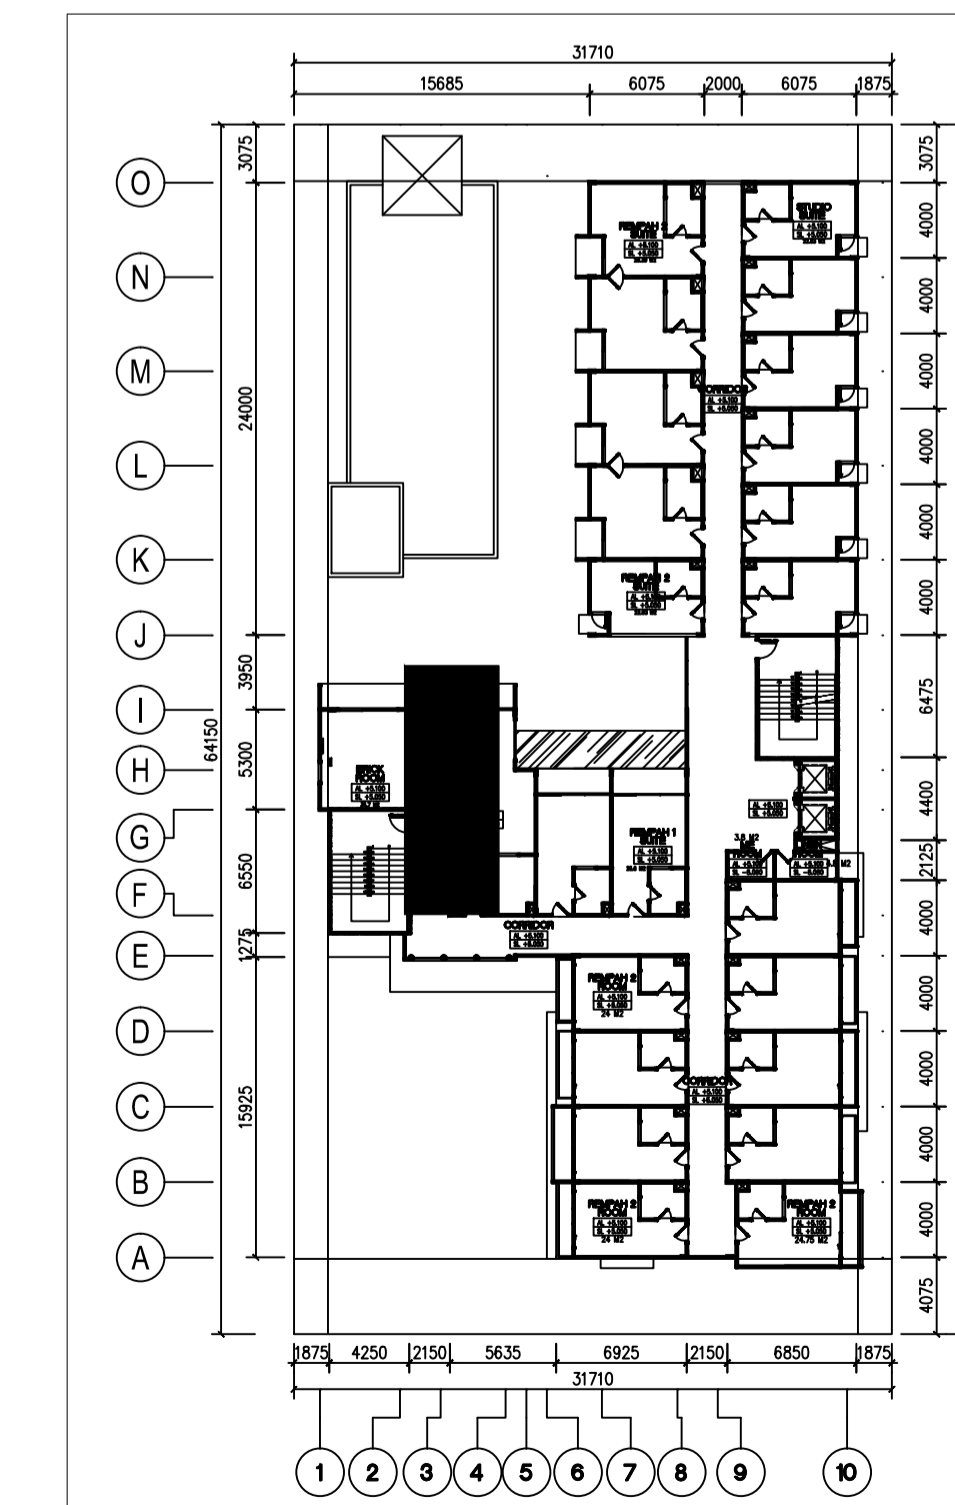

LEGEND

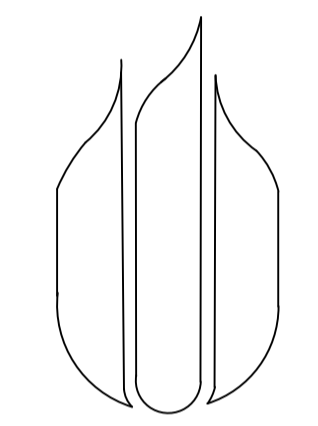

UNIVERSITAS
MERCU BUANA

NAMA PROYEK :

PERANCANGAN INTERIOR
GREENHOST BOUTIQUE HOTEL

JUDUL GAMBAR :

PARTICULAR LAYOUT LT. TIGA
(ERICK ROOM)

NAMA :

FARID FADILAH

NIM :

41714010020

DOSEN PEMBIMBING :

YOHANES NUGROHO UTOMO, Drs, M.Ds

SKALA : 1 : 30


JUMLAH GAMBAR : NOMOR GAMBAR :

5/21


ID-GBH.1.8

NILAI :


PARAF :

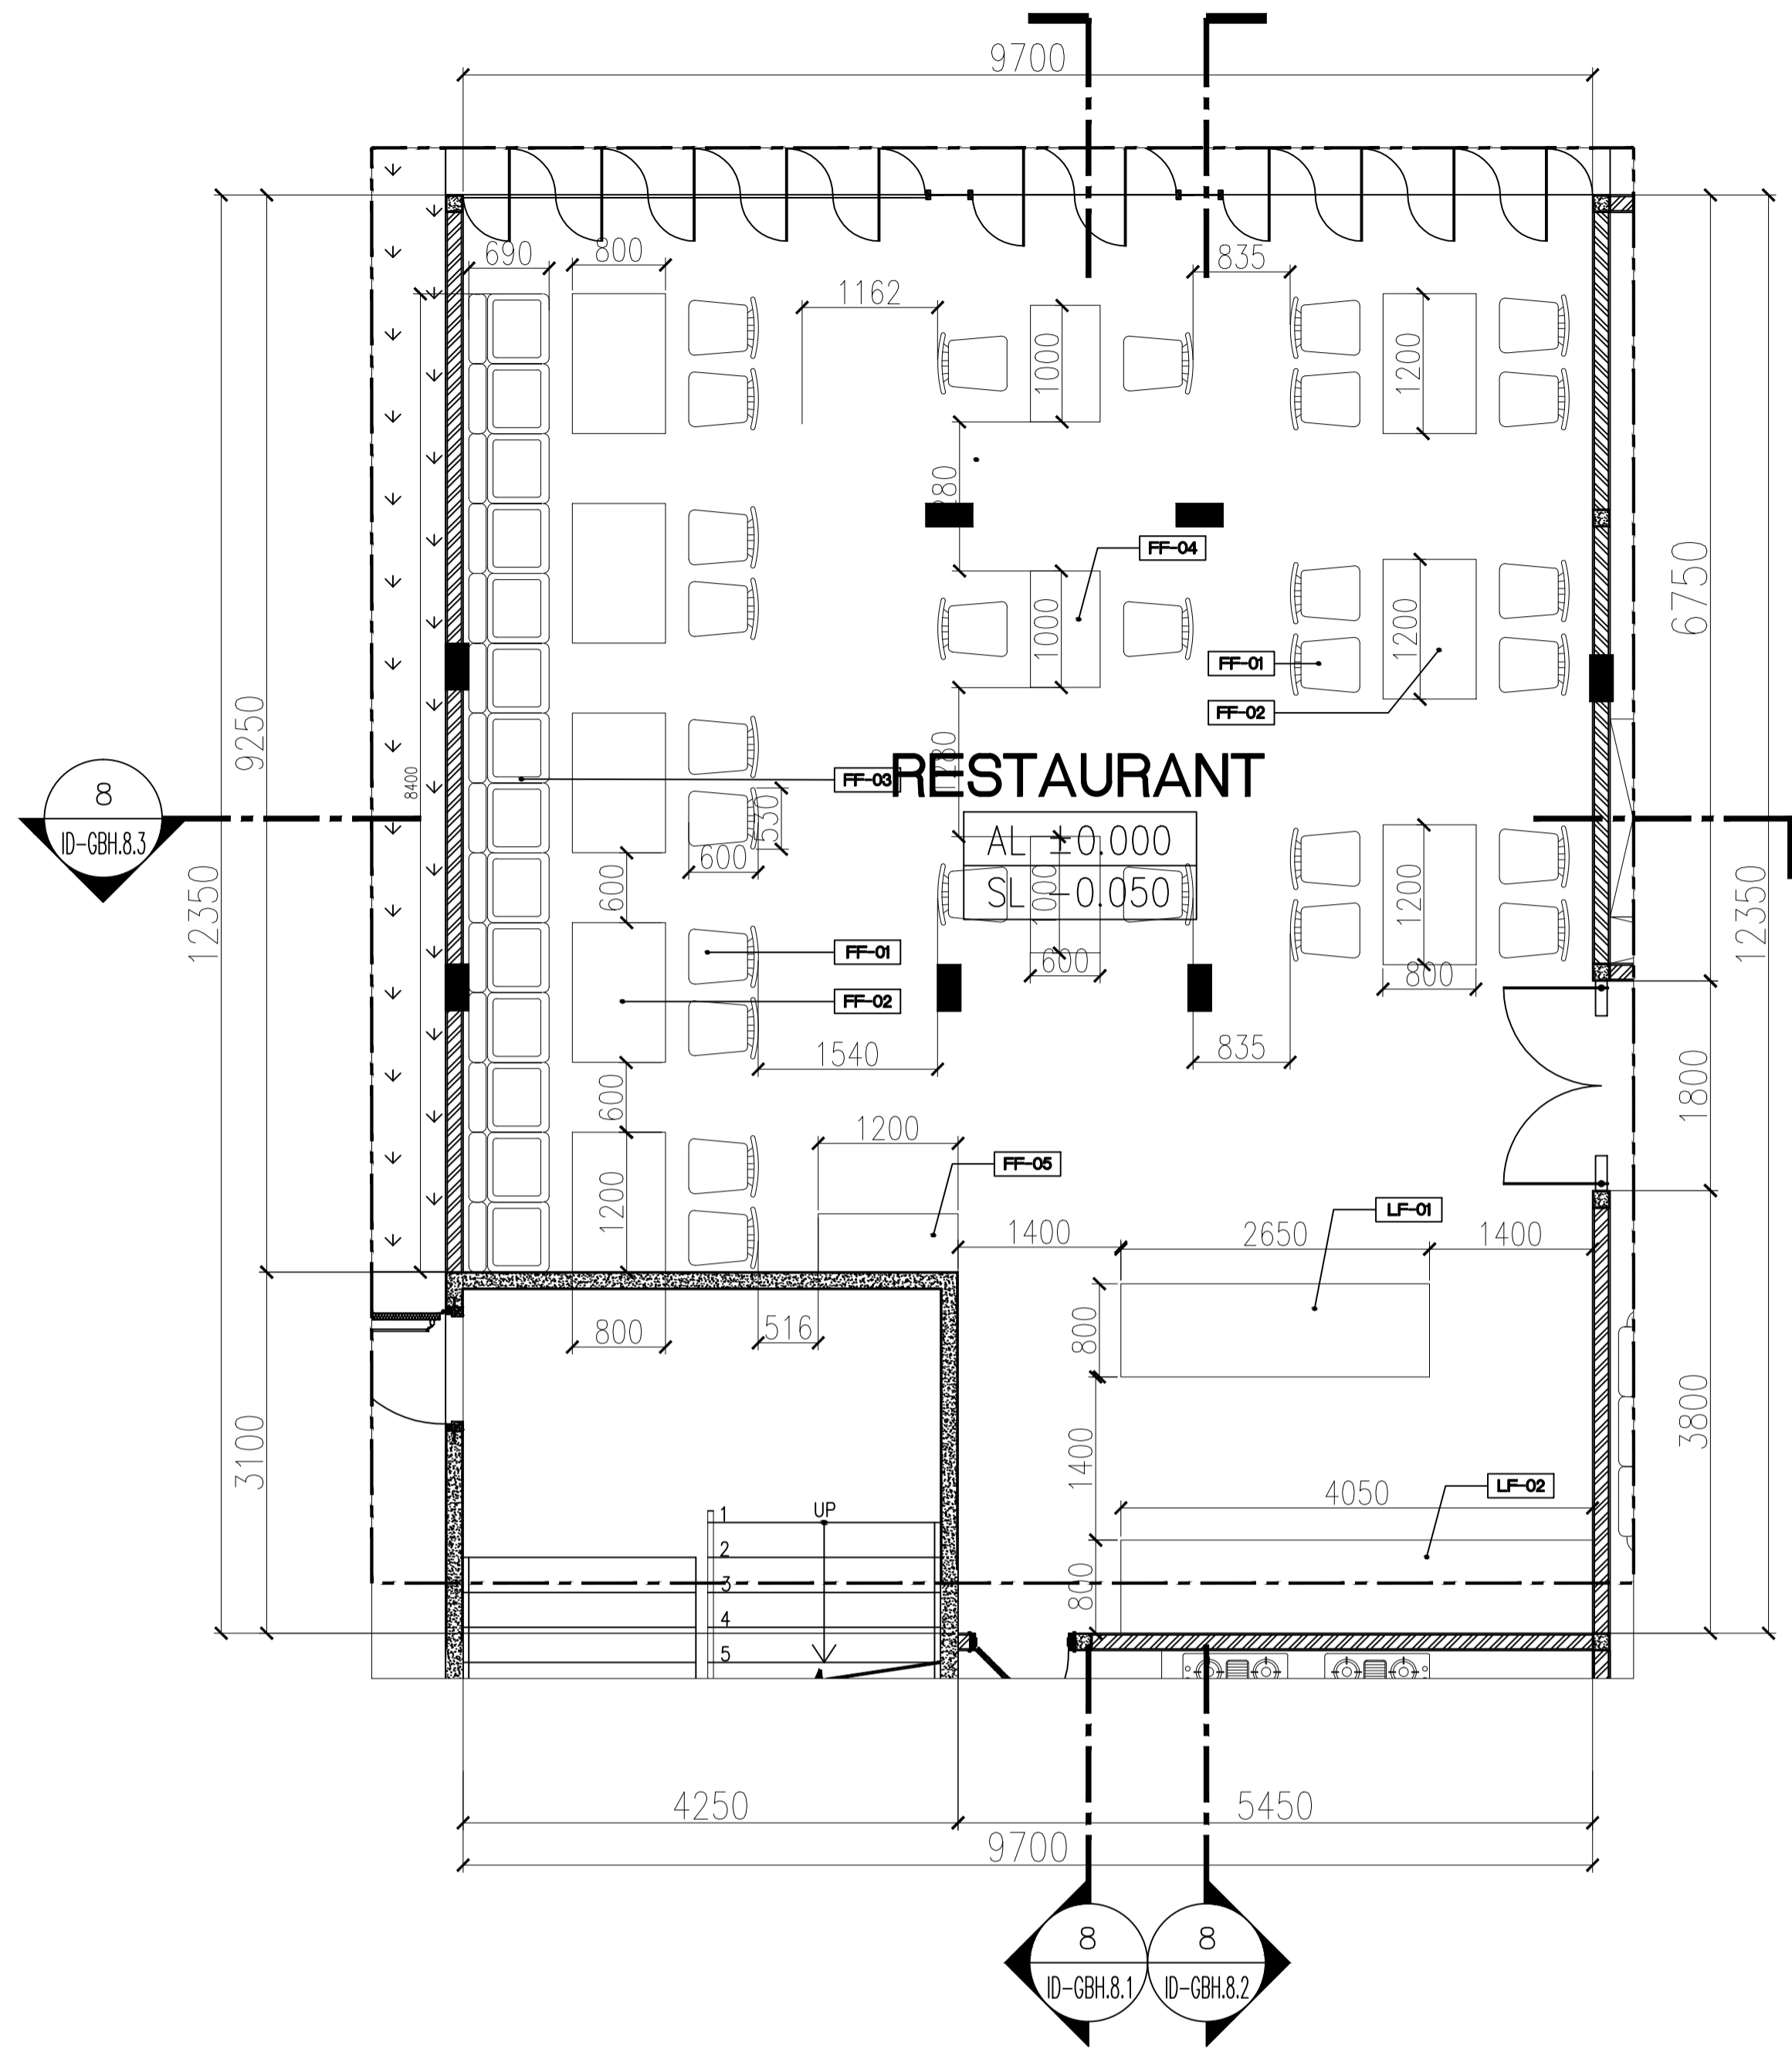

2
ID-GBH.2.0
GORUND FLOOR
RESTAURANT LAYOUT PLAN
SCALE 1:50

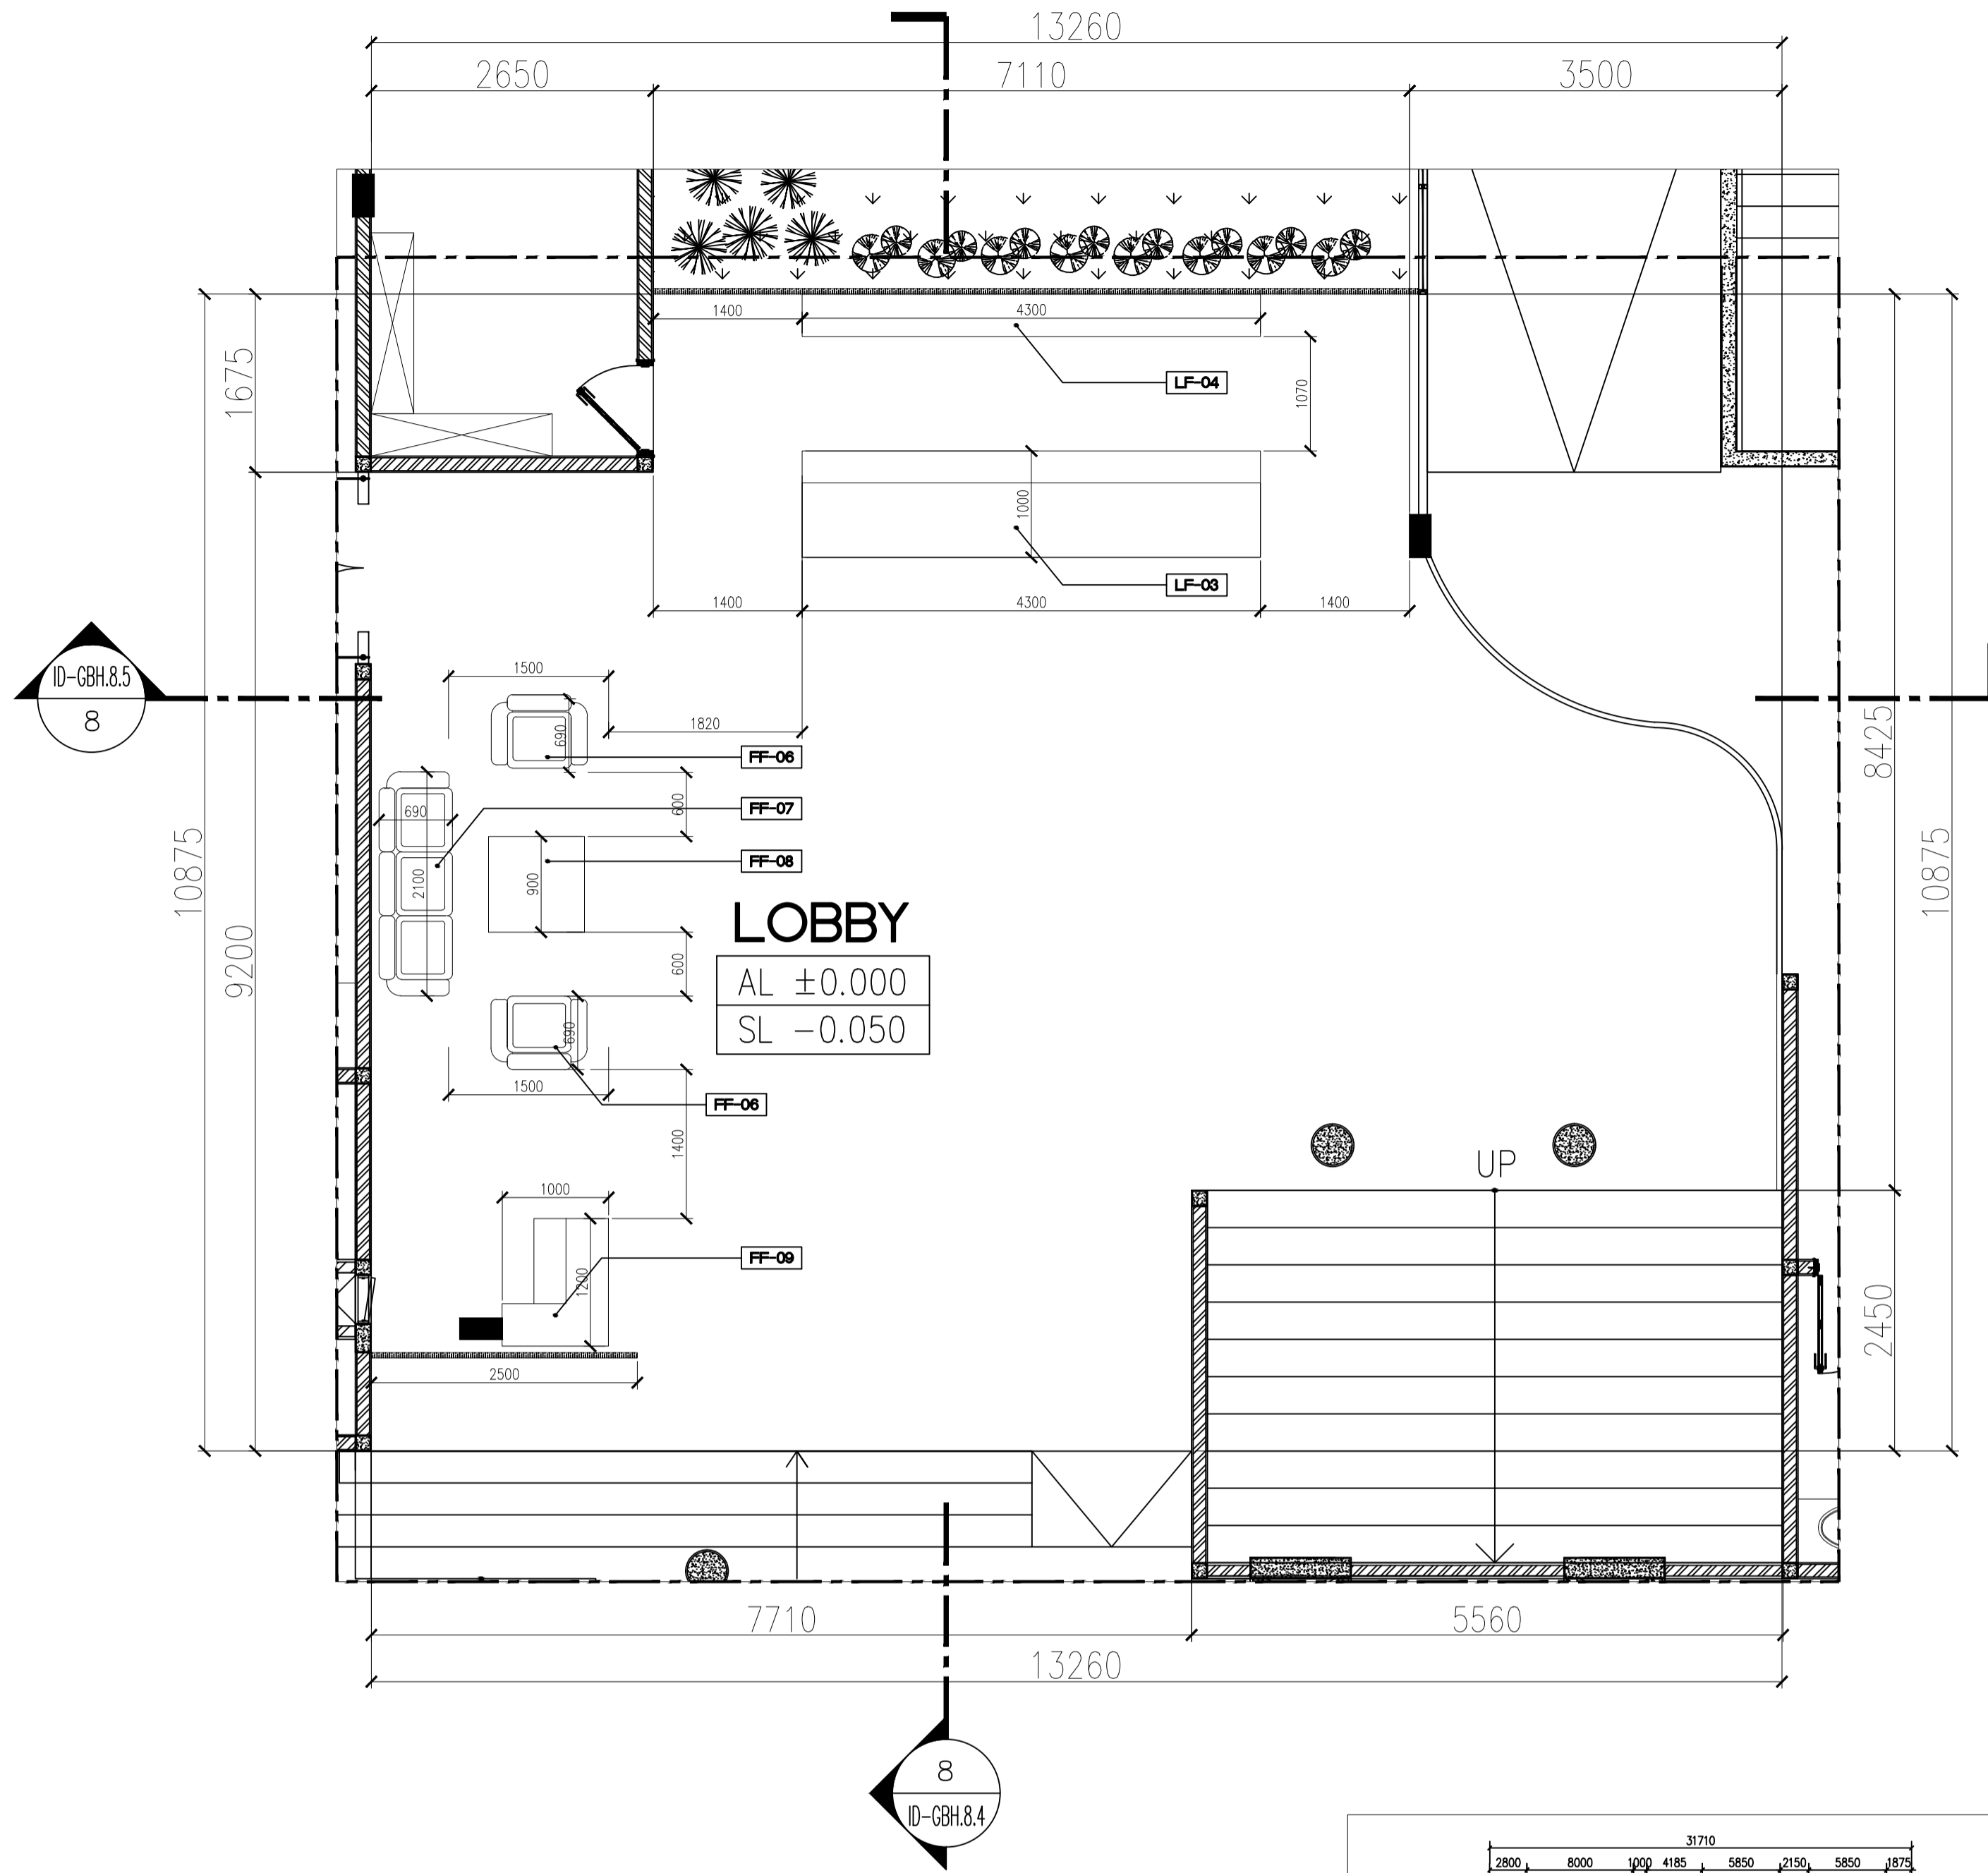


2
ID-GBH.2.1
GORUND FLOOR
RECEPTIONIST LAYOUT PLAN
SCALE 1:50

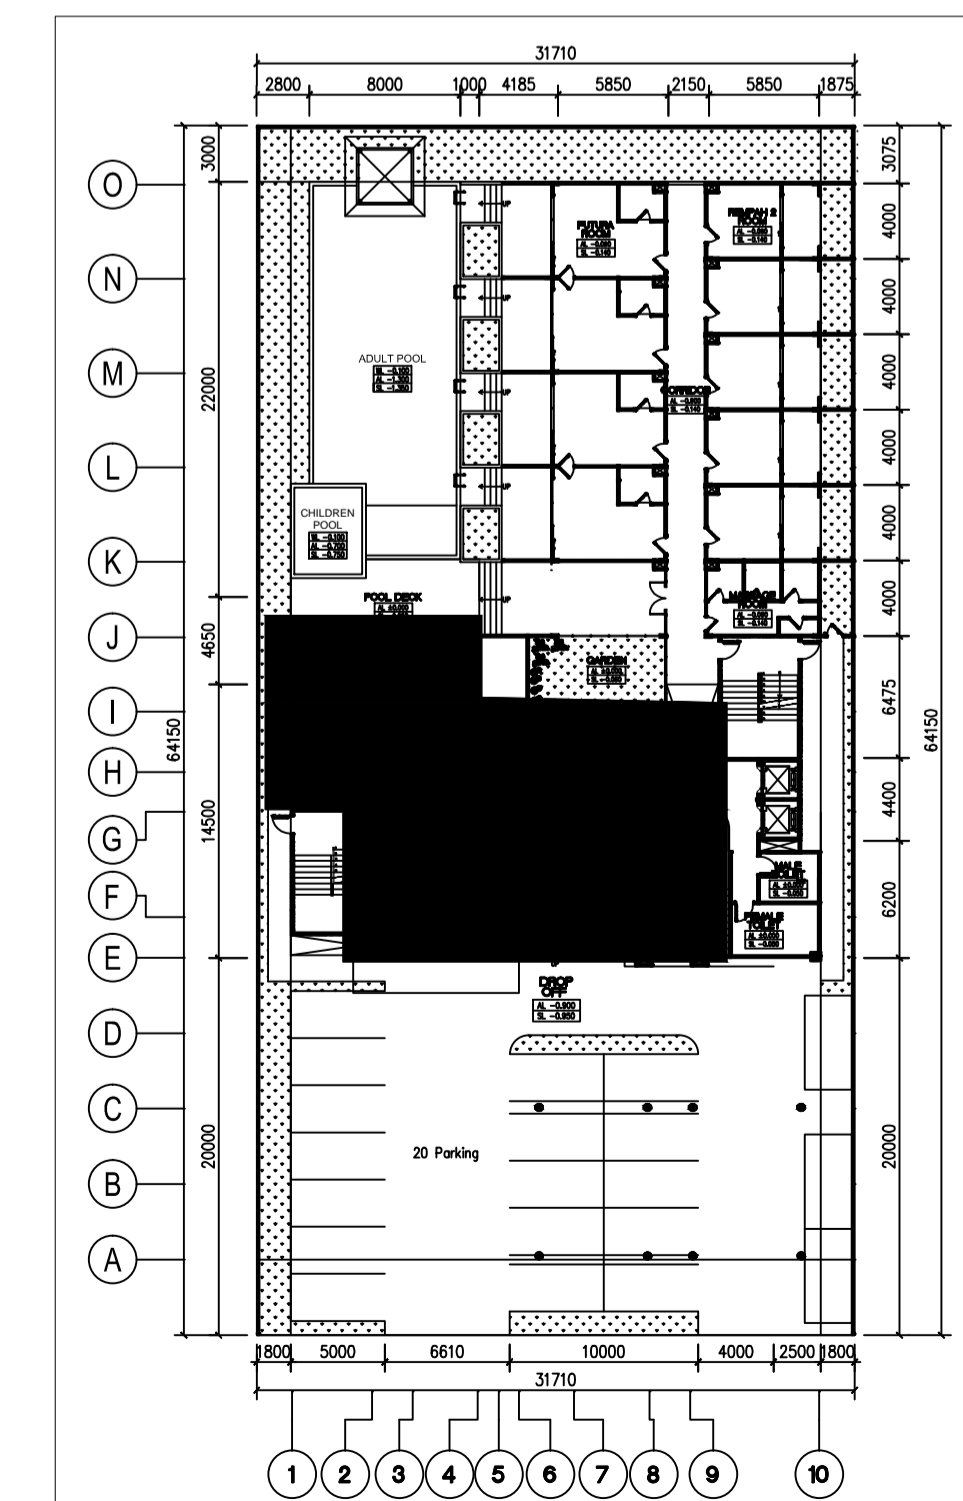

LEGEND

- FF-01 : KURSI RESTAURANT
- FF-02 : MEJA MAKAN
- FF-03 : SOFA MAKAN
- FF-04 : MEJA MAKAN
- FF-05 : MEJA SERVICE
- FF-06 : SOFA 1 SITTER ROTAN
- FF-07 : SOFA CUSTOM 3 SITTER
- FF-08 : COFFEE TABLE
- FF-09 : MEJA SECURITY

- LF-01 : MEJA BUFFET
- LF-02 : MEJA BUFFET 2
- LF-03 : MEJA RESEPSIONIS
- LF-04 : WALL DISPLAY KAYU PALET

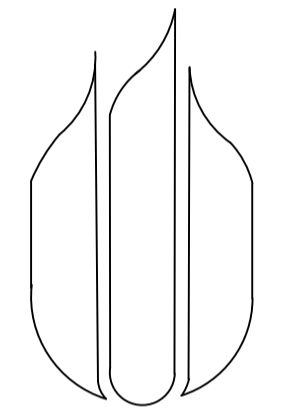

UNIVERSITAS
MERCU BUANA

NAMA PROYEK :

PERANCANGAN INTERIOR
GREENHOST BOUTIQUE HOTEL

JUDUL GAMBAR :

FURNITURE PLAN LT. GROUND
(RESTAURANT & RECEPTIONIST)

NAMA :

FARID FADILAH

NIM :

41714010020

DOSEN PEMBIMBING :

YOHANES NUGROHO UTOMO, Drs, M.Ds

SKALA : 1 : 50


JUMLAH GAMBAR : NOMOR GAMBAR :

6/21

ID-GBH.2.0
ID-GBH.2.1

NILAI :


PARAF :

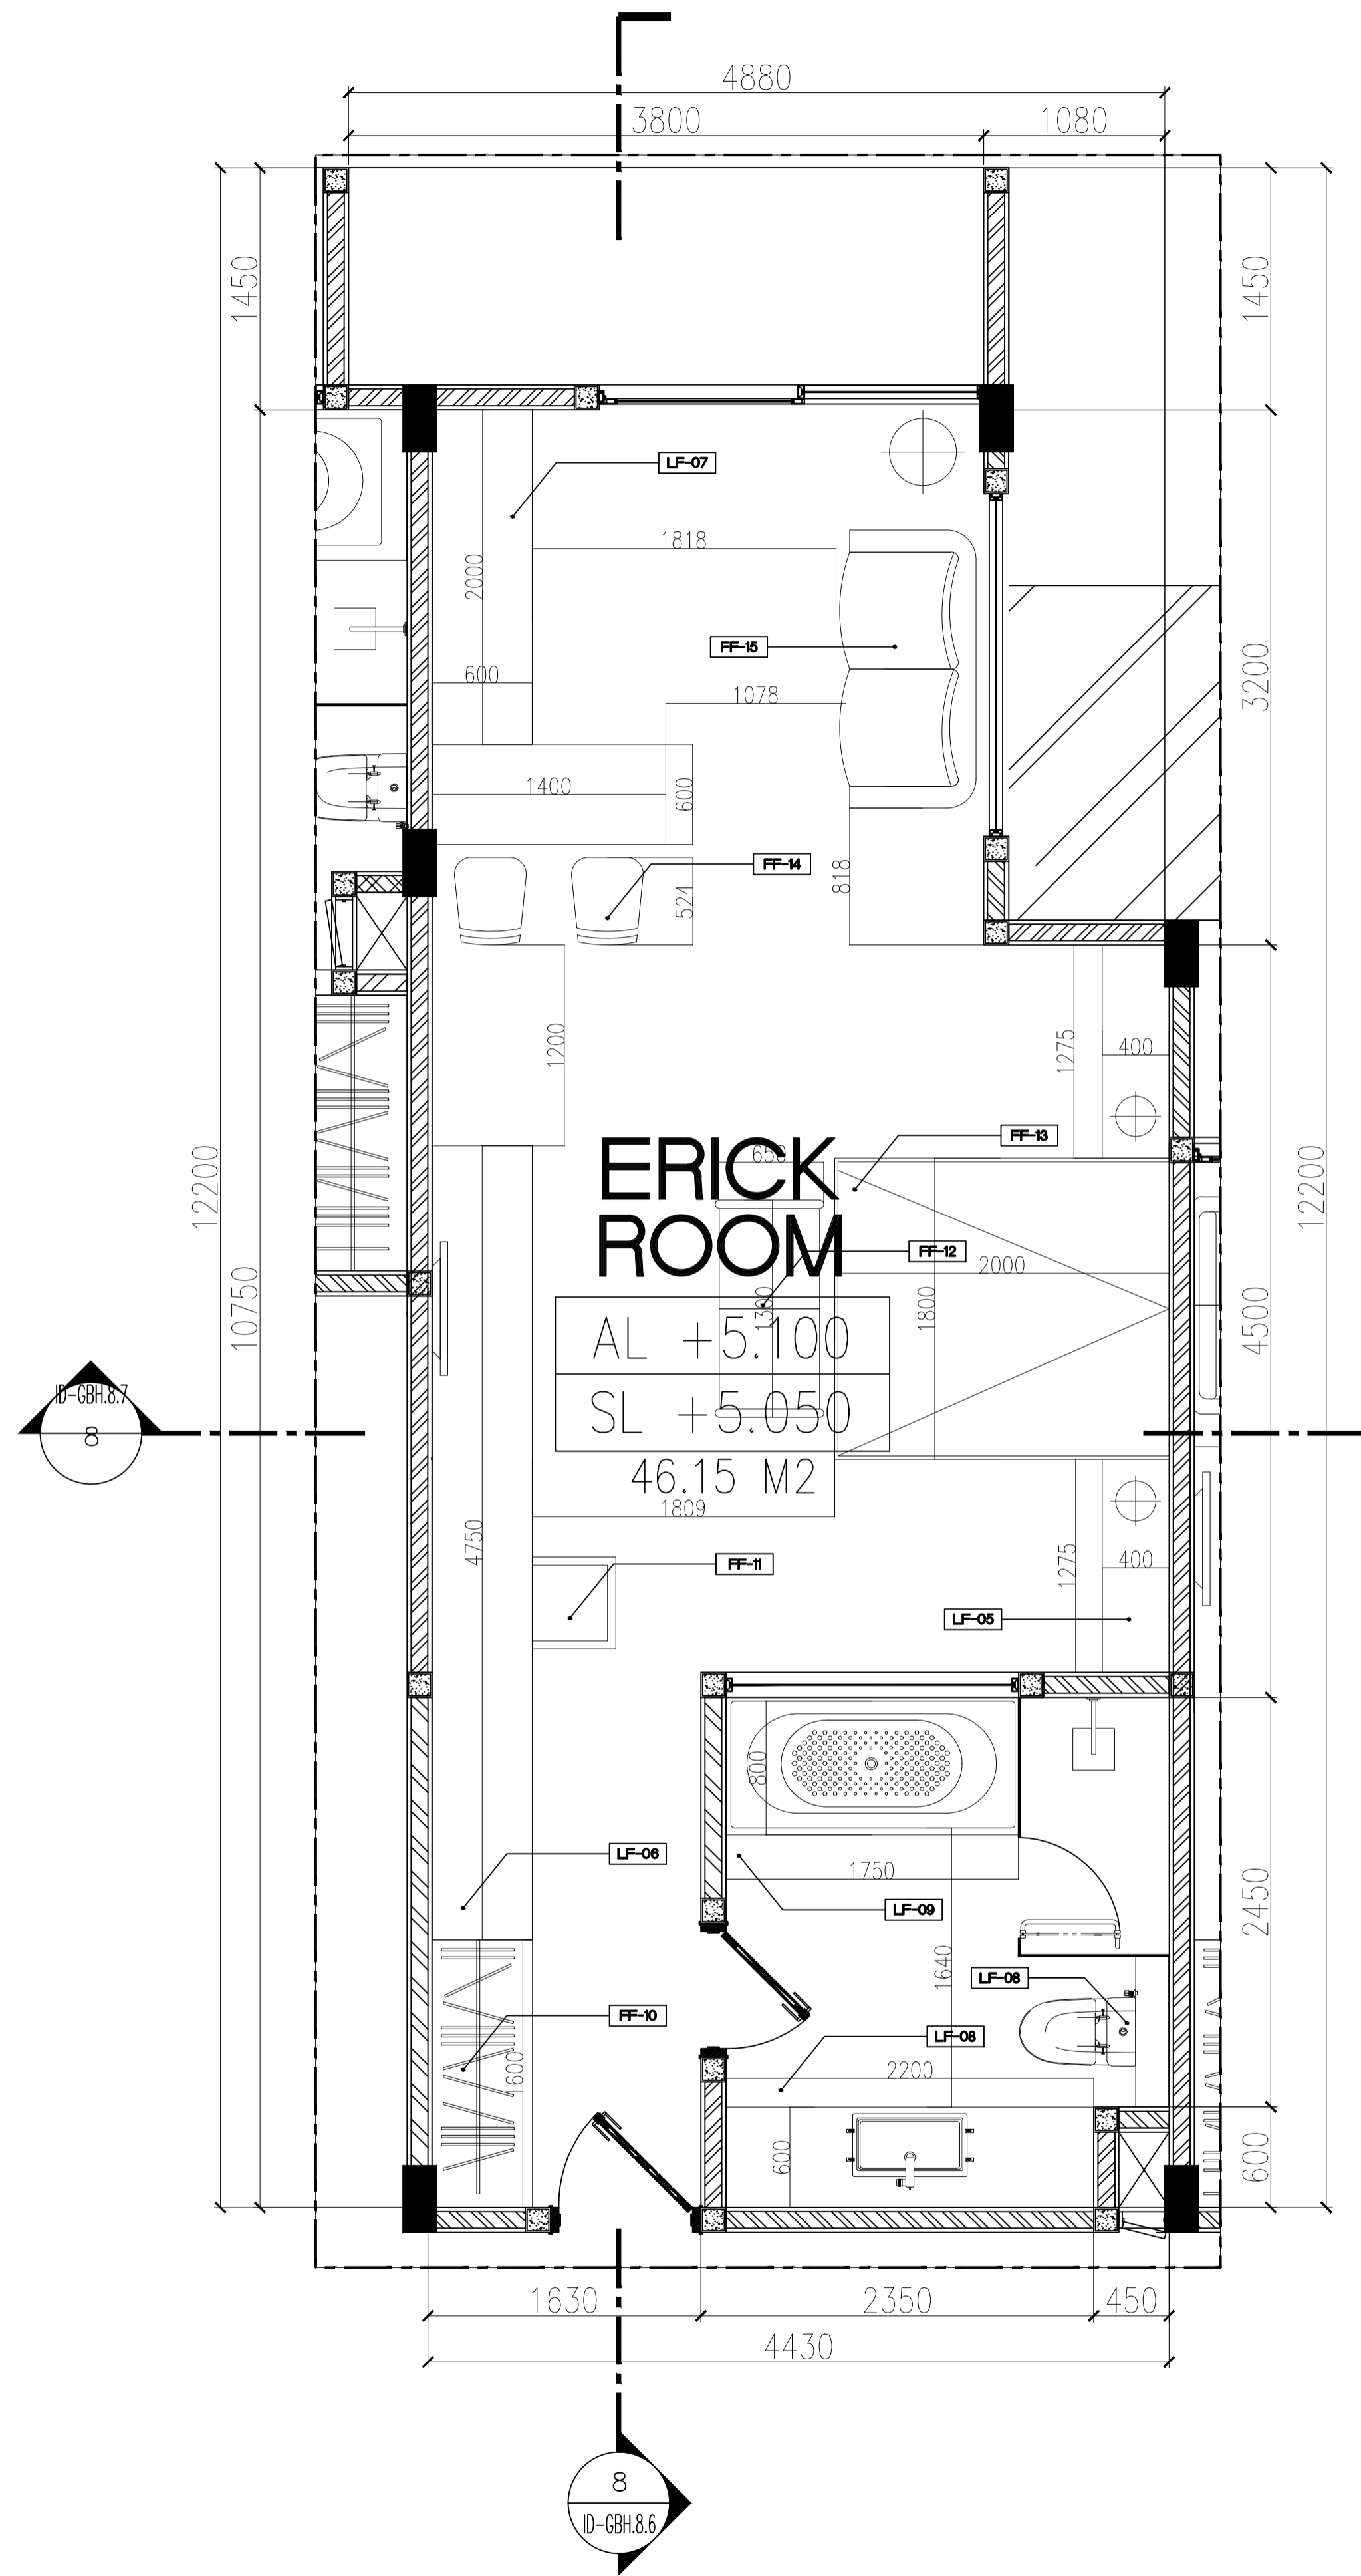

ERICK ROOM

AL +5.100
SL +5.050
46.15 M2
1809


2
ID-GBH.2.1
THIRD FLOOR
ERICK ROOM LAYOUT PLAN
SCALE 1:30

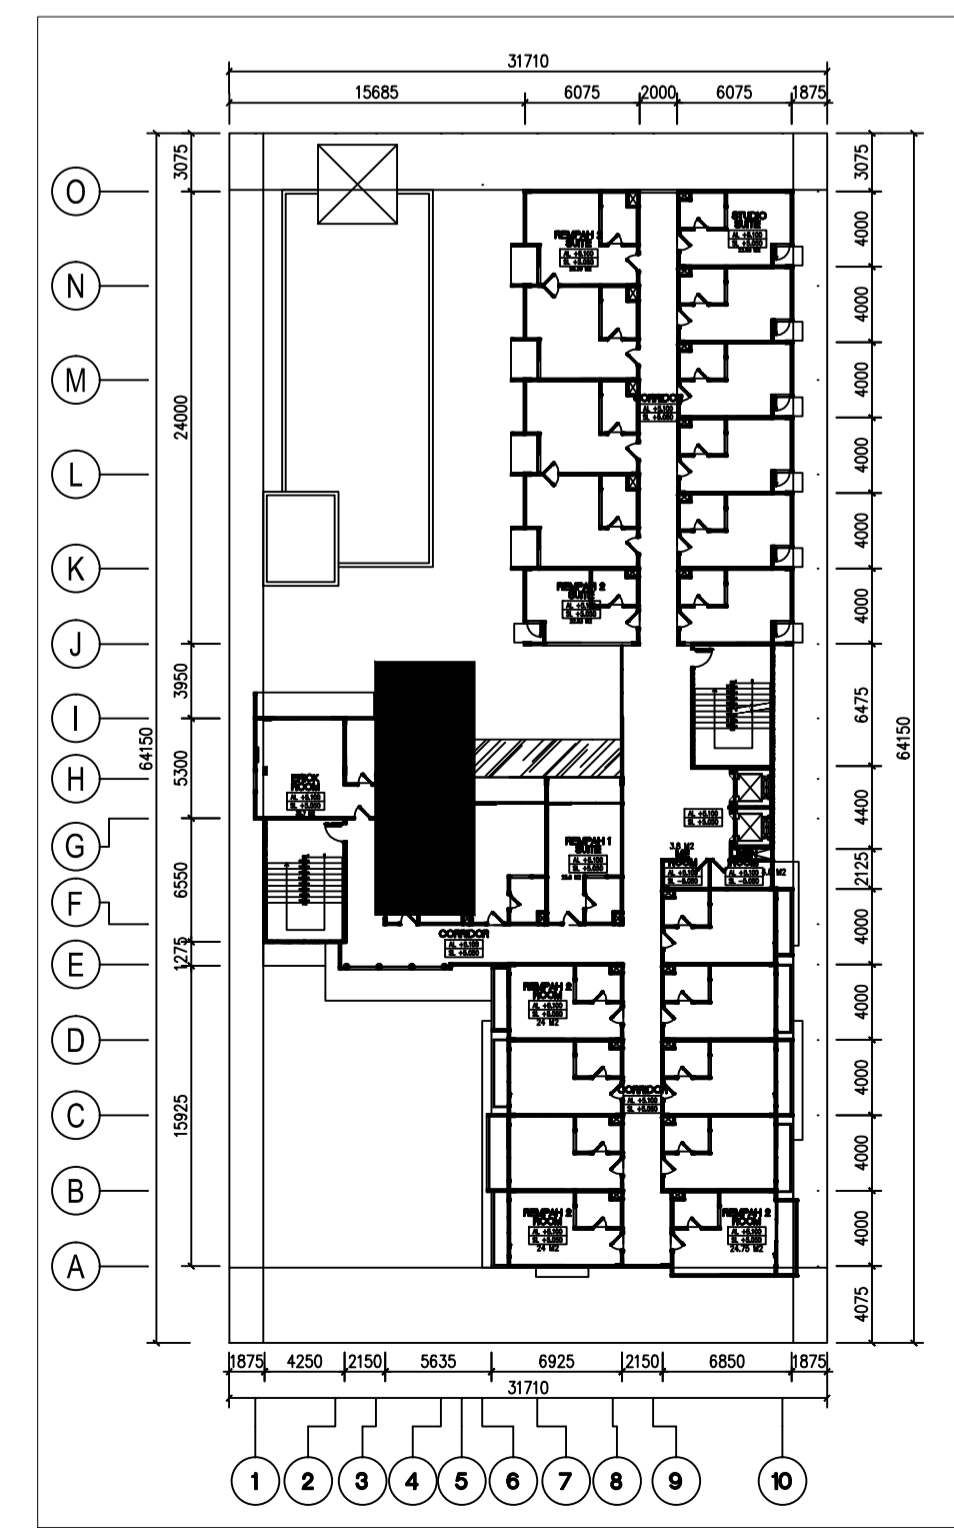

LEGEND

- FF-10 : WARDROBE
- FF-11 : KURSI MAKEUP
- FF-12 : FOOTSTOOL
- FF-13 : RANJANG KASUR
- FF-14 : BAR STOOL
- FF-15 : SOFA 2 SITTER

- LF-05 : SIDE TABLE
- LF-06 : HANGING TABLE
- LF-07 : KITCHEN SET
- LF-08 : WASHTAFEL
- LF-09 : BATHUP
- LF-10 : TOILET

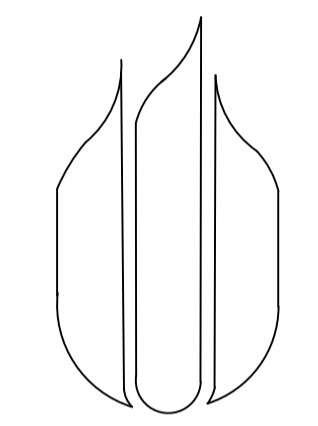

UNIVERSITAS
MERCU BUANA

NAMA PROYEK :

PERANCANGAN INTERIOR
GREENHOST BOUTIQUE HOTEL

JUDUL GAMBAR :

FURNITURE PLAN LT. TIGA
(ERICK ROOM)

NAMA :

FARID FADILAH

NIM :

41714010020

DOSEN PEMBIMBING :

YOHANES NUGROHO UTOMO, Drs, M.Ds

SKALA : 1 : 30


JUMLAH GAMBAR : NOMOR GAMBAR :

7/21


ID-GBH.2.2

NILAI :


PARAF :

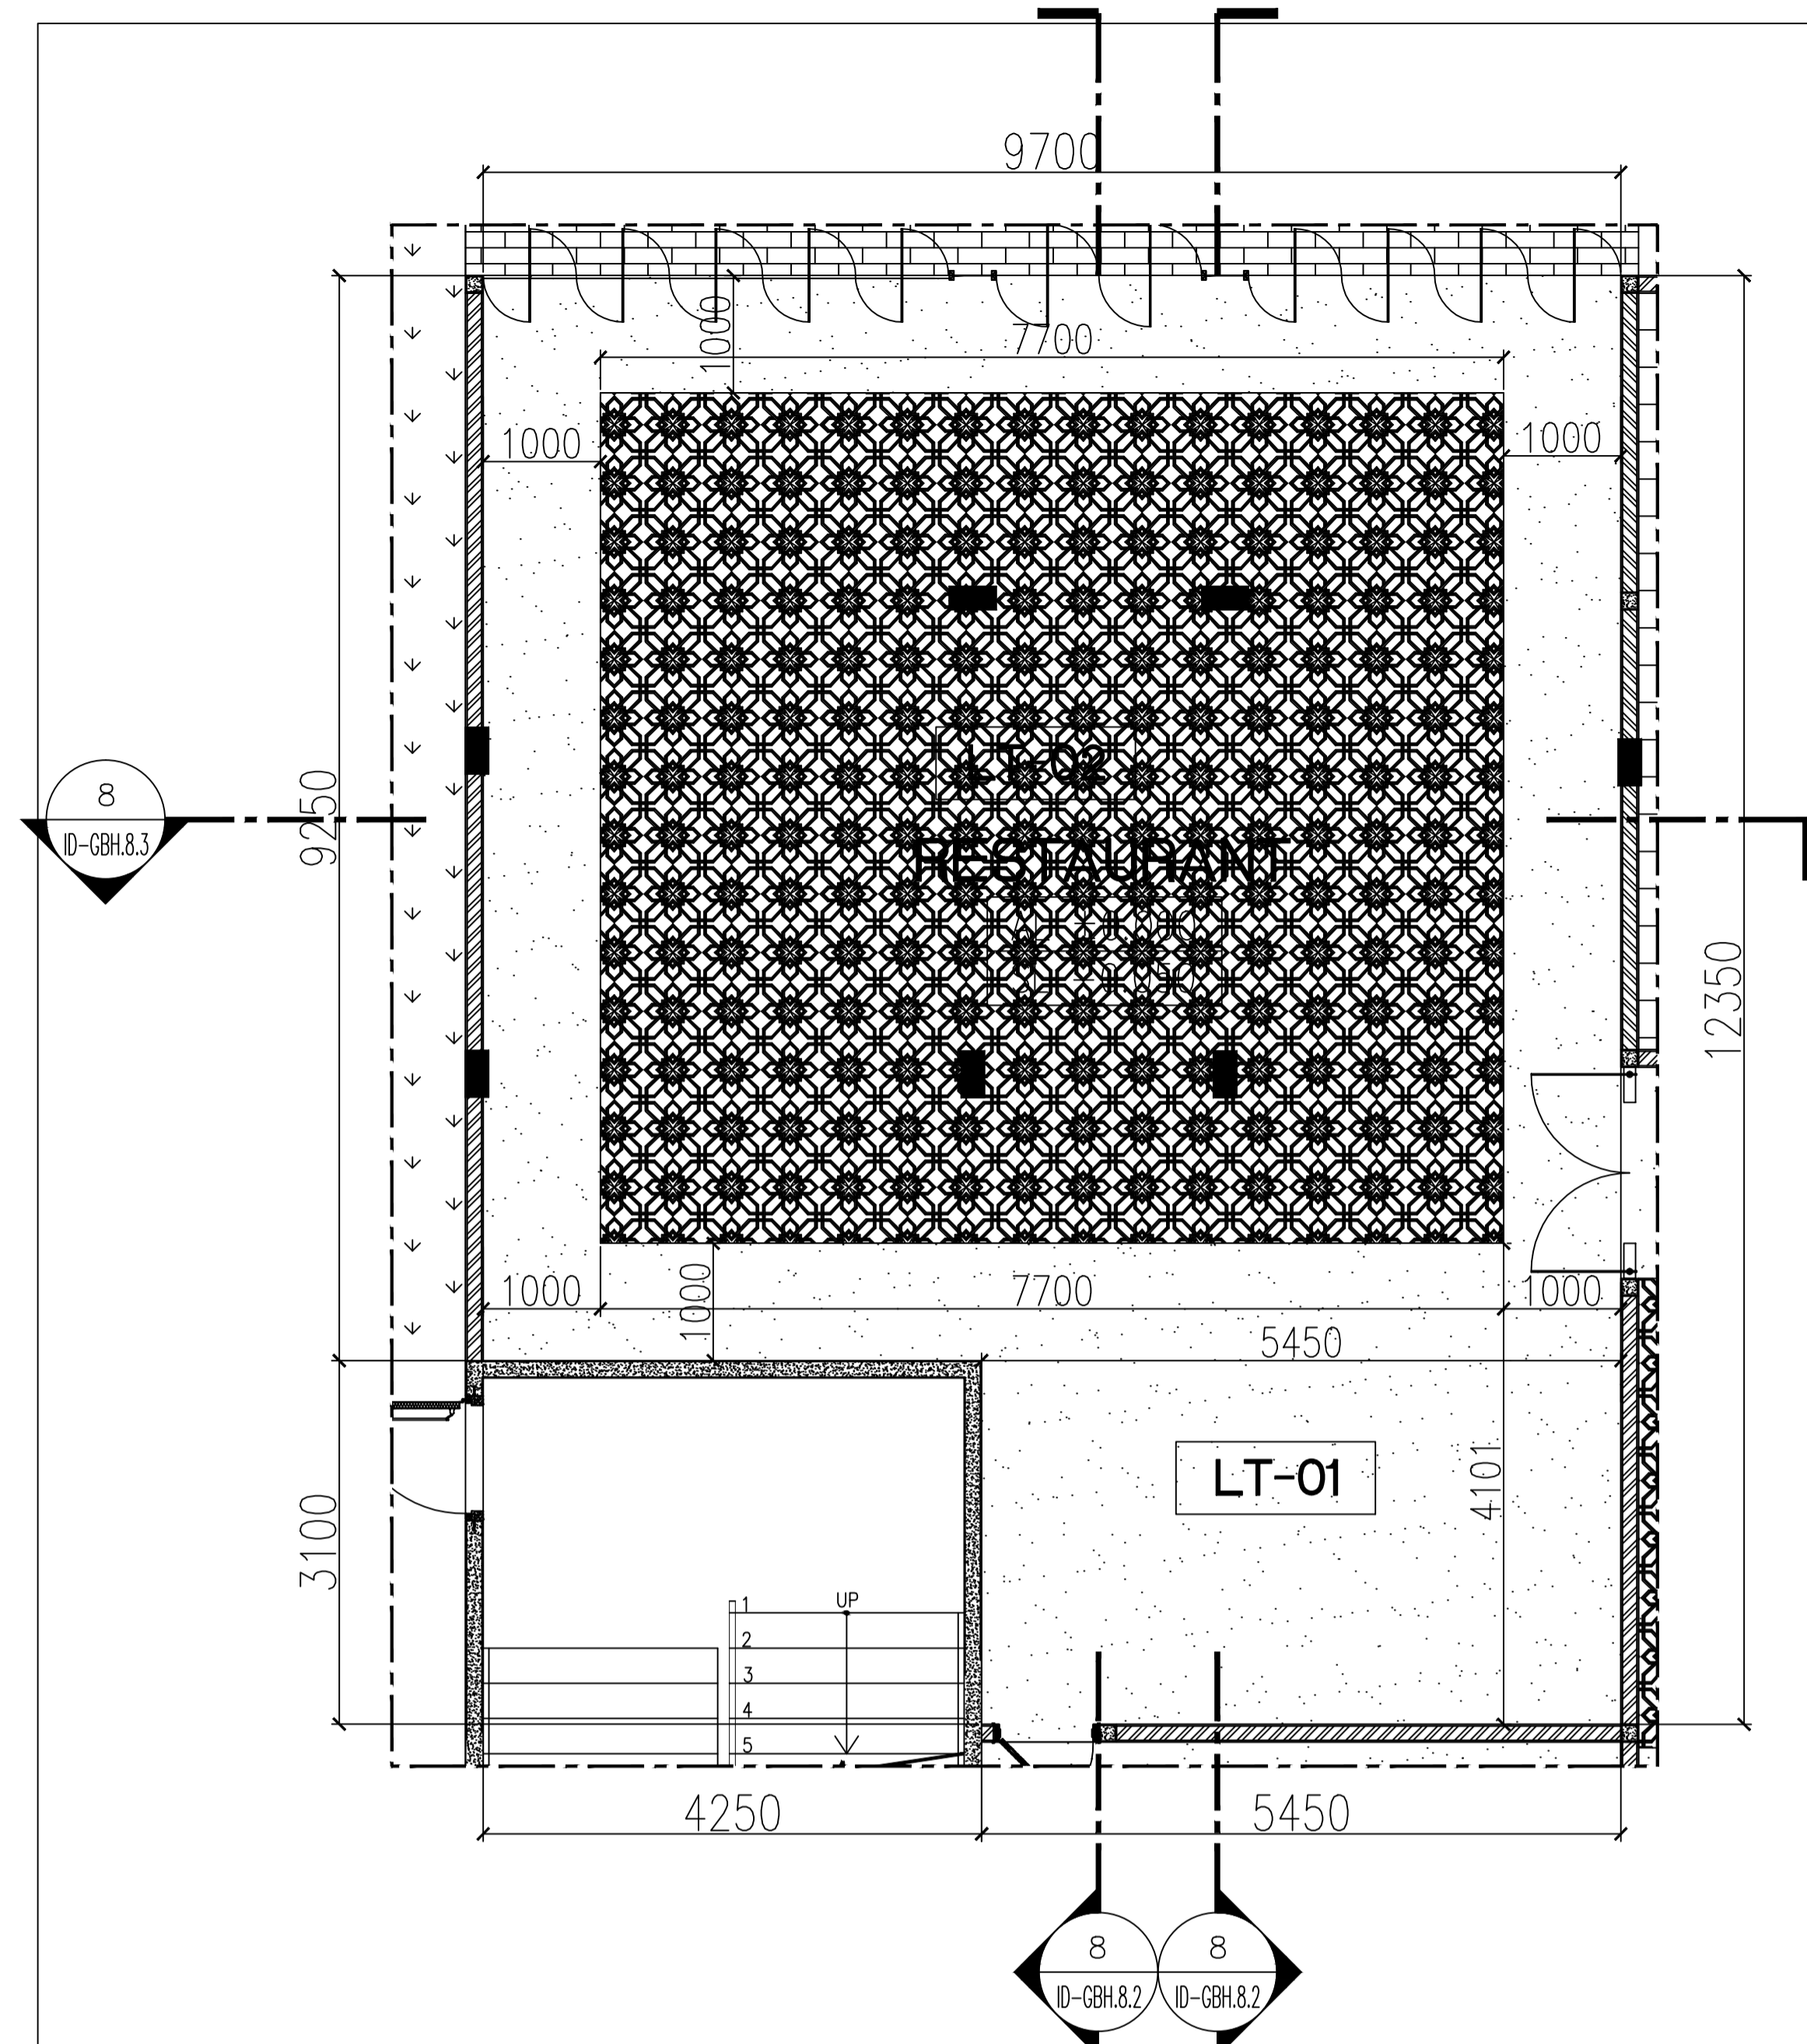


GROUND FLOOR
 FLOOR RESTAURANT PLAN
 SCALE 1: 50
 3 ID-GBH.3.1

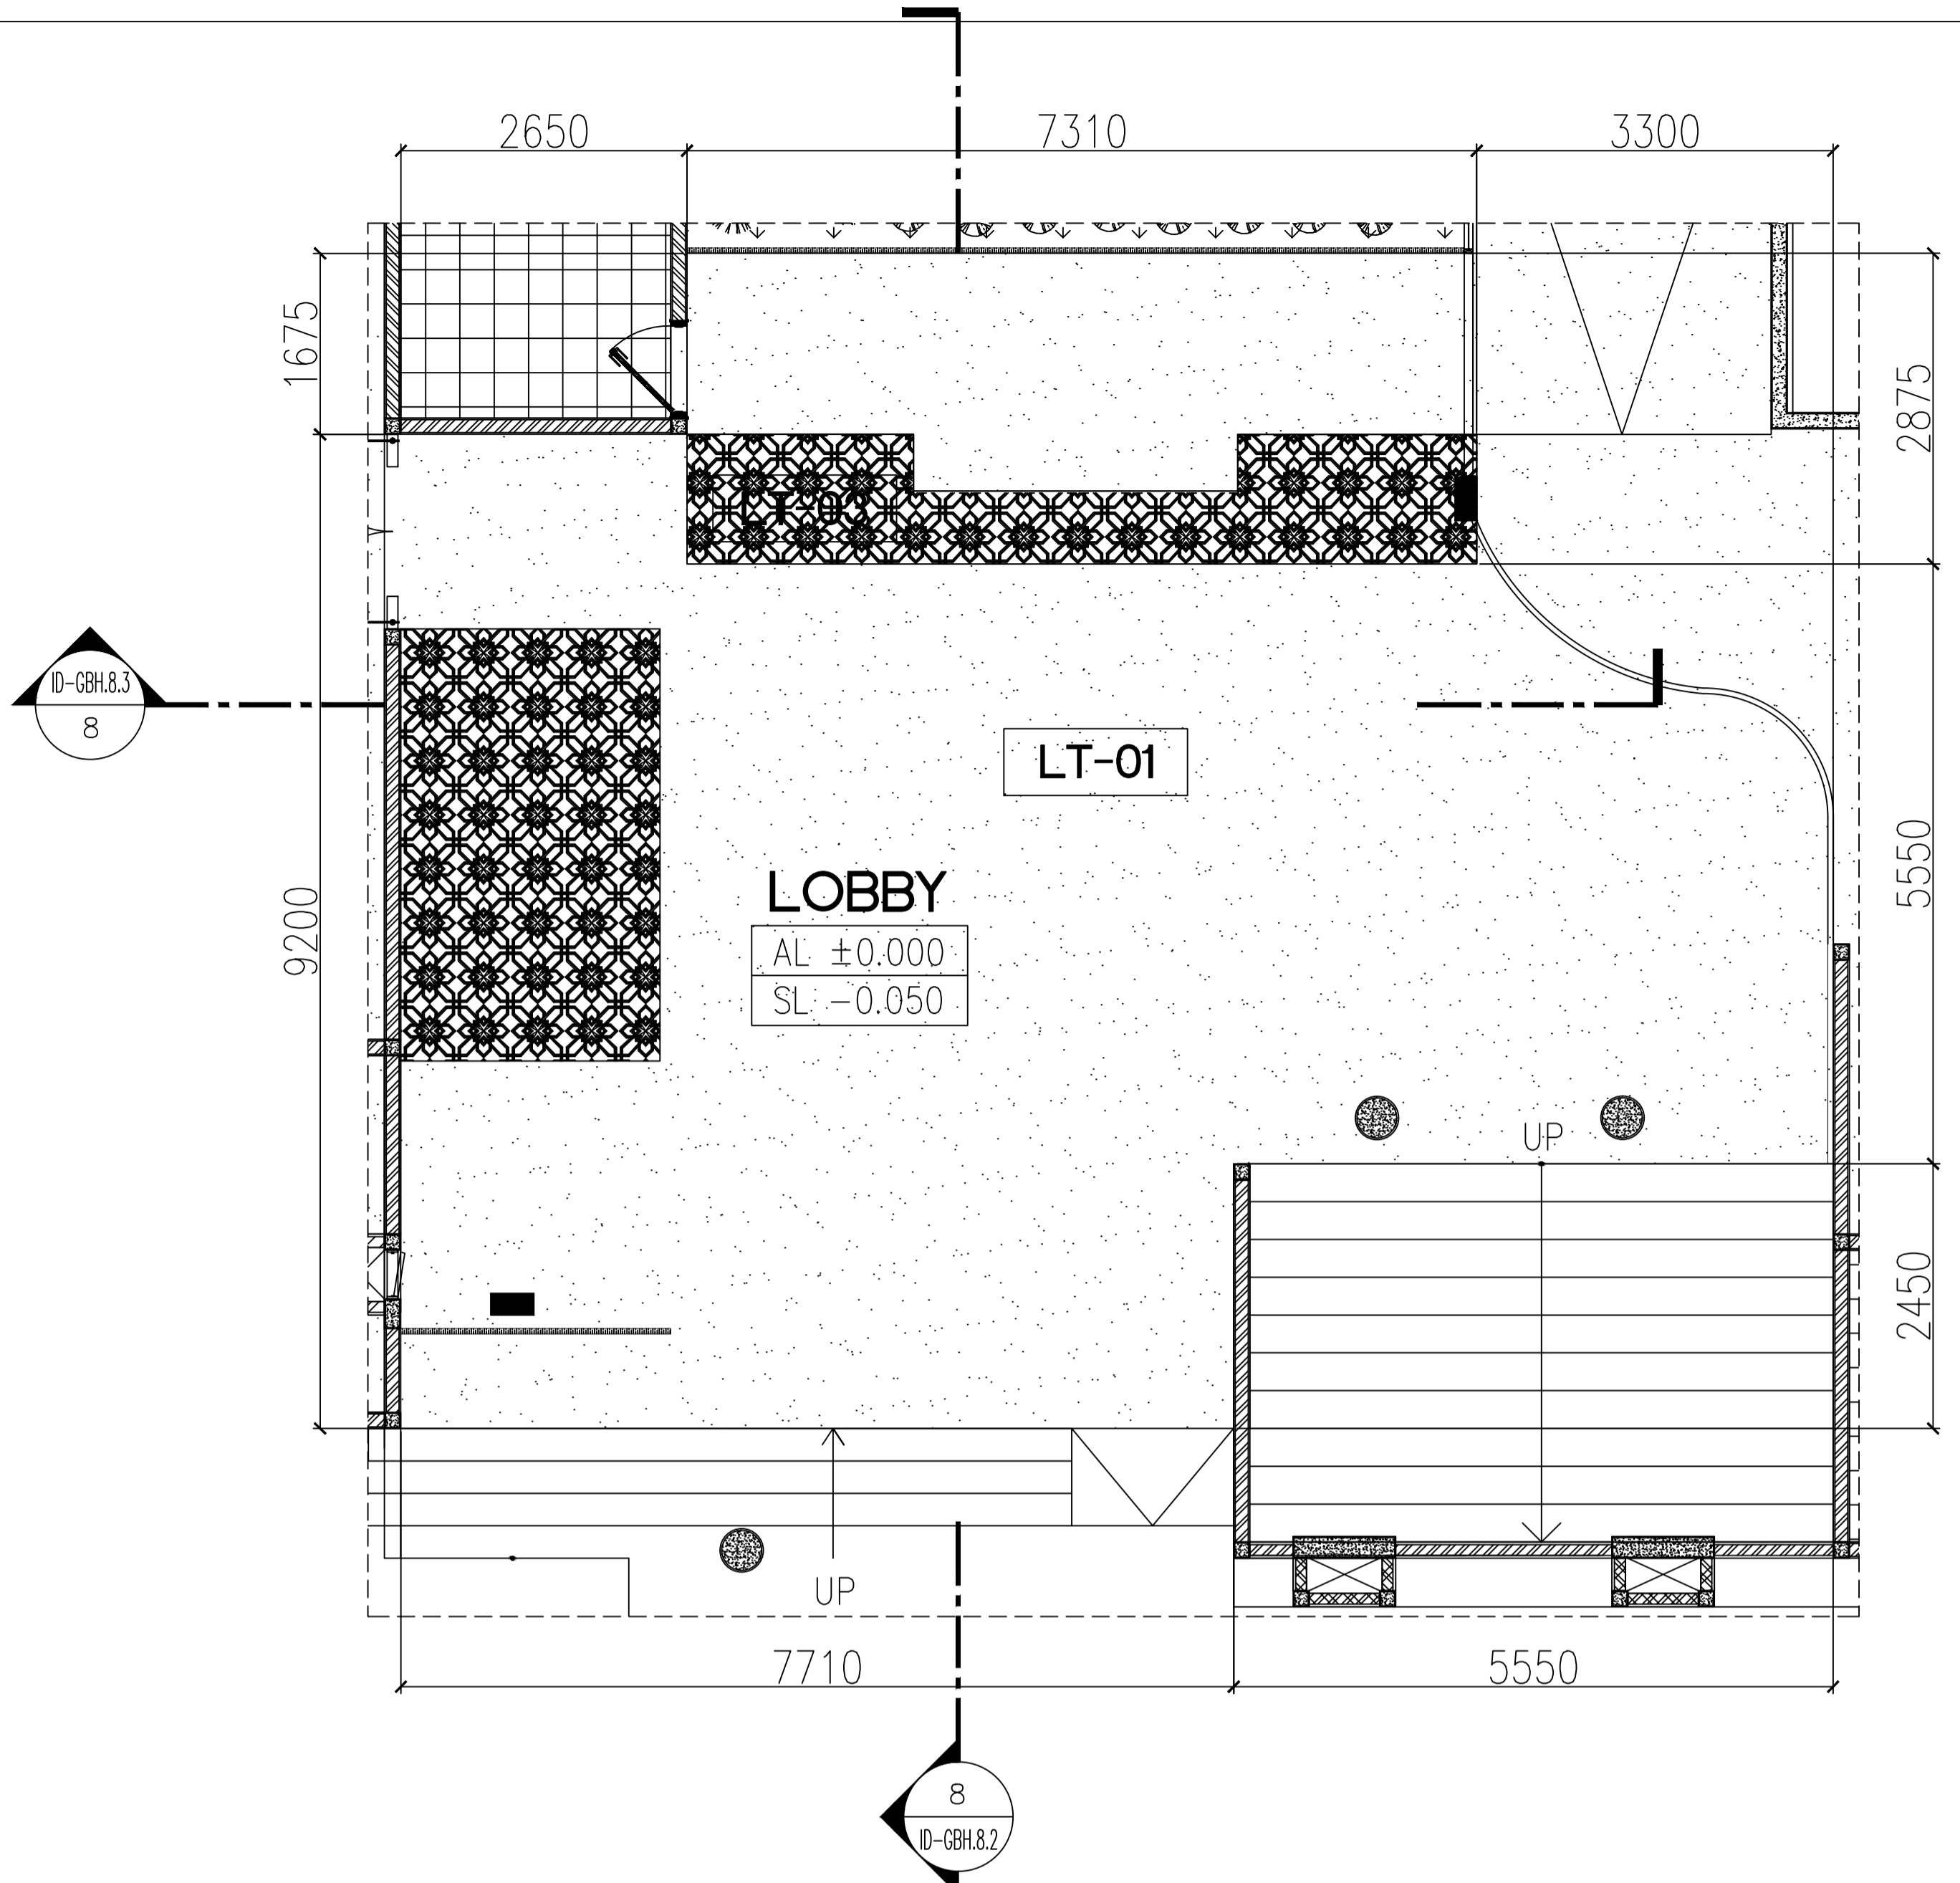


GROUND FLOOR
 FLOOR RESTAURANT PLAN
 SCALE 1: 50
 3 ID-GBH.3.1

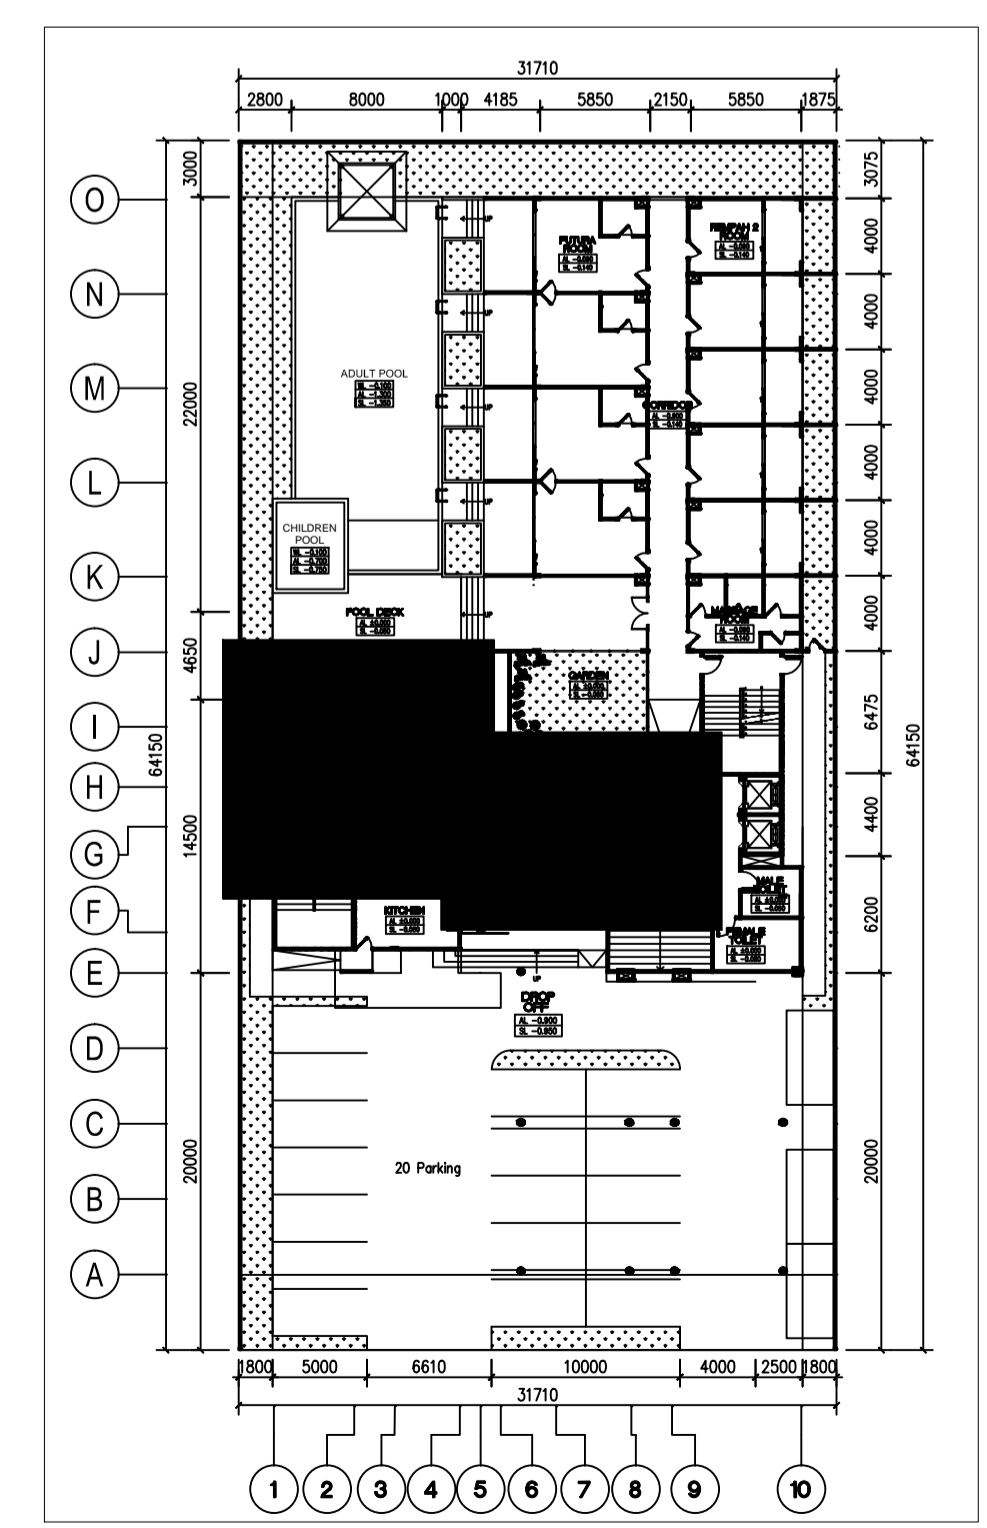

LEGEND	
LT-01 : LANTAI PLUR FIN. EPOXY CLEAR LT-02 : LANTAI KUNCI TEGEL MOTIF 1 LT-03 : LANTAI KUNCI TEGEL MOTIF 2 LT-04 : LANTAI HOMOGEN TILE LT-05 : LANTAI KUNCI TEGEL MOTIF 3	
 UNIVERSITAS MERCU BUANA	
NAMA PROYEK :	
PERANCANGAN INTERIOR GREENHOST BOUTIQUE HOTEL	
JUDUL GAMBAR :	
FLOOR LAYOUT PLAN LT. GROUND (RESTAURANT & RECEPTIONIST)	
NAMA :	
FARID FADILAH	
NIM :	
41714010020	
DOSEN PEMBIMBING :	
YOHANES NUGROHO UTOMO, Drs, M.Ds	
SKALA :	1 : 50
JUMLAH GAMBAR :	NOMOR GAMBAR :
8/21	ID-GBH.3.0 ID-GBH.3.1
NILAI :	PARAF :

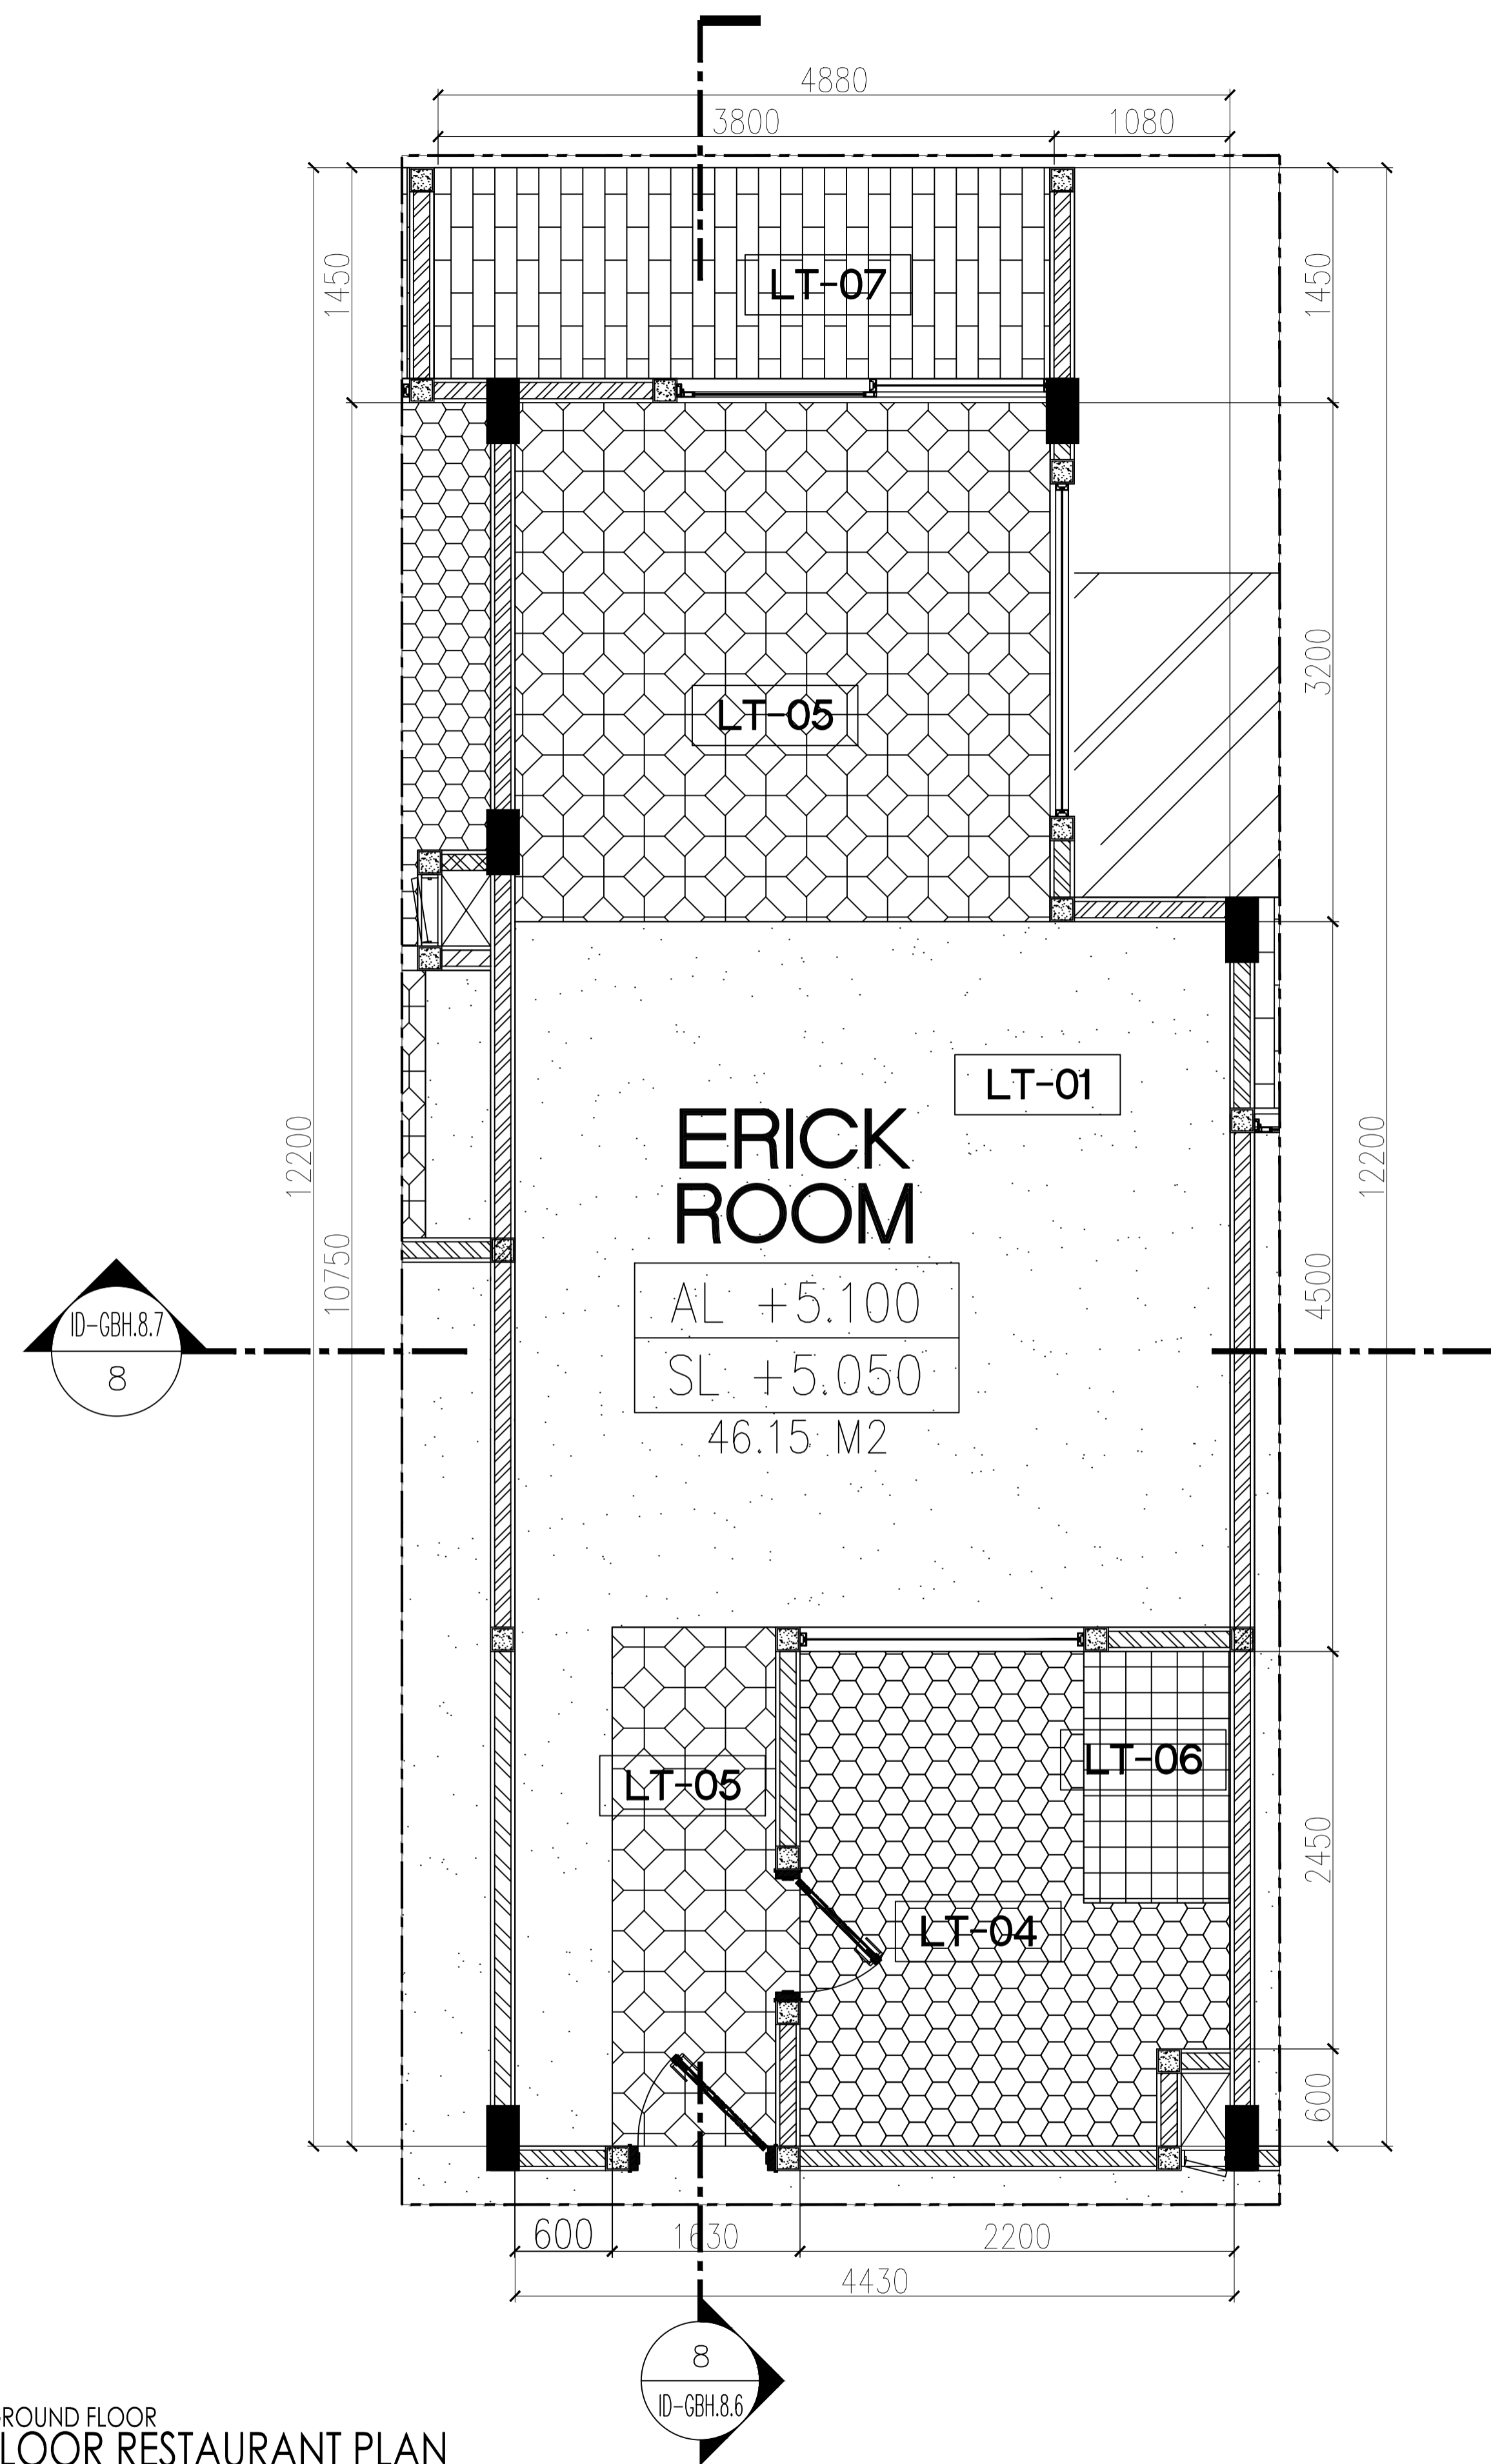


GROUND FLOOR
FLOOR RESTAURANT PLAN
SCALE 1:30
3
ID-GBH.3.2

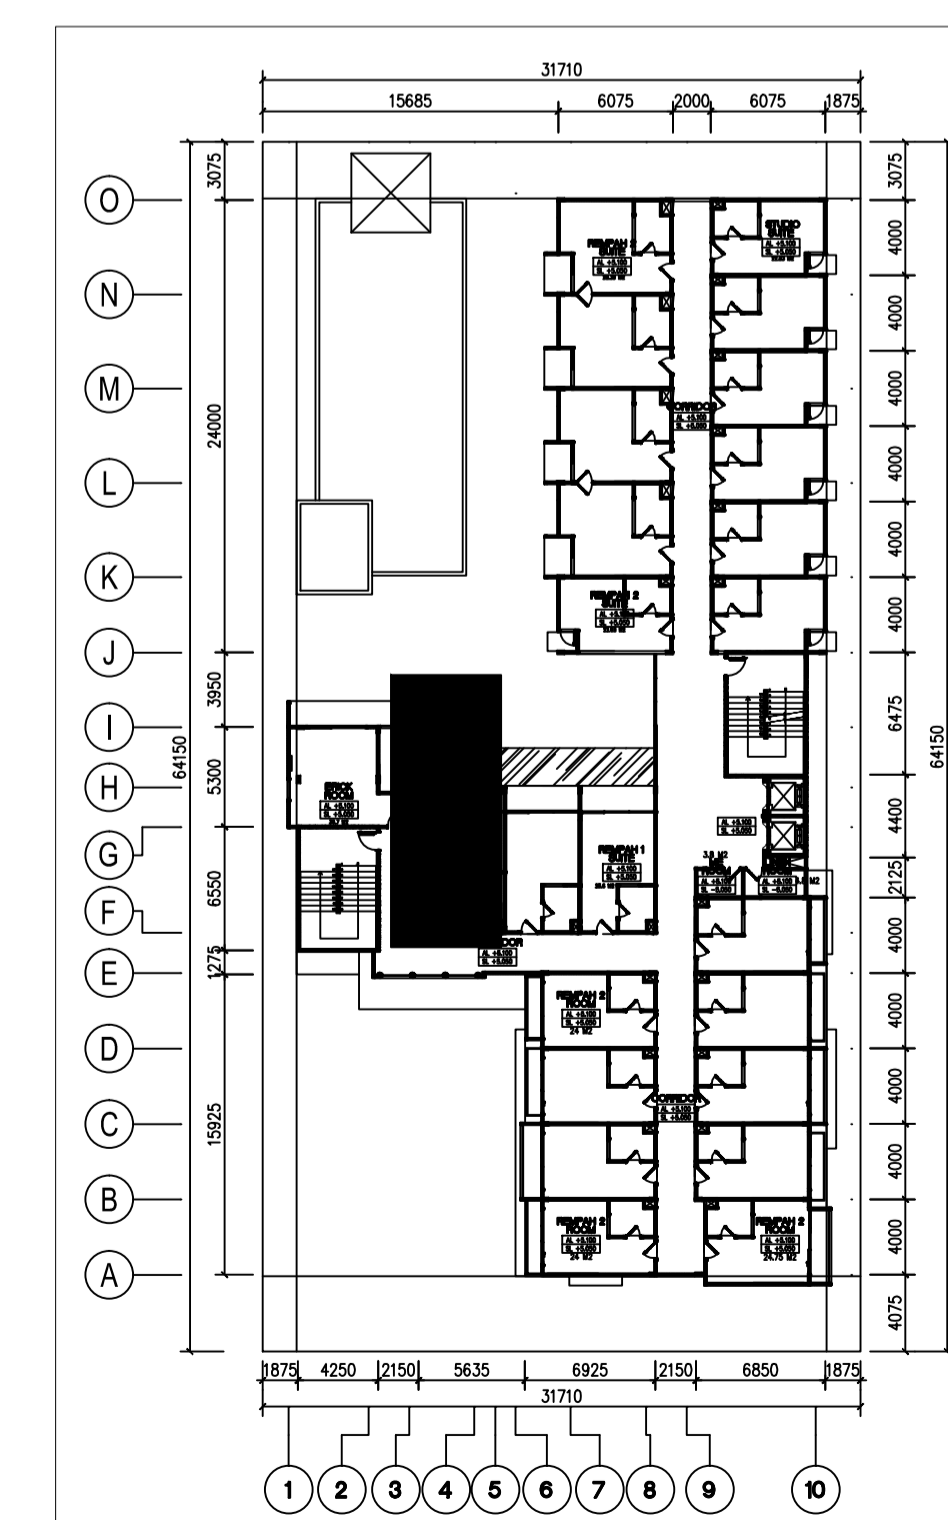

LEGEND

- LT-01 : LANTAI PLUR FIN. EPOXY CLEAR
- LT-02 : LANTAI KUNCI TEGEL MOTIF 1
- LT-03 : LANTAI KUNCI TEGEL MOTIF 2
- LT-04 : LANTAI HOMOGEN TILE
- LT-05 : LANTAI KUNCI TEGEL MOTIF 3
- LT-06 : LANTAI KERAMIK
- ;T-07 : LANTAI PARKET

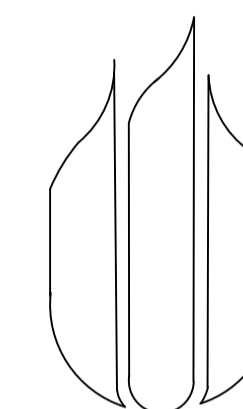

UNIVERSITAS
MERCU BUANA

NAMA PROYEK :

PERANCANGAN INTERIOR
GREENHOST BOUTIQUE HOTEL

JUDUL GAMBAR :

FLOOR LAYOUT PLAN LT. TIGA
(ERICK ROOM)

NAMA :

FARID FADILAH

NIM :

41714010020

DOSEN PEMBIMBING :

YOHANES NUGROHO UTOMO, Drs, M.Ds

SKALA : 1 : 30



JUMLAH GAMBAR : NOMOR GAMBAR :

9/21

ID-GBH.3.2


NILAI :

PARAF :

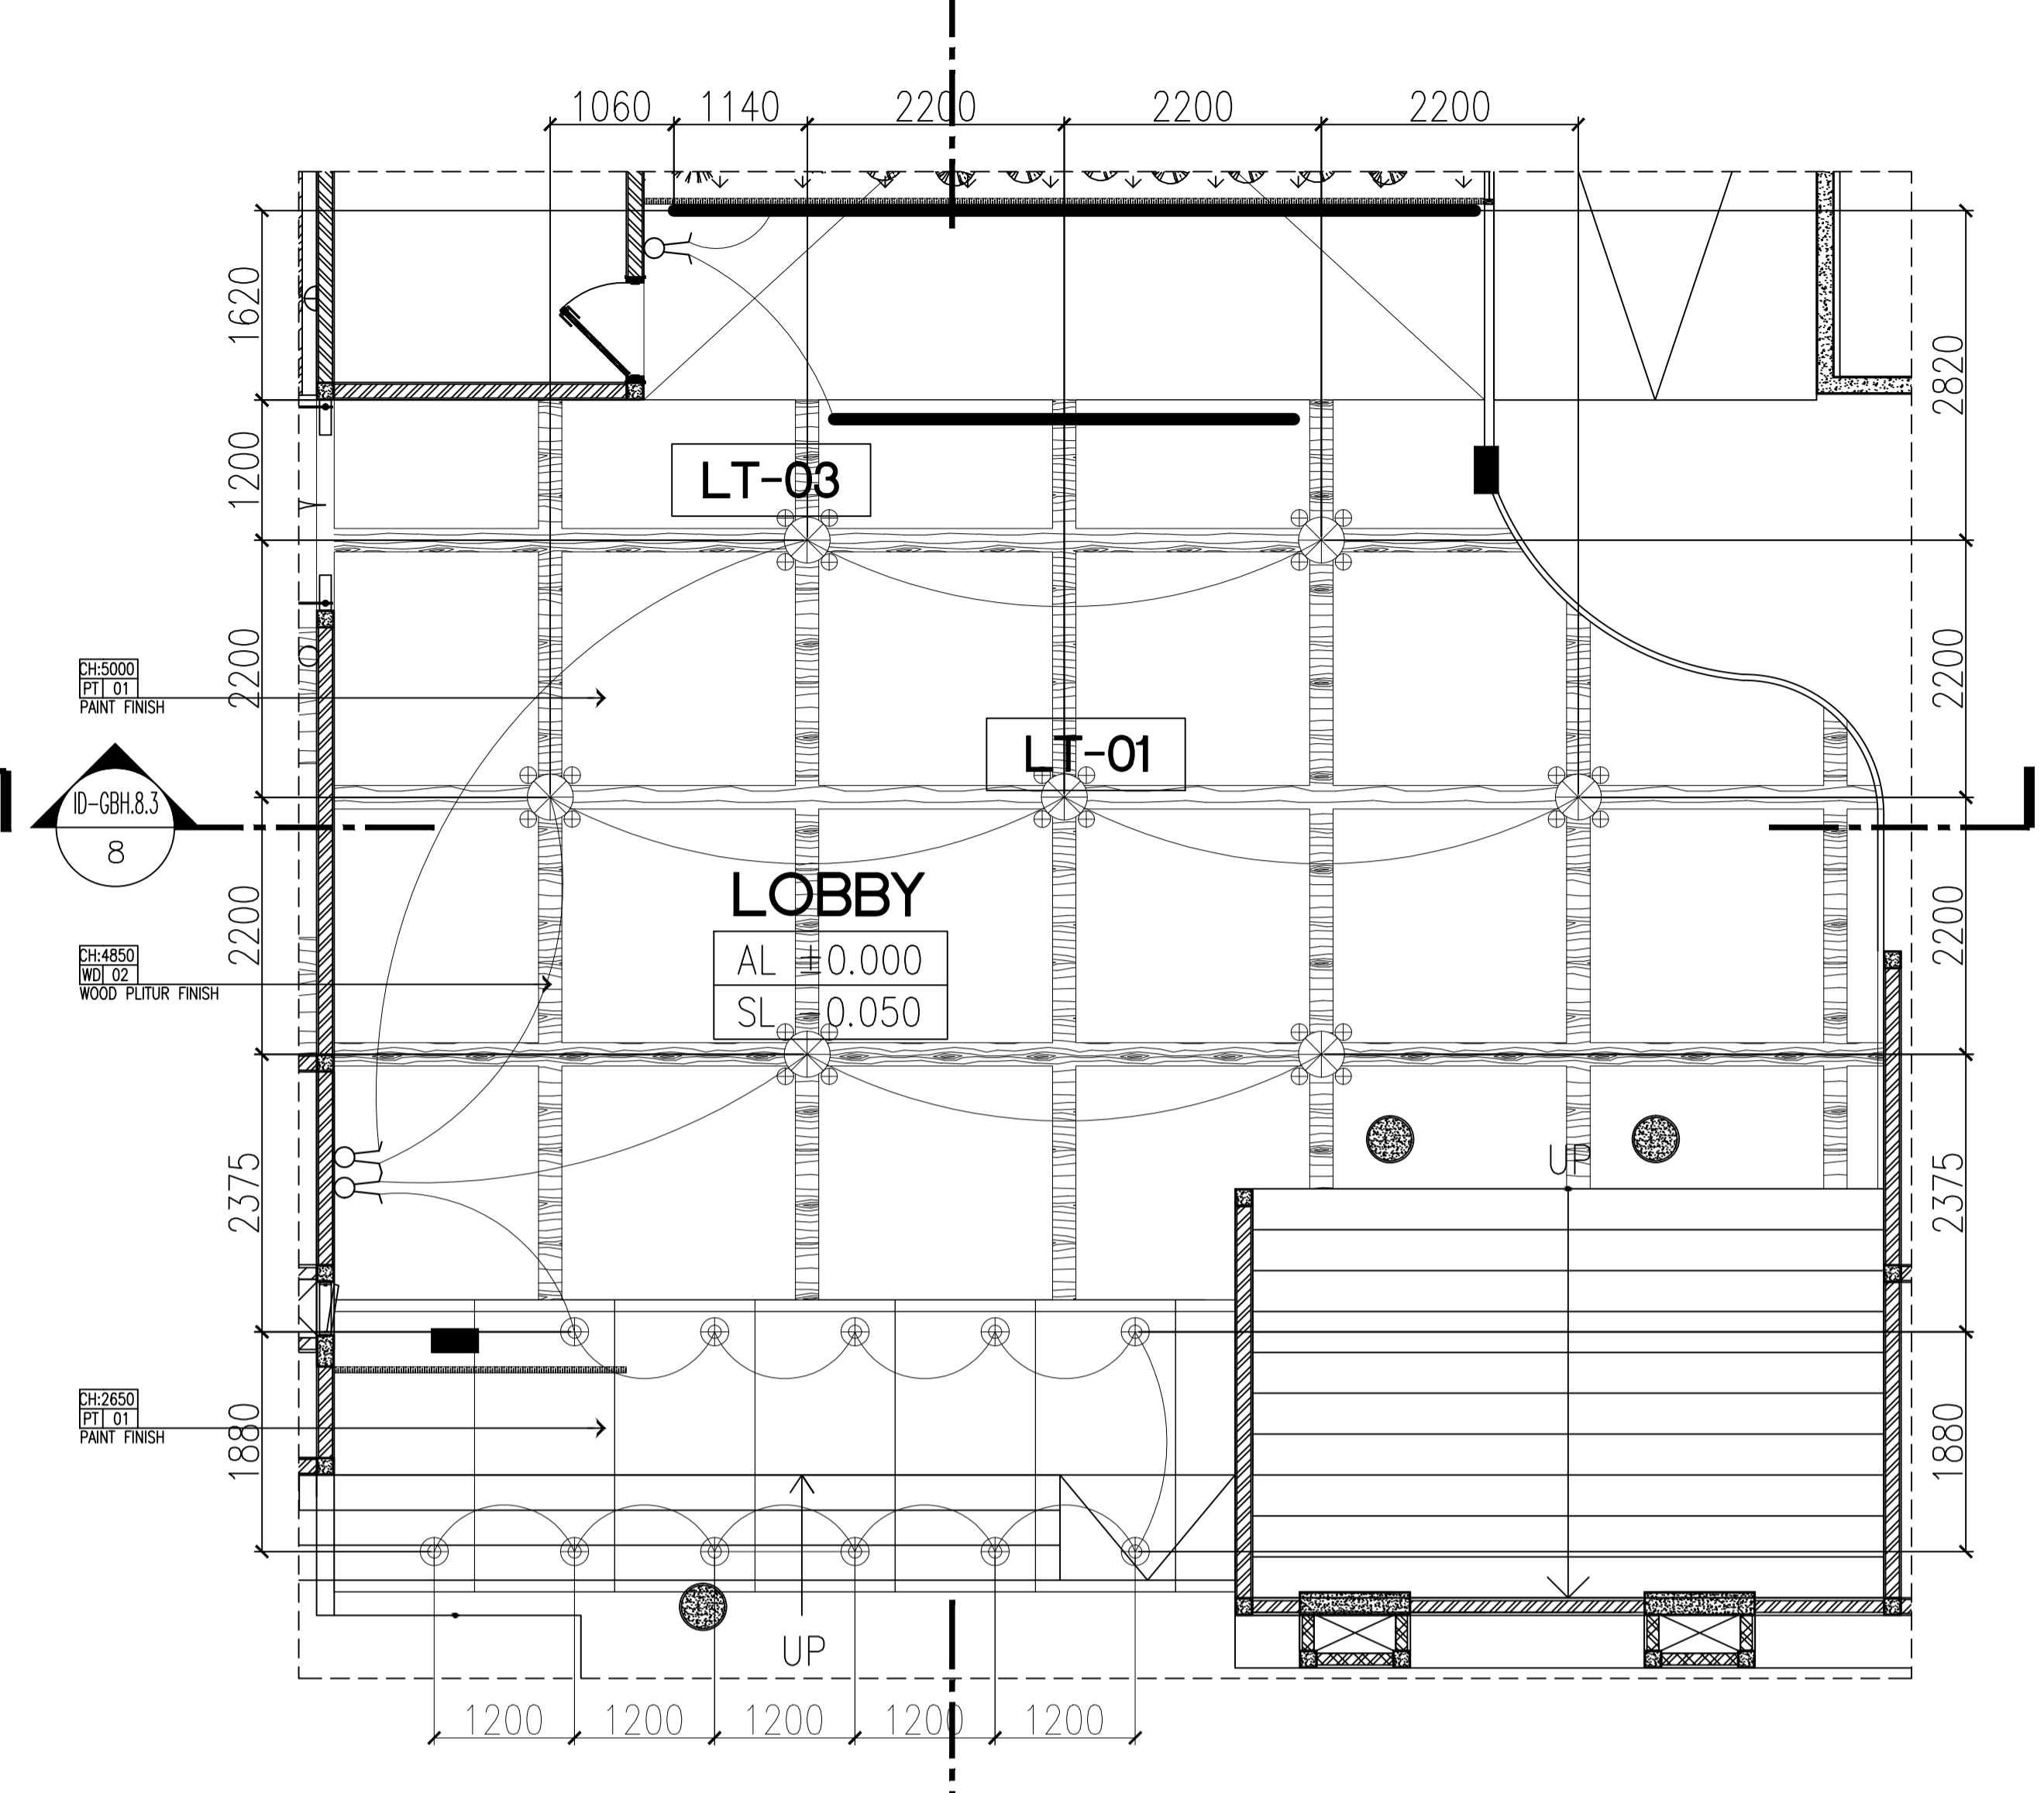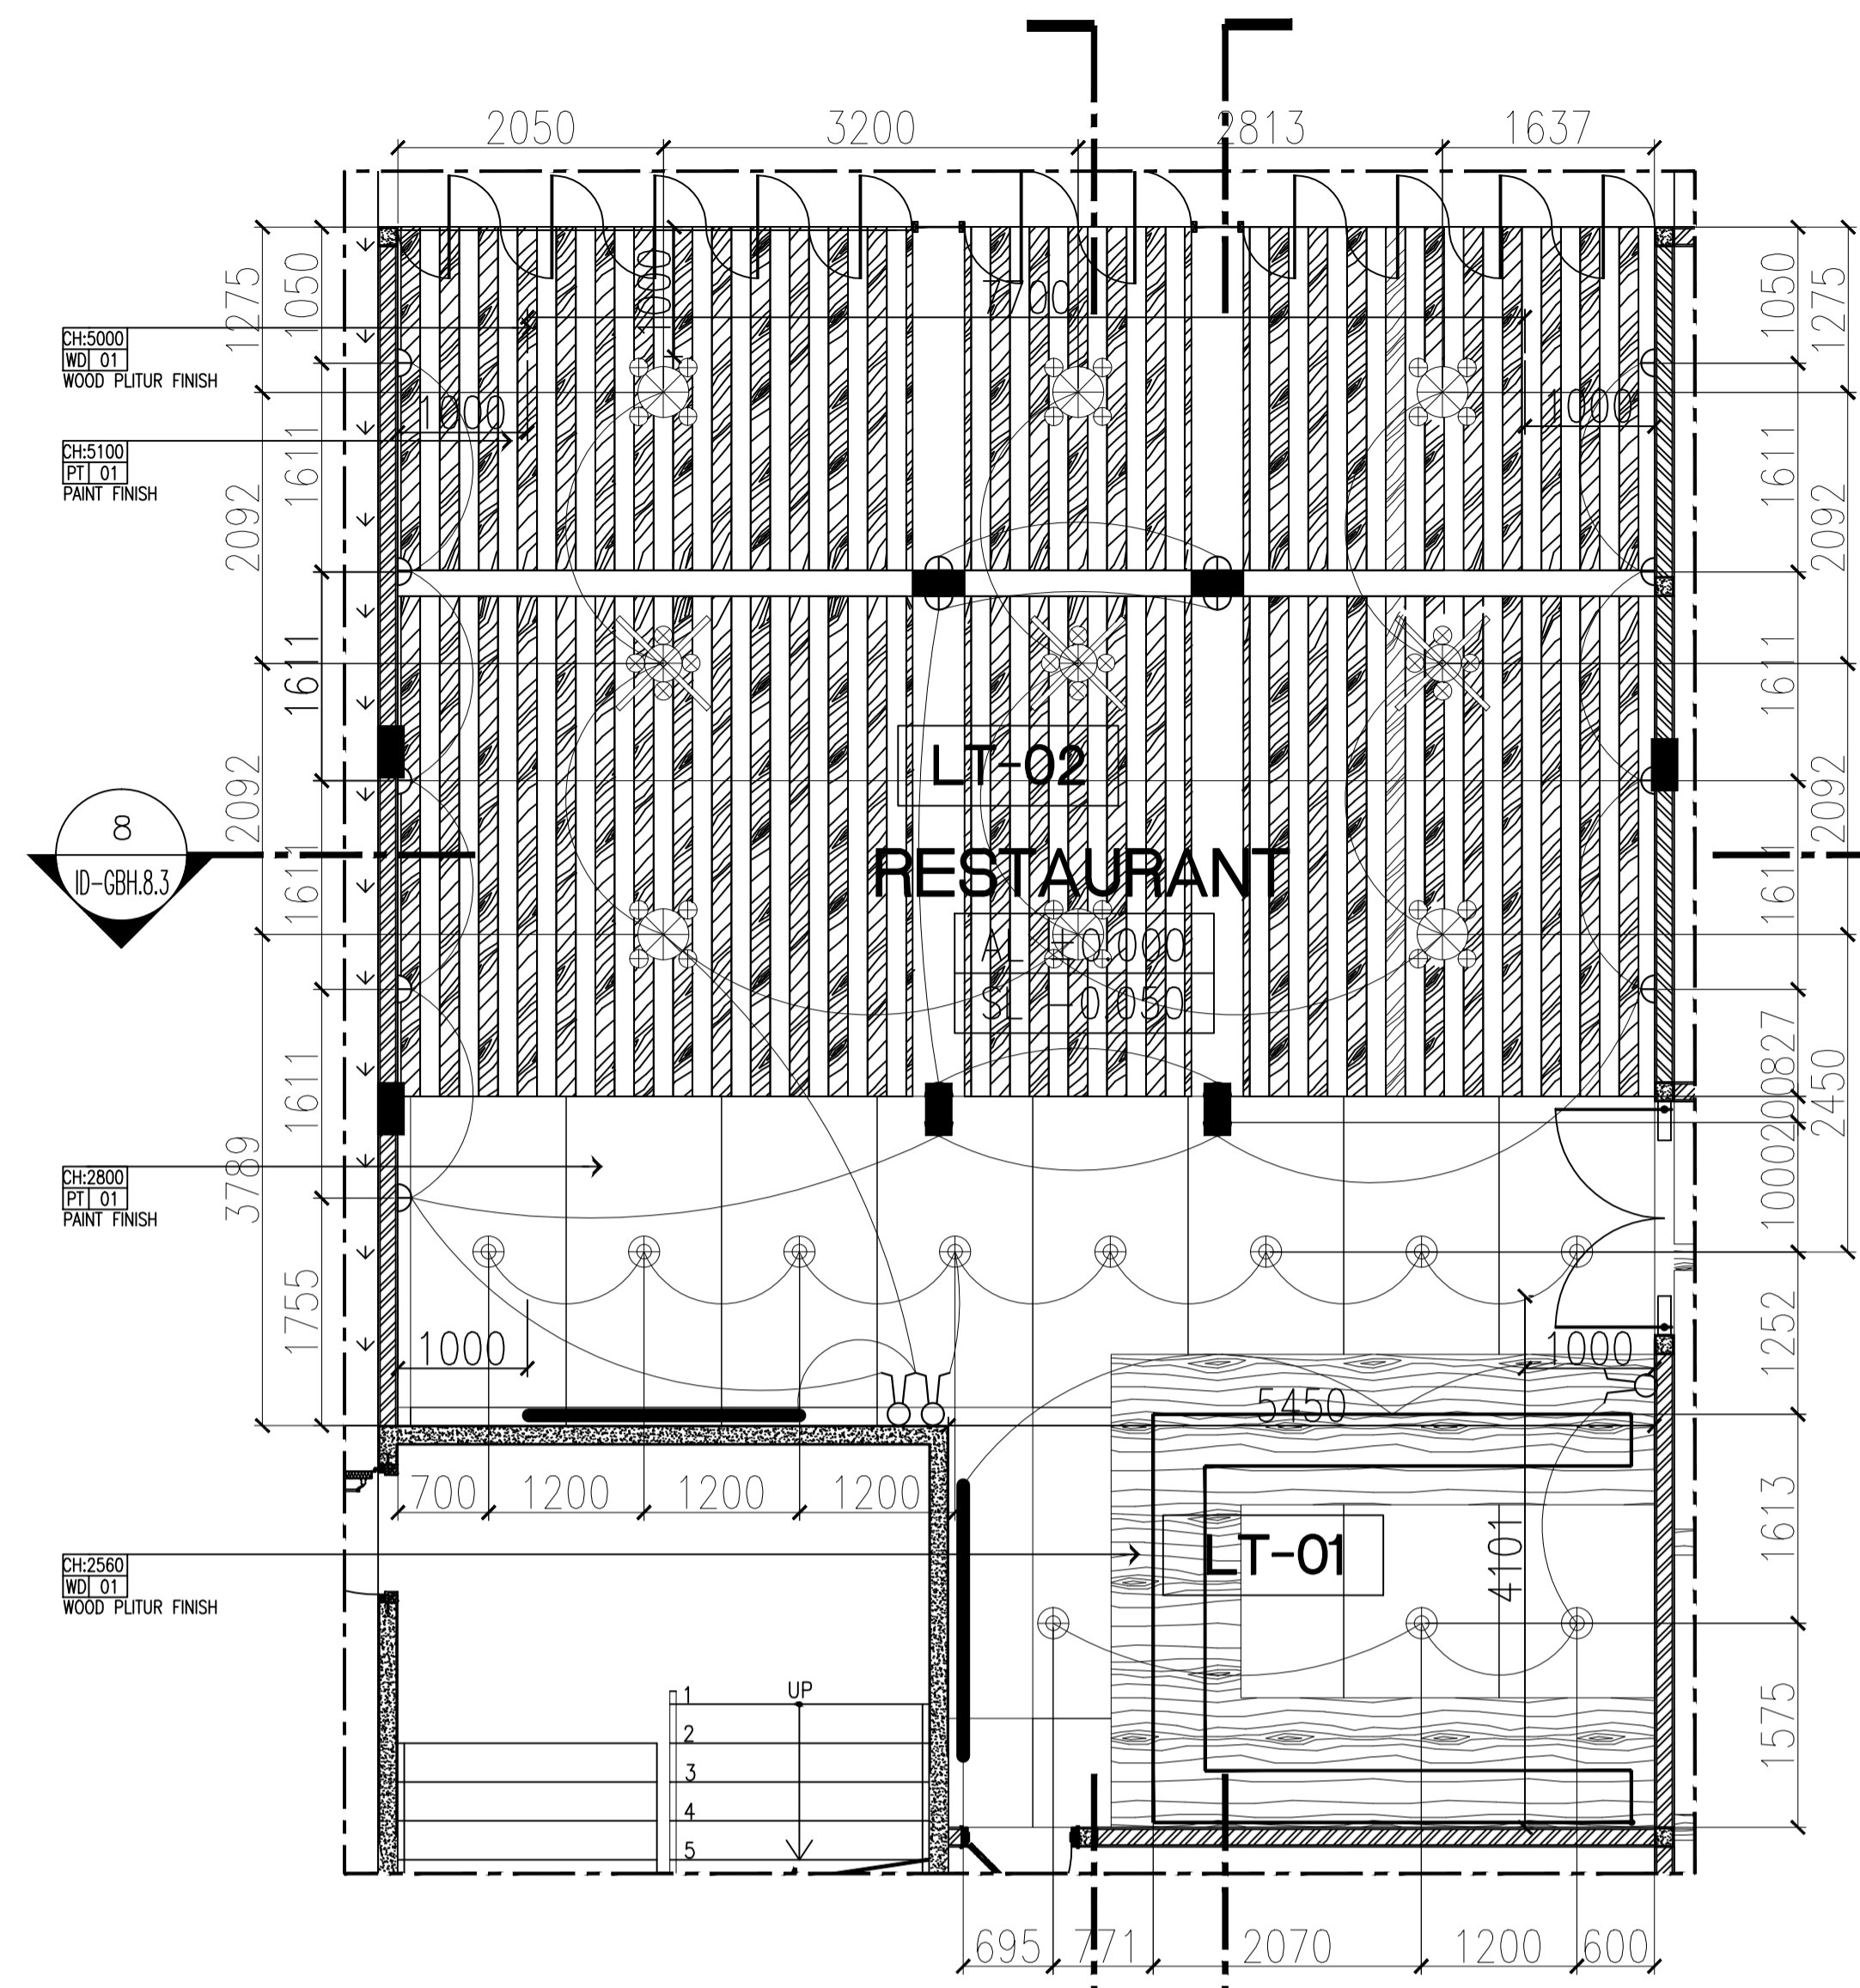

GROUND FLOOR RESTAURANT CEILING PLAN
 SCALE 1:50
 ID-GBH.4.0

GROUND FLOOR RECEPTIONIST CEILING PLAN
 SCALE 1:50
 ID-GBH.4.1

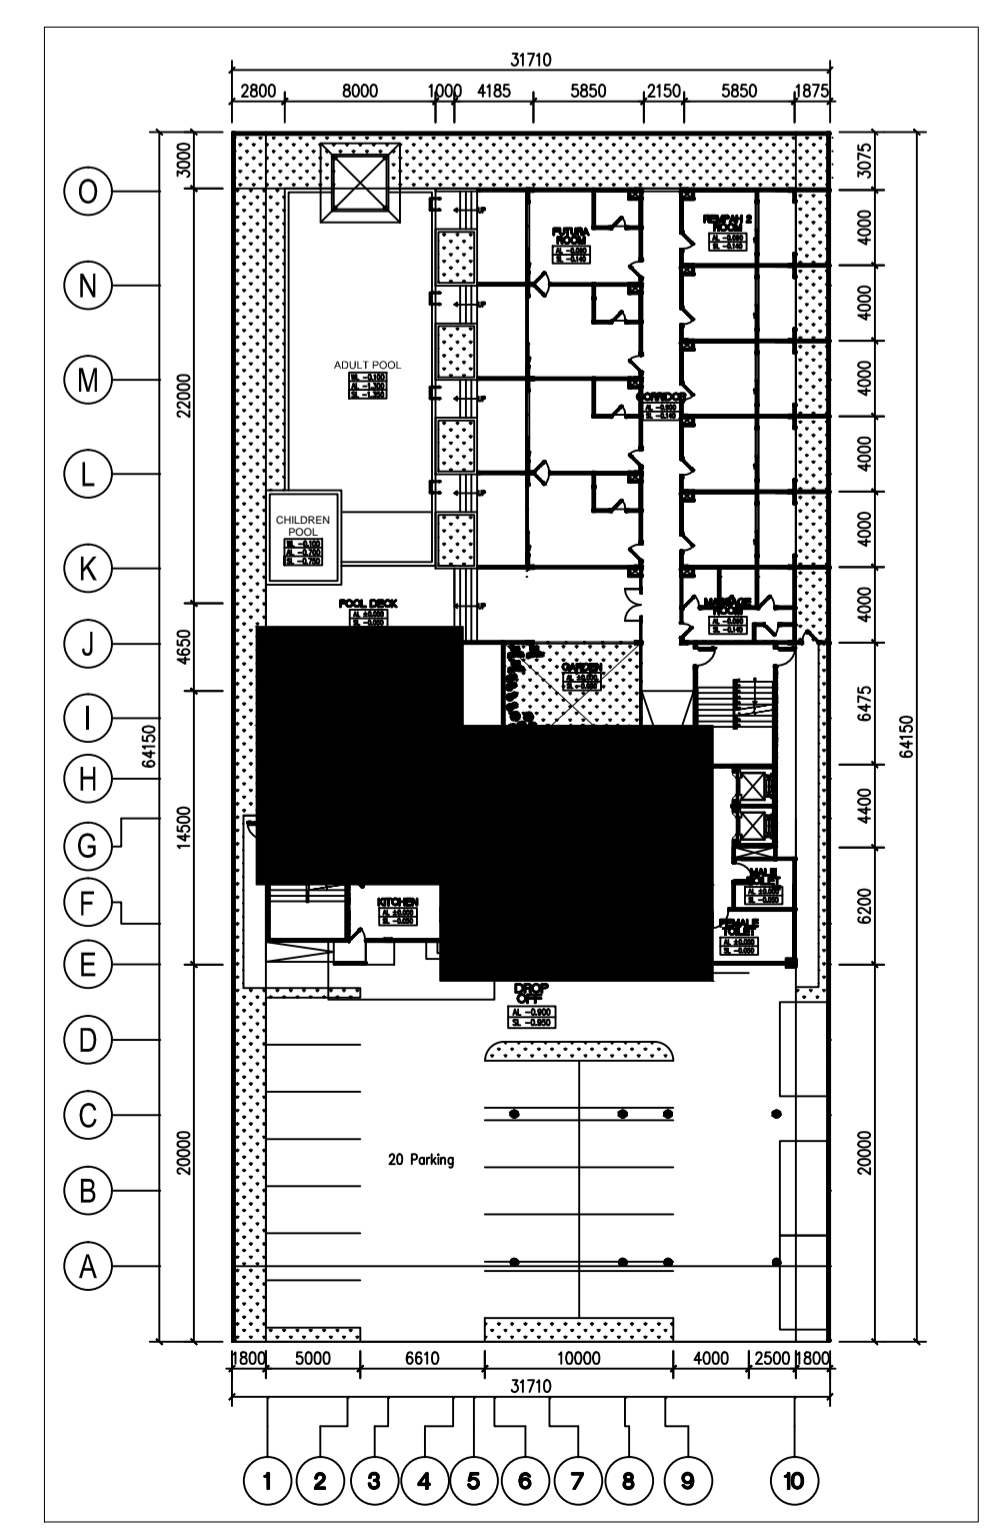

LEGEND

LIGHTING LEGEND

SYMBOL	CODE	CONTENT	SOURCE
●	CH-C11	RECESSED DOWNLIGHT	LED 12W
⊕	CH-C12	RECESSED PINHOLE	LED 15W
○	CH-C13	RECESSED DOWNLIGHT WITH ELLIPTICAL LENS	LED 15W
⊙	CH-C14	RECESSED DOWNLIGHT WITH GLASS COVER	LED
⊖	CH-C51	RECESSED WALLWASHER DOWNLIGHT	LED
⊖	CH-C31	RECESSED ADJUSTABLE PINHOLE	LED
⊖	CH-C32	RECESSED ADJUSTABLE READING LAMP	LED
⊖	CH-C33	TRACK SPOTLIGHT	LED
—	CH-C61	LINEAR INDIRECT	LED 1400mm
—	CH-W51	WALL RECESSED STEP LIGHT	LED 15W
—	CH-W61	LINEAR INDIRECT	LED 400mm
—	CH-W81	WALL LAMP	LED 15W
—	CH-F81	STANDING LAMP	LED 15W
—	CH-F82	STANDING LAMP	LED 15W
—	CH-F83	STANDING LAMP	LED 15W
—	CH-F84	TABLE LAMP	LED 15W



NAMA PROYEK :
 PERANCANGAN INTERIOR GREENHOST BOUTIQUE HOTEL

JUDUL GAMBAR :
 REFLECTED CEILING PLAN LT. GROUND (RESTAURANT & RECEPTIONIST)

NAMA :
 FARID FADILAH


NIM :
 41714010020

DOSEN PEMBIMBING :
 YOHANES NUGROHO UTOMO, Drs, M.Ds

SKALA : 1 : 50

JUMLAH GAMBAR : 10/21
 NOMOR GAMBAR : ID-GBH.4.0 ID-GBH.4.1

NILAI :
 PARAF :

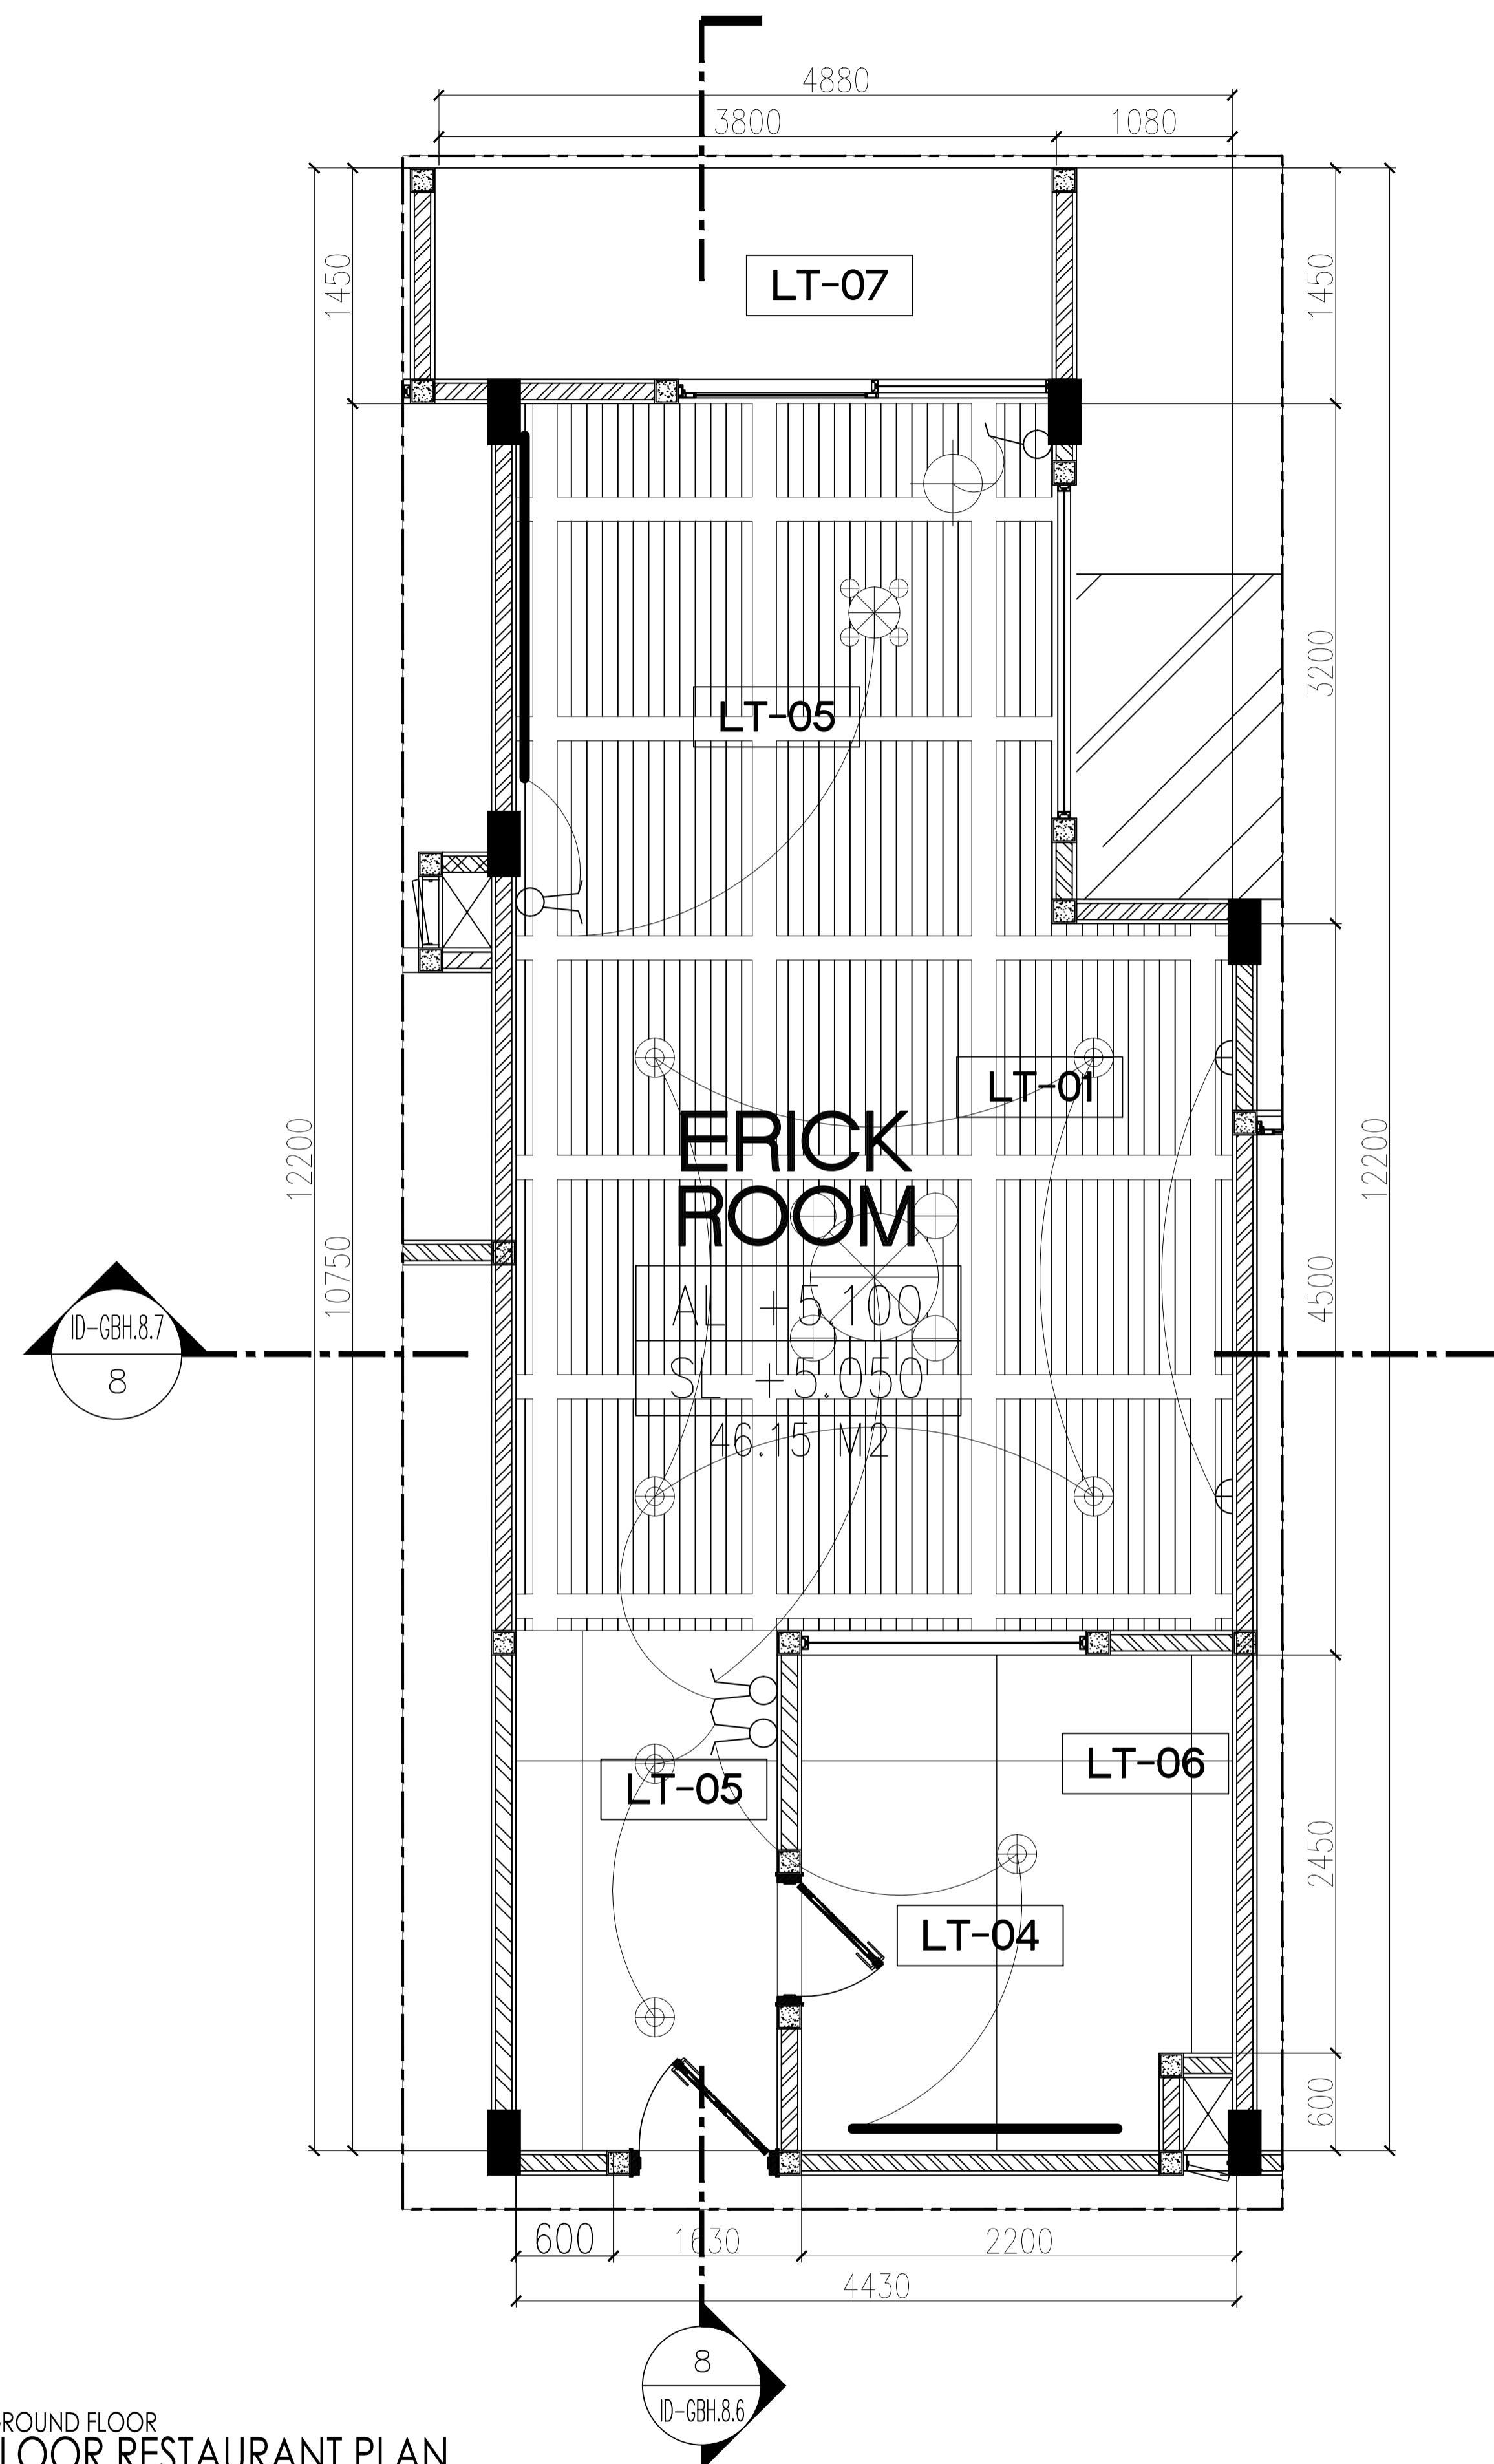

GROUND FLOOR
FLOOR RESTAURANT PLAN
SCALE 1:30
3
ID-GBH.3.2


8
ID-GBH.8.6

ERICK ROOM
AL +5.100
SL +5.050
46.15 M2

LEGEND

LIGHTING LEGEND

SYMBOL	CODE	CONTENT	SOURCE
	CH-C11	RECESSED DOWNLIGHT	LED 12W
	CH-C12	RECESSED PINHOLE	LED 15W
	CH-C13	RECESSED DOWNLIGHT WITH ELLIPTICAL LENS	LED 15W
	CH-C14	RECESSED DOWNLIGHT WITH GLASS COVER	LED
	CH-C31	RECESSED WALLWASHER DOWNLIGHT	LED
	CH-C32	RECESSED ADJUSTABLE PINHOLE	LED
	CH-C32	RECESSED ADJUSTABLE READING LAMP	LED
	CH-C33	TRACK SPOTLIGHT	LED
	CH-C61	LINEAR INDIRECT	LED 14W/m
	CH-W51	WALL RECESSED STEP LIGHT	LED 15W
	CH-W61	LINEAR INDIRECT	LED 40W/m
	CH-W81	WALL LAMP	LED 15W
	CH-FB1	STANDING LAMP	LED 15W
	CH-FB2	STANDING LAMP	LED 15W
	CH-FB3	STANDING LAMP	LED 15W
	CH-FB4	TABLE LAMP	LED 15W

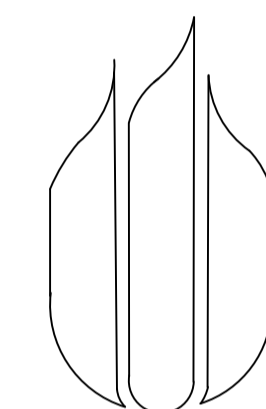

UNIVERSITAS
MERCU BUANA

NAMA PROYEK :

PERANCANGAN INTERIOR
GREENHOST BOUTIQUE HOTEL

JUDUL GAMBAR :

REFLECTED CEILING PLAN LT. TIGA
(ERICK ROOM)

NAMA :

FARID FADILAH

NIM :

41714010020

DOSEN PEMBIMBING :

YOHANES NUGROHO UTOMO, Drs, M.Ds

SKALA : 1 : 30


JUMLAH GAMBAR : NOMOR GAMBAR :


10/21

ID-GBH.4.2


NILAI :

PARAF :

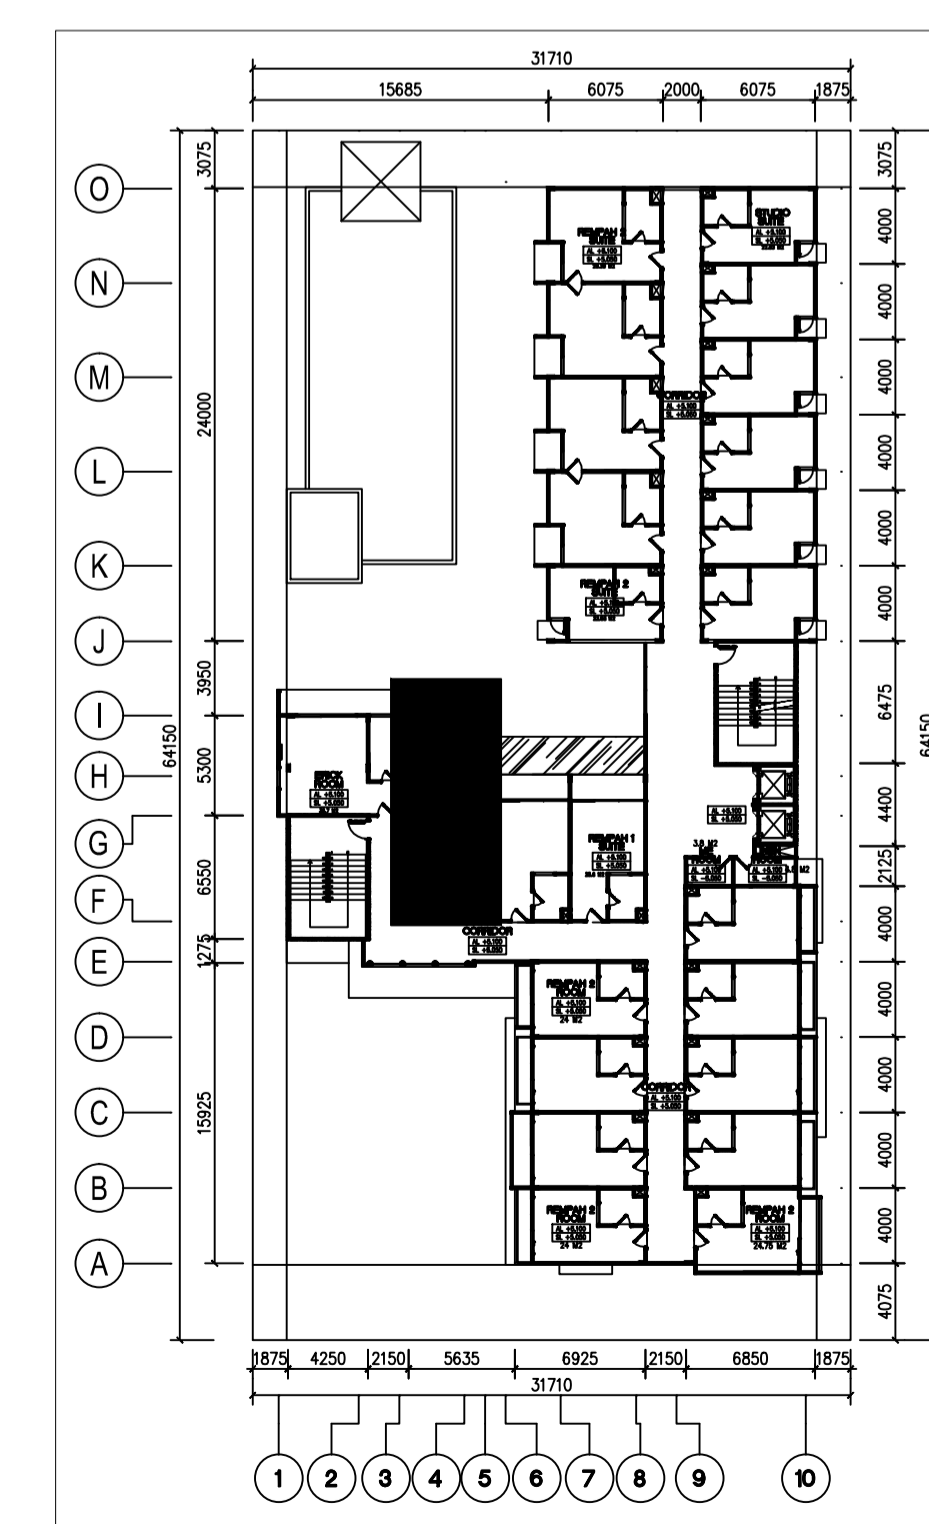

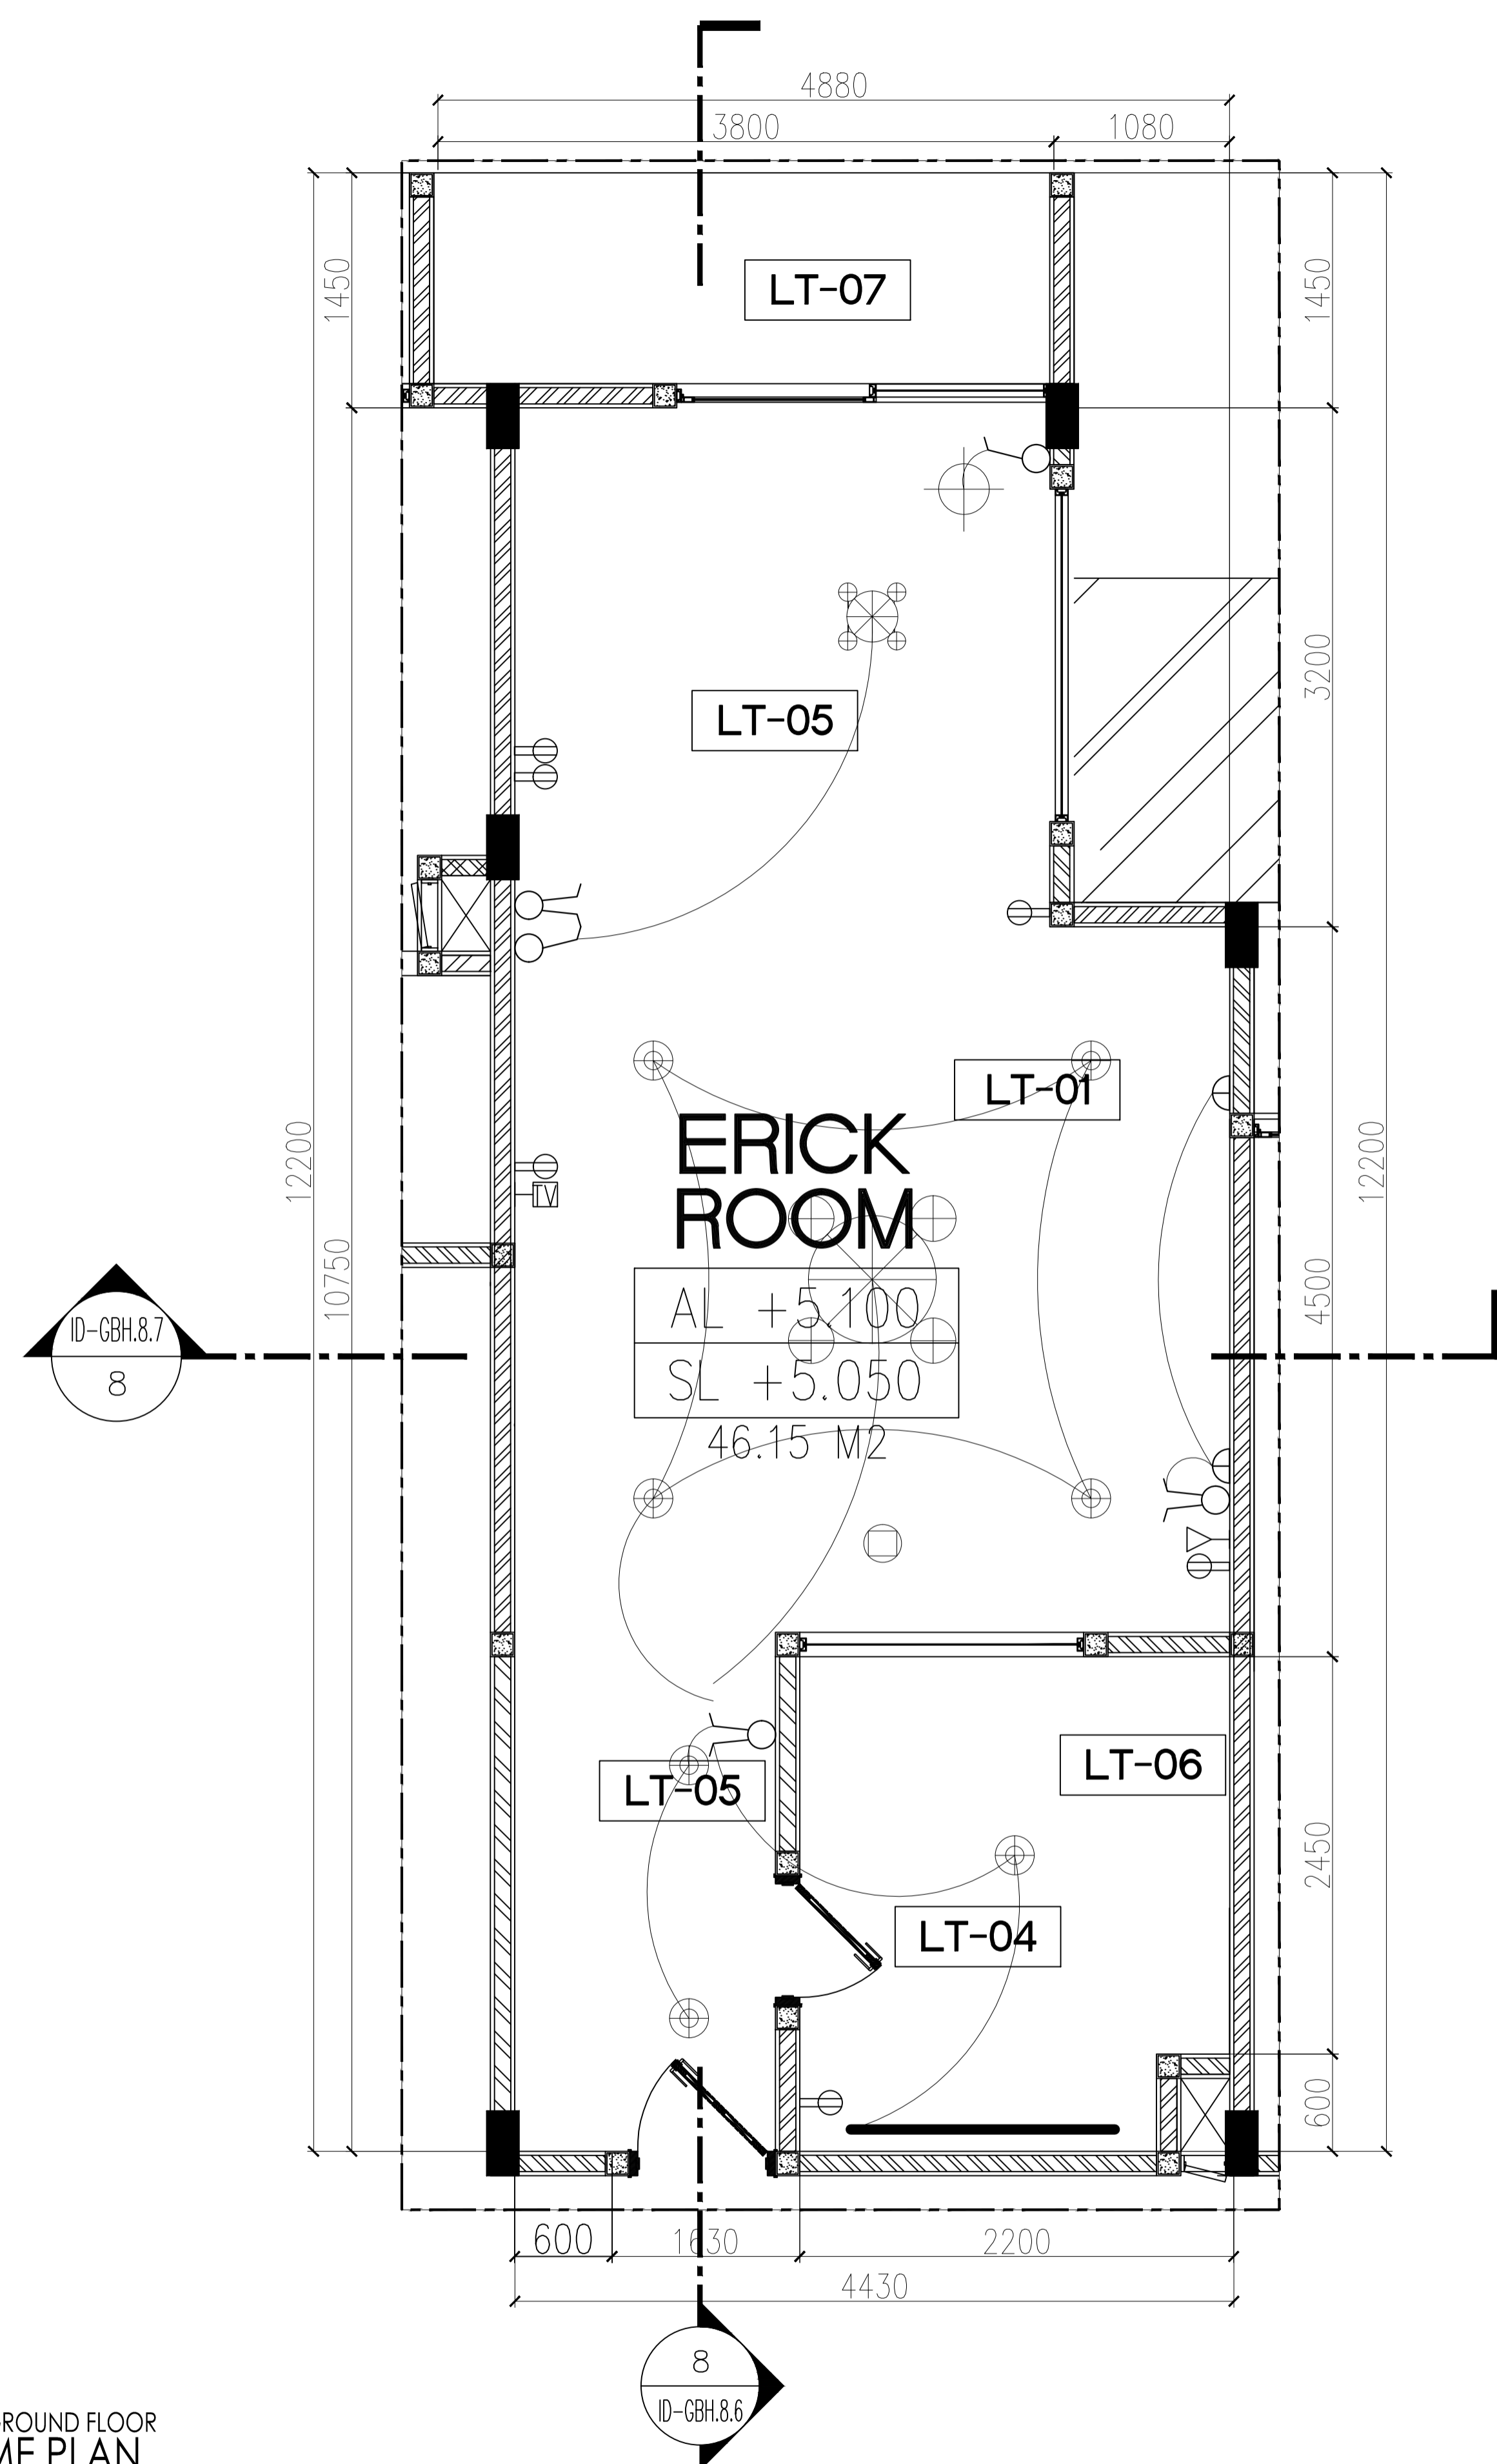


5
ID-GBH.5.2
GROUND FLOOR
ME PLAN
SCALE 1:30

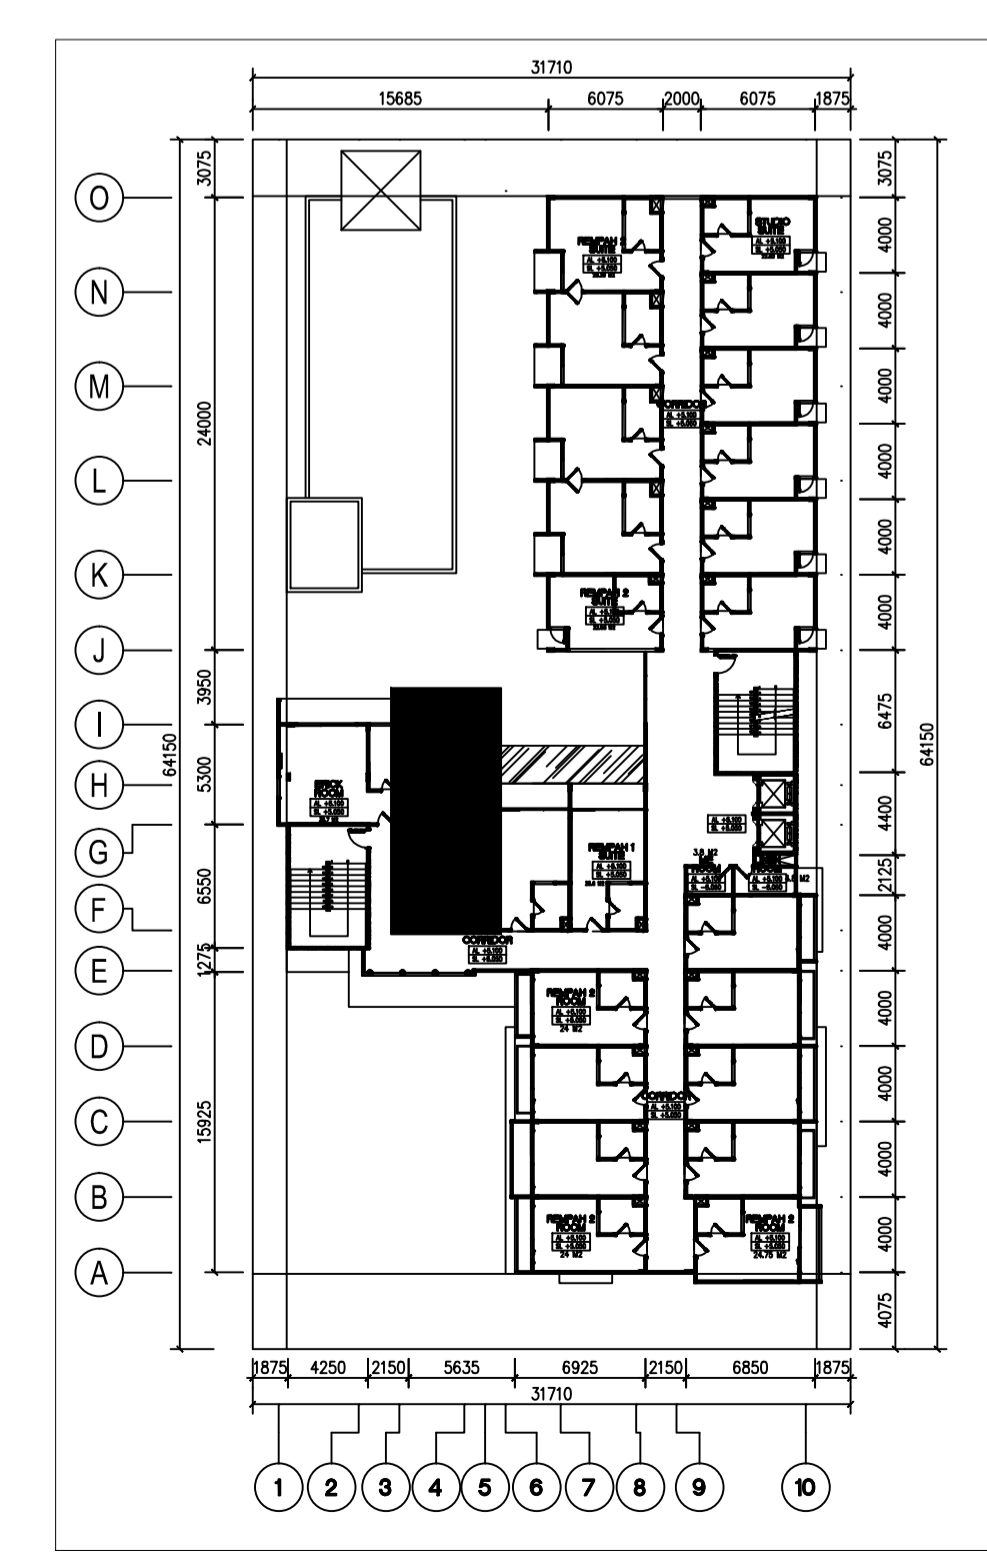

LEGEND

LIGHTING LEGEND

SYMBOL	CODE	CONTENT	SOURCE
	CH-C11	RECESSED DOWNLIGHT	LED 12W
	CH-C12	RECESSED PINHOLE	LED 15W
	CH-C13	RECESSED DOWNLIGHT WITH ELLIPTICAL LENS	LED 15W
	CH-C14	RECESSED DOWNLIGHT WITH GLASS COVER	LED
	CH-C31	RECESSED WALLWASHER DOWNLIGHT	LED
	CH-C31	RECESSED ADJUSTABLE PINHOLE	LED
	CH-C32	RECESSED ADJUSTABLE READING LAMP	LED
	CH-C33	TRACK SPOTLIGHT	LED
	CH-C61	LINEAR INDIRECT	LED 14W/m
	CH-W51	WALL RECESSED STEP LIGHT	LED 15W
	CH-W61	LINEAR INDIRECT	LED 46W/m
	CH-W81	WALL LAMP	LED 15W
	CH-FB1	STANDING LAMP	LED 15W
	CH-FB2	STANDING LAMP	LED 15W
	CH-FB3	STANDING LAMP	LED 15W
	CH-FB4	TABLE LAMP	LED 15W

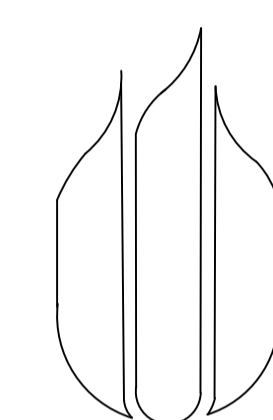

UNIVERSITAS
MERCU BUANA

NAMA PROYEK :

PERANCANGAN INTERIOR
GREENHOST BOUTIQUE HOTEL

JUDUL GAMBAR :

MECHANICAL ELECTRICAL PLAN LT. TIGA
(ERICK ROOM)

NAMA :

FARID FADILAH

NIM :

41714010020

DOSEN PEMBIMBING :

YOHANES NUGROHO UTOMO, Drs, M.Ds

SKALA : 1 : 30


JUMLAH GAMBAR : NOMOR GAMBAR :

12/21


ID-GBH.5.2

NILAI :


PARAF :

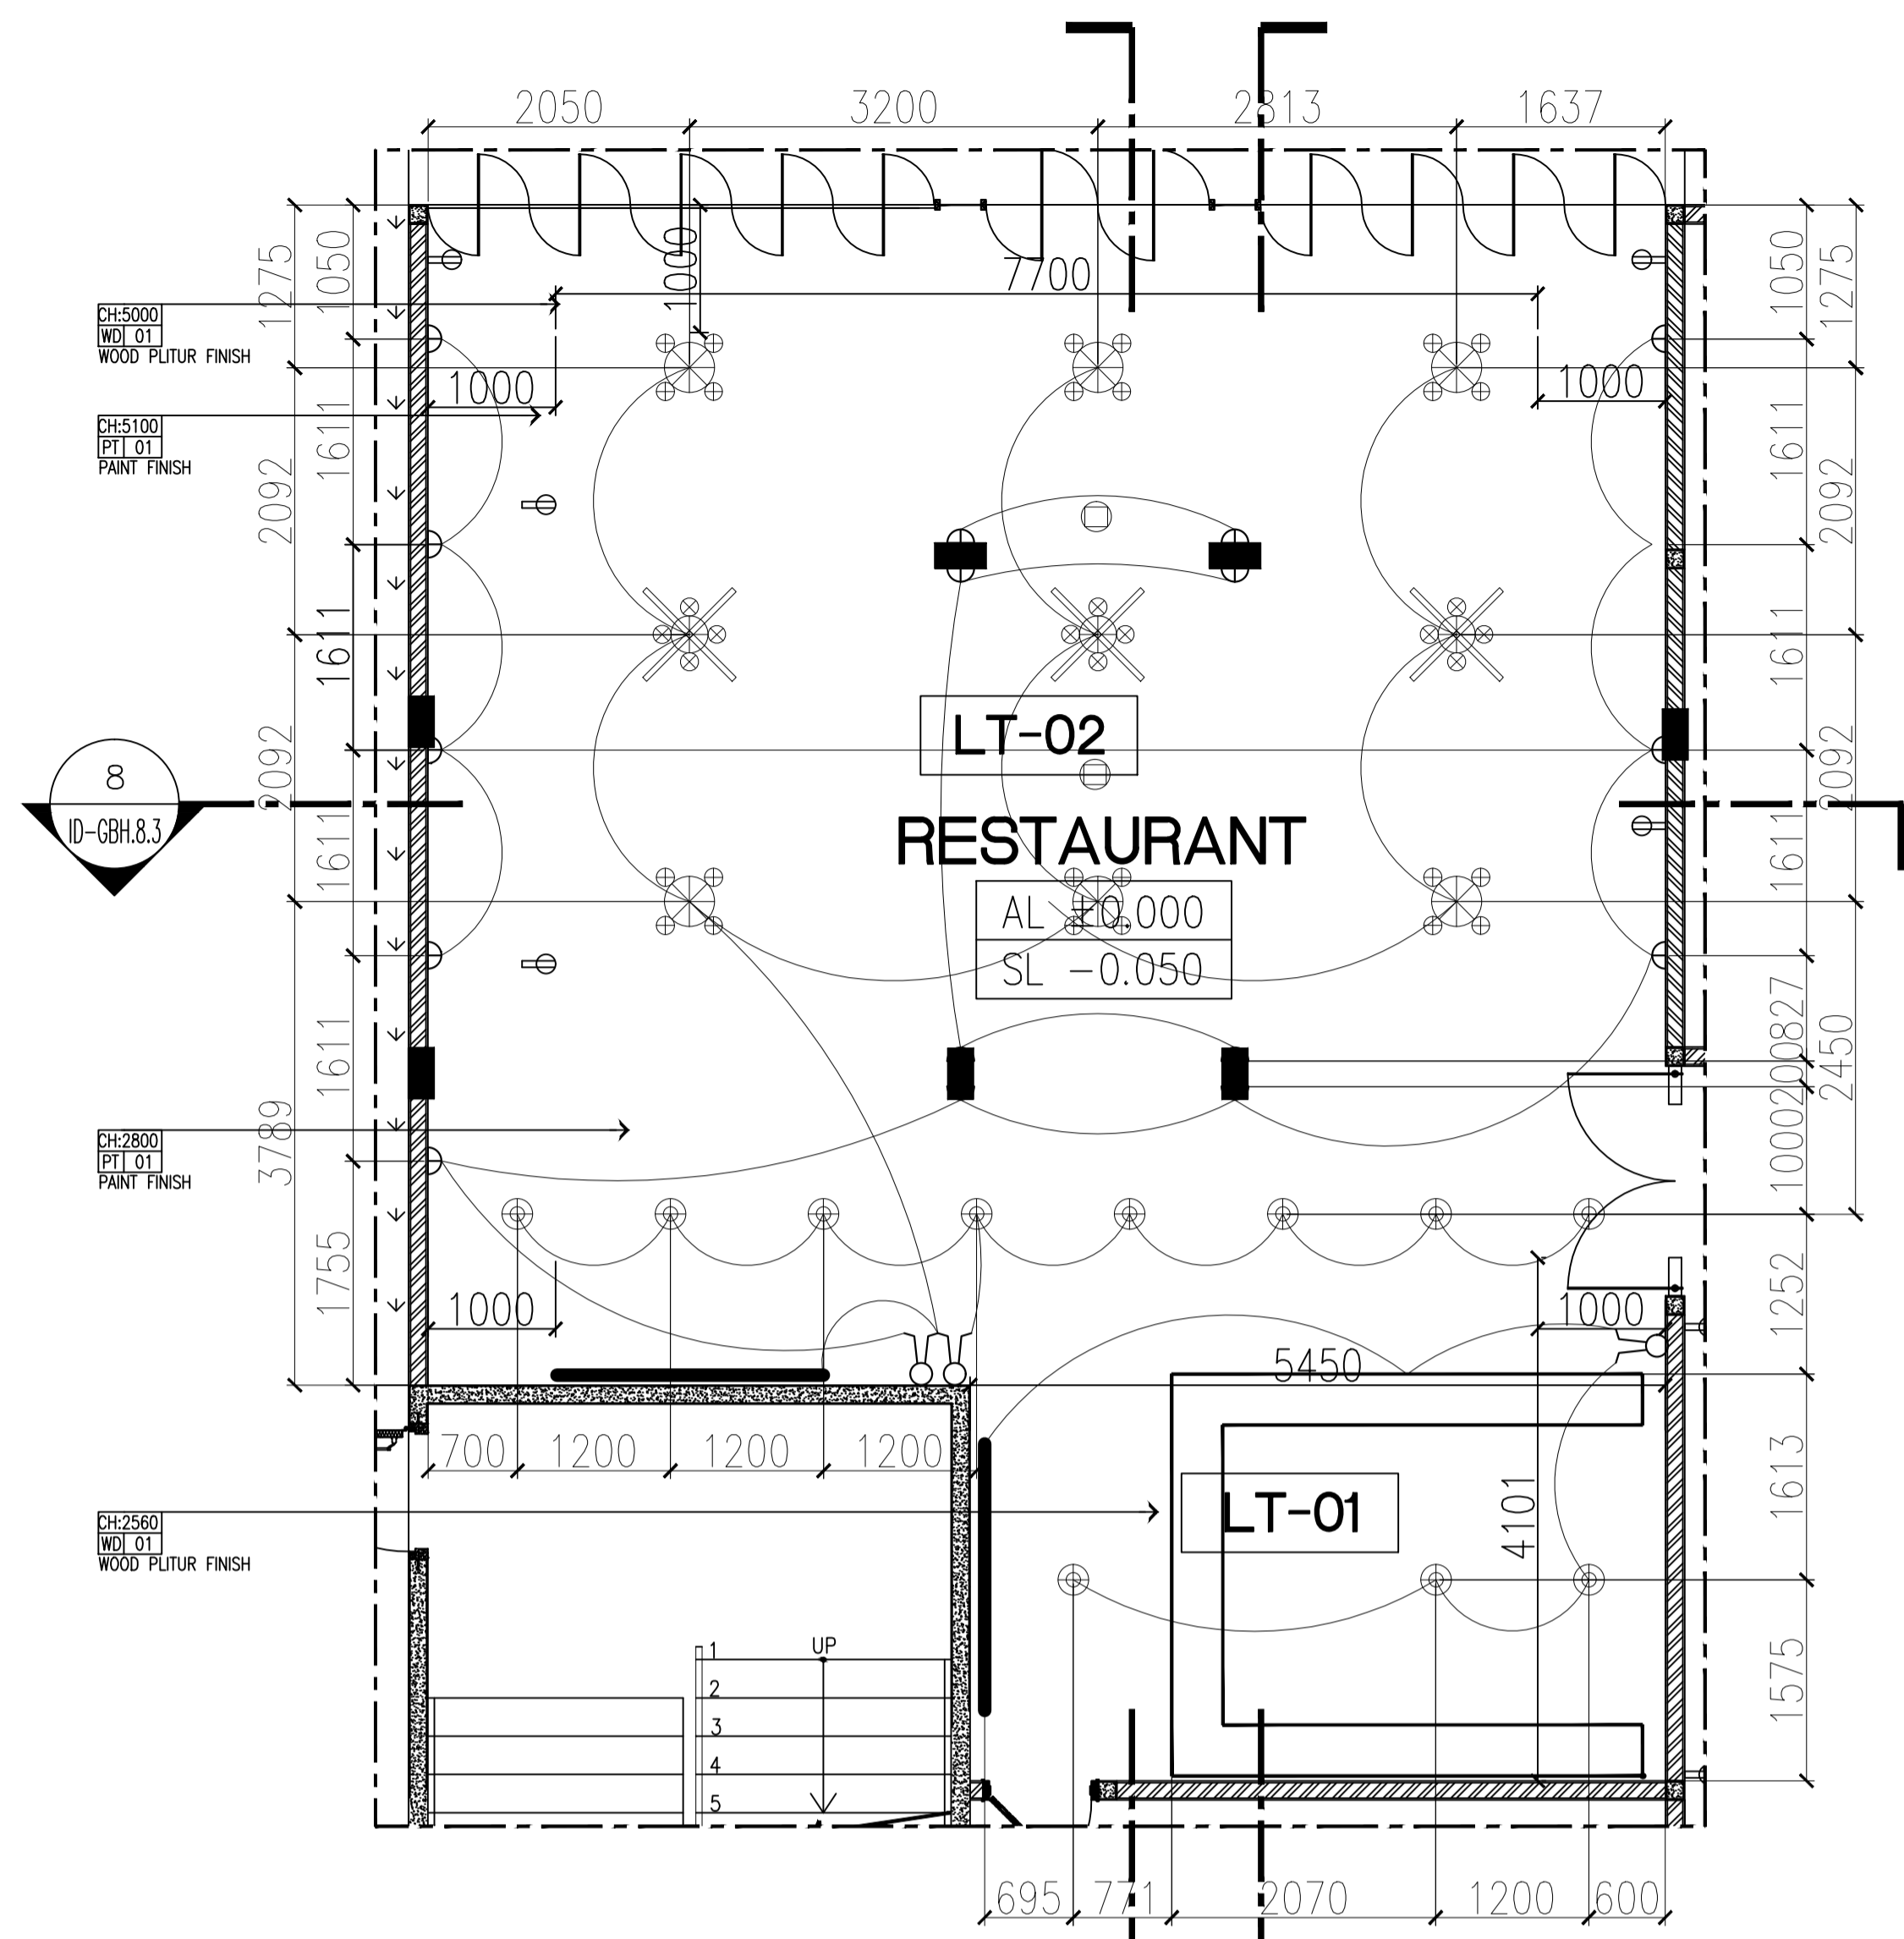

5 GROUND FLOOR ME PLAN SCALE 1:50
ID-GBH.5.0

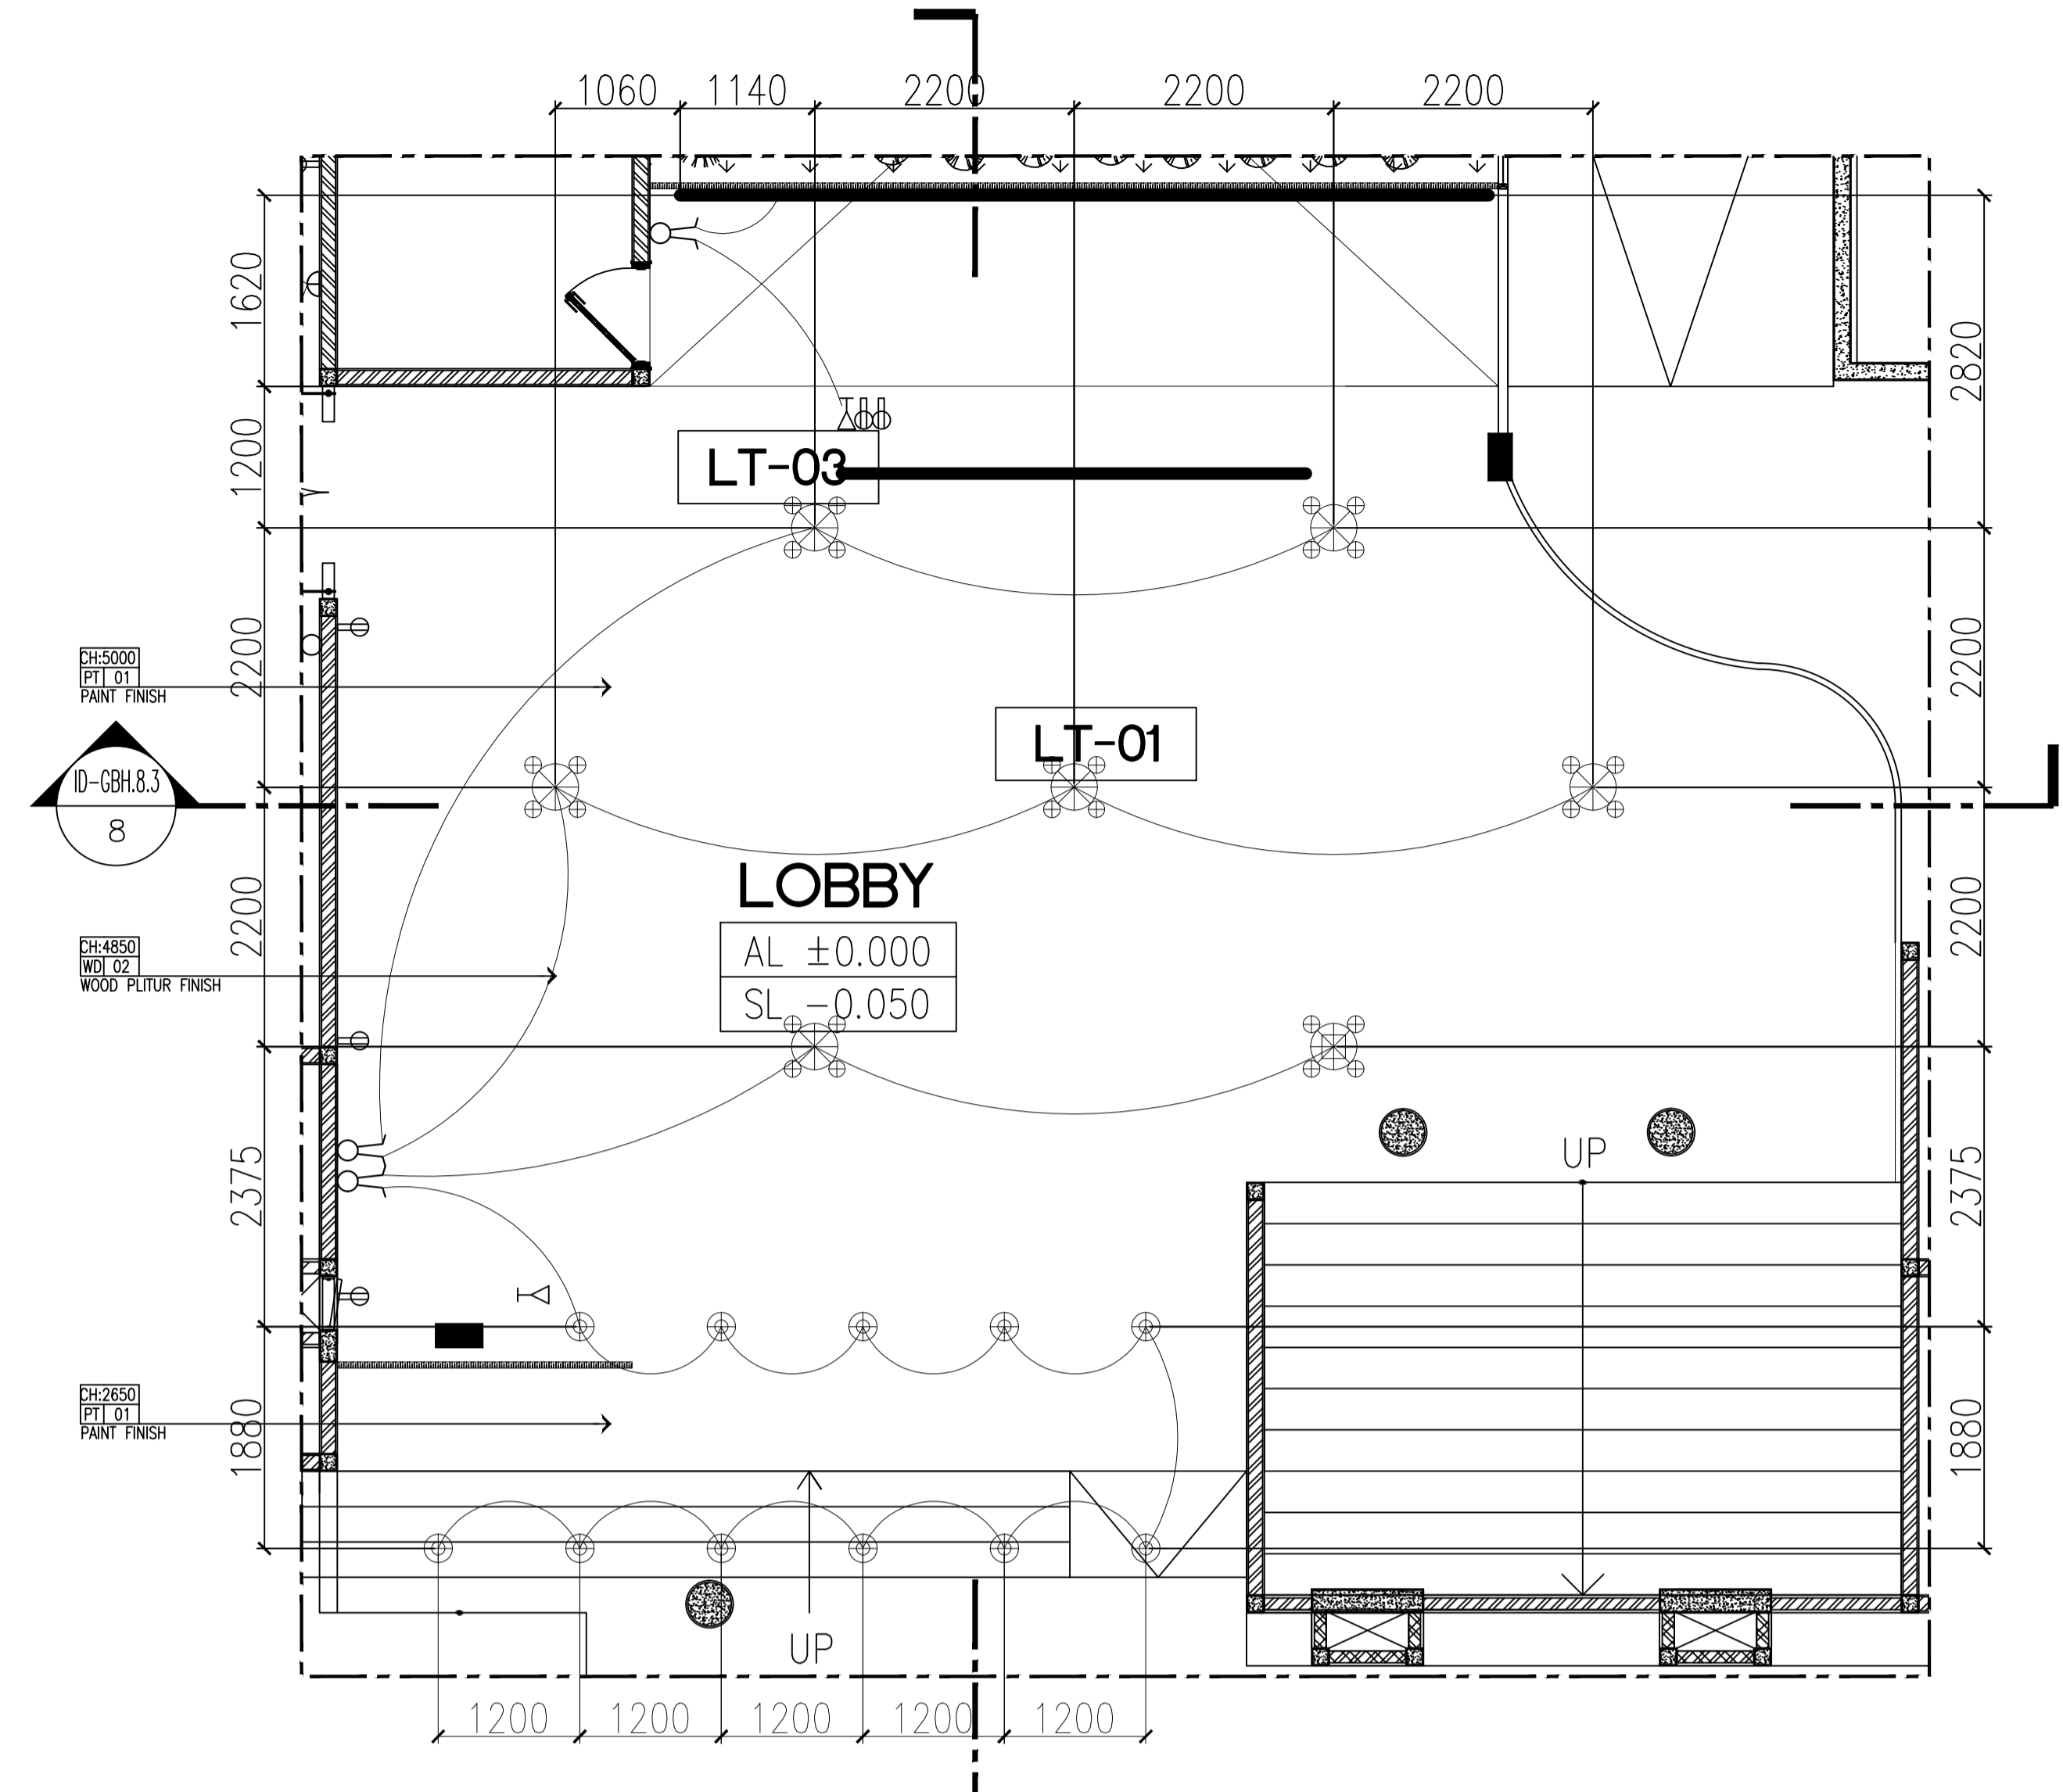

5 GROUND FLOOR ME PLAN SCALE 1:50
ID-GBH.5.1

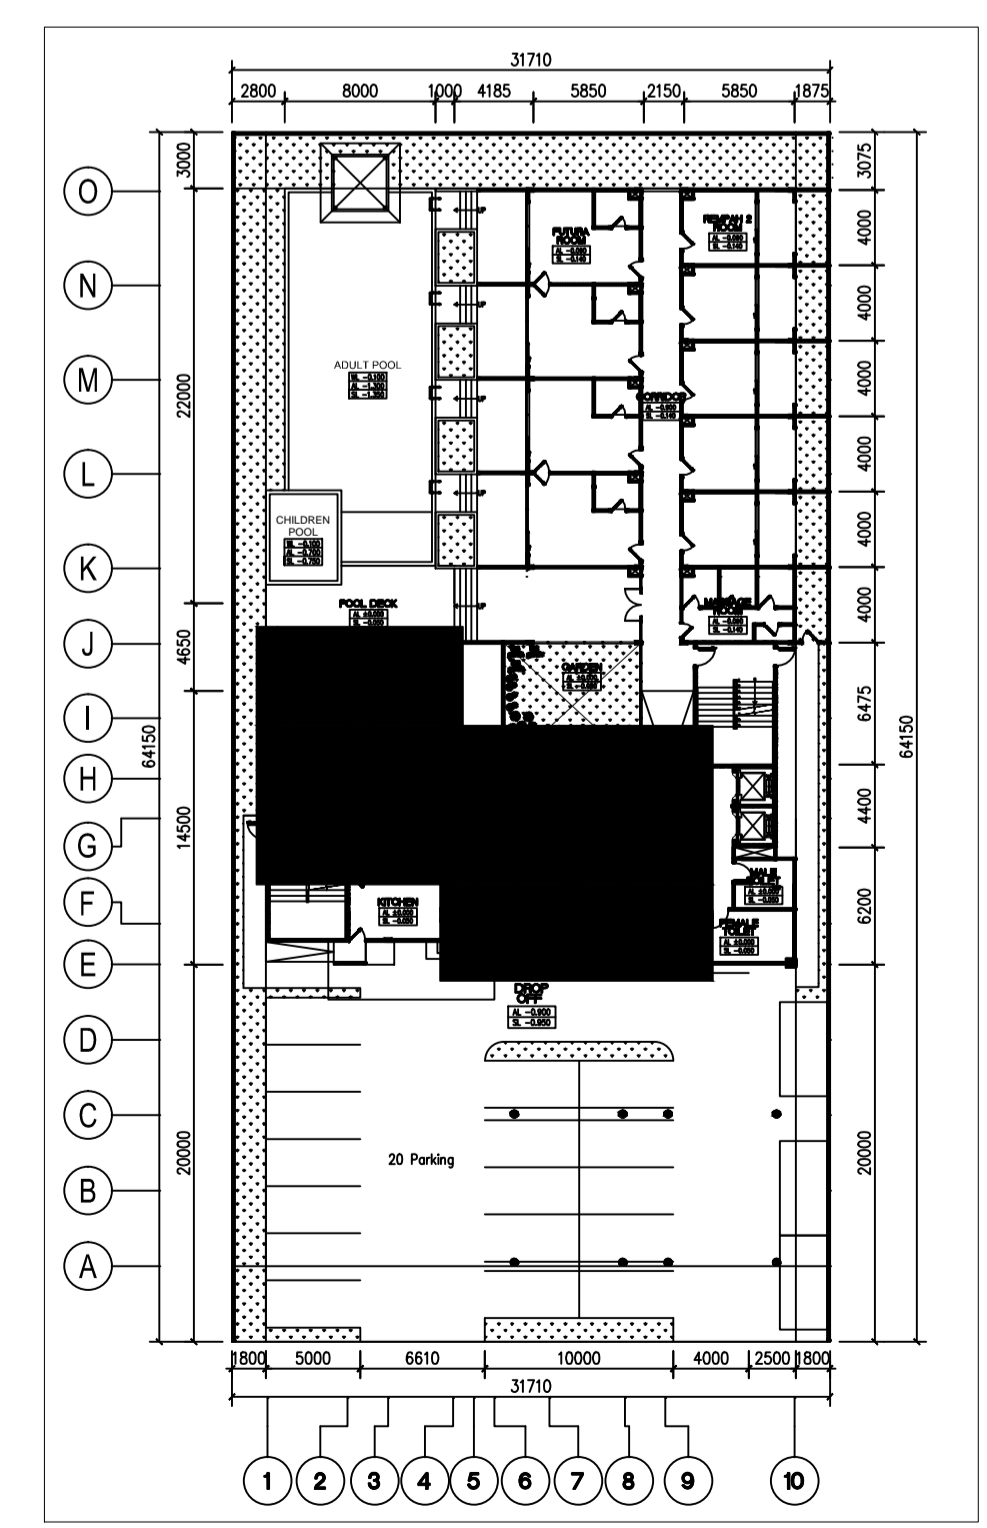

LEGEND

LIGHTING LEGEND

SYMBOL	CODE	CONTENT	SOURCE
⊙	CH-C11	RECESSED DOWNLIGHT	LED 12W
⊕	CH-C12	RECESSED PINHOLE	LED 15W
⊙	CH-C13	RECESSED DOWNLIGHT WITH ELLIPTICAL LENS	LED 15W
⊙	CH-C14	RECESSED DOWNLIGHT WITH GLASS COVER	LED
⊙	CH-C51	RECESSED WALLWASHER DOWNLIGHT	LED
⊙	CH-C31	RECESSED ADJUSTABLE PINHOLE	LED
⊙	CH-C32	RECESSED ADJUSTABLE READING LAMP	LED
⊙	CH-C33	TRACK SPOTLIGHT	LED
—	CH-C61	LINEAR INDIRECT	LED 1400mm
—	CH-W51	WALL RECESSED STEP LIGHT	LED 15W
—	CH-W61	LINEAR INDIRECT	LED 400mm
—	CH-W61	WALL LAMP	LED 15W
⊙	CH-F81	STANDING LAMP	LED 15W
⊙	CH-F82	STANDING LAMP	LED 15W
⊙	CH-F83	STANDING LAMP	LED 15W
⊙	CH-F84	TABLE LAMP	LED 15W



NAMA PROYEK :
PERANCANGAN INTERIOR GREENHOST BOUTIQUE HOTEL

JUDUL GAMBAR :
MECHANICAL ELECTRICAL PLAN LT. GROUND (RESTAURANT & RECEPTIONIST)

NAMA :
FARID FADILAH


NIM :
41714010020

DOSEN PEMBIMBING :
YOHANES NUGROHO UTOMO, Drs, M.Ds


SKALA : 1 : 50

JUMLAH GAMBAR : 11/21
NOMOR GAMBAR : ID-GBH.5.0 ID-GBH.5.1


NILAI :
PARAF :

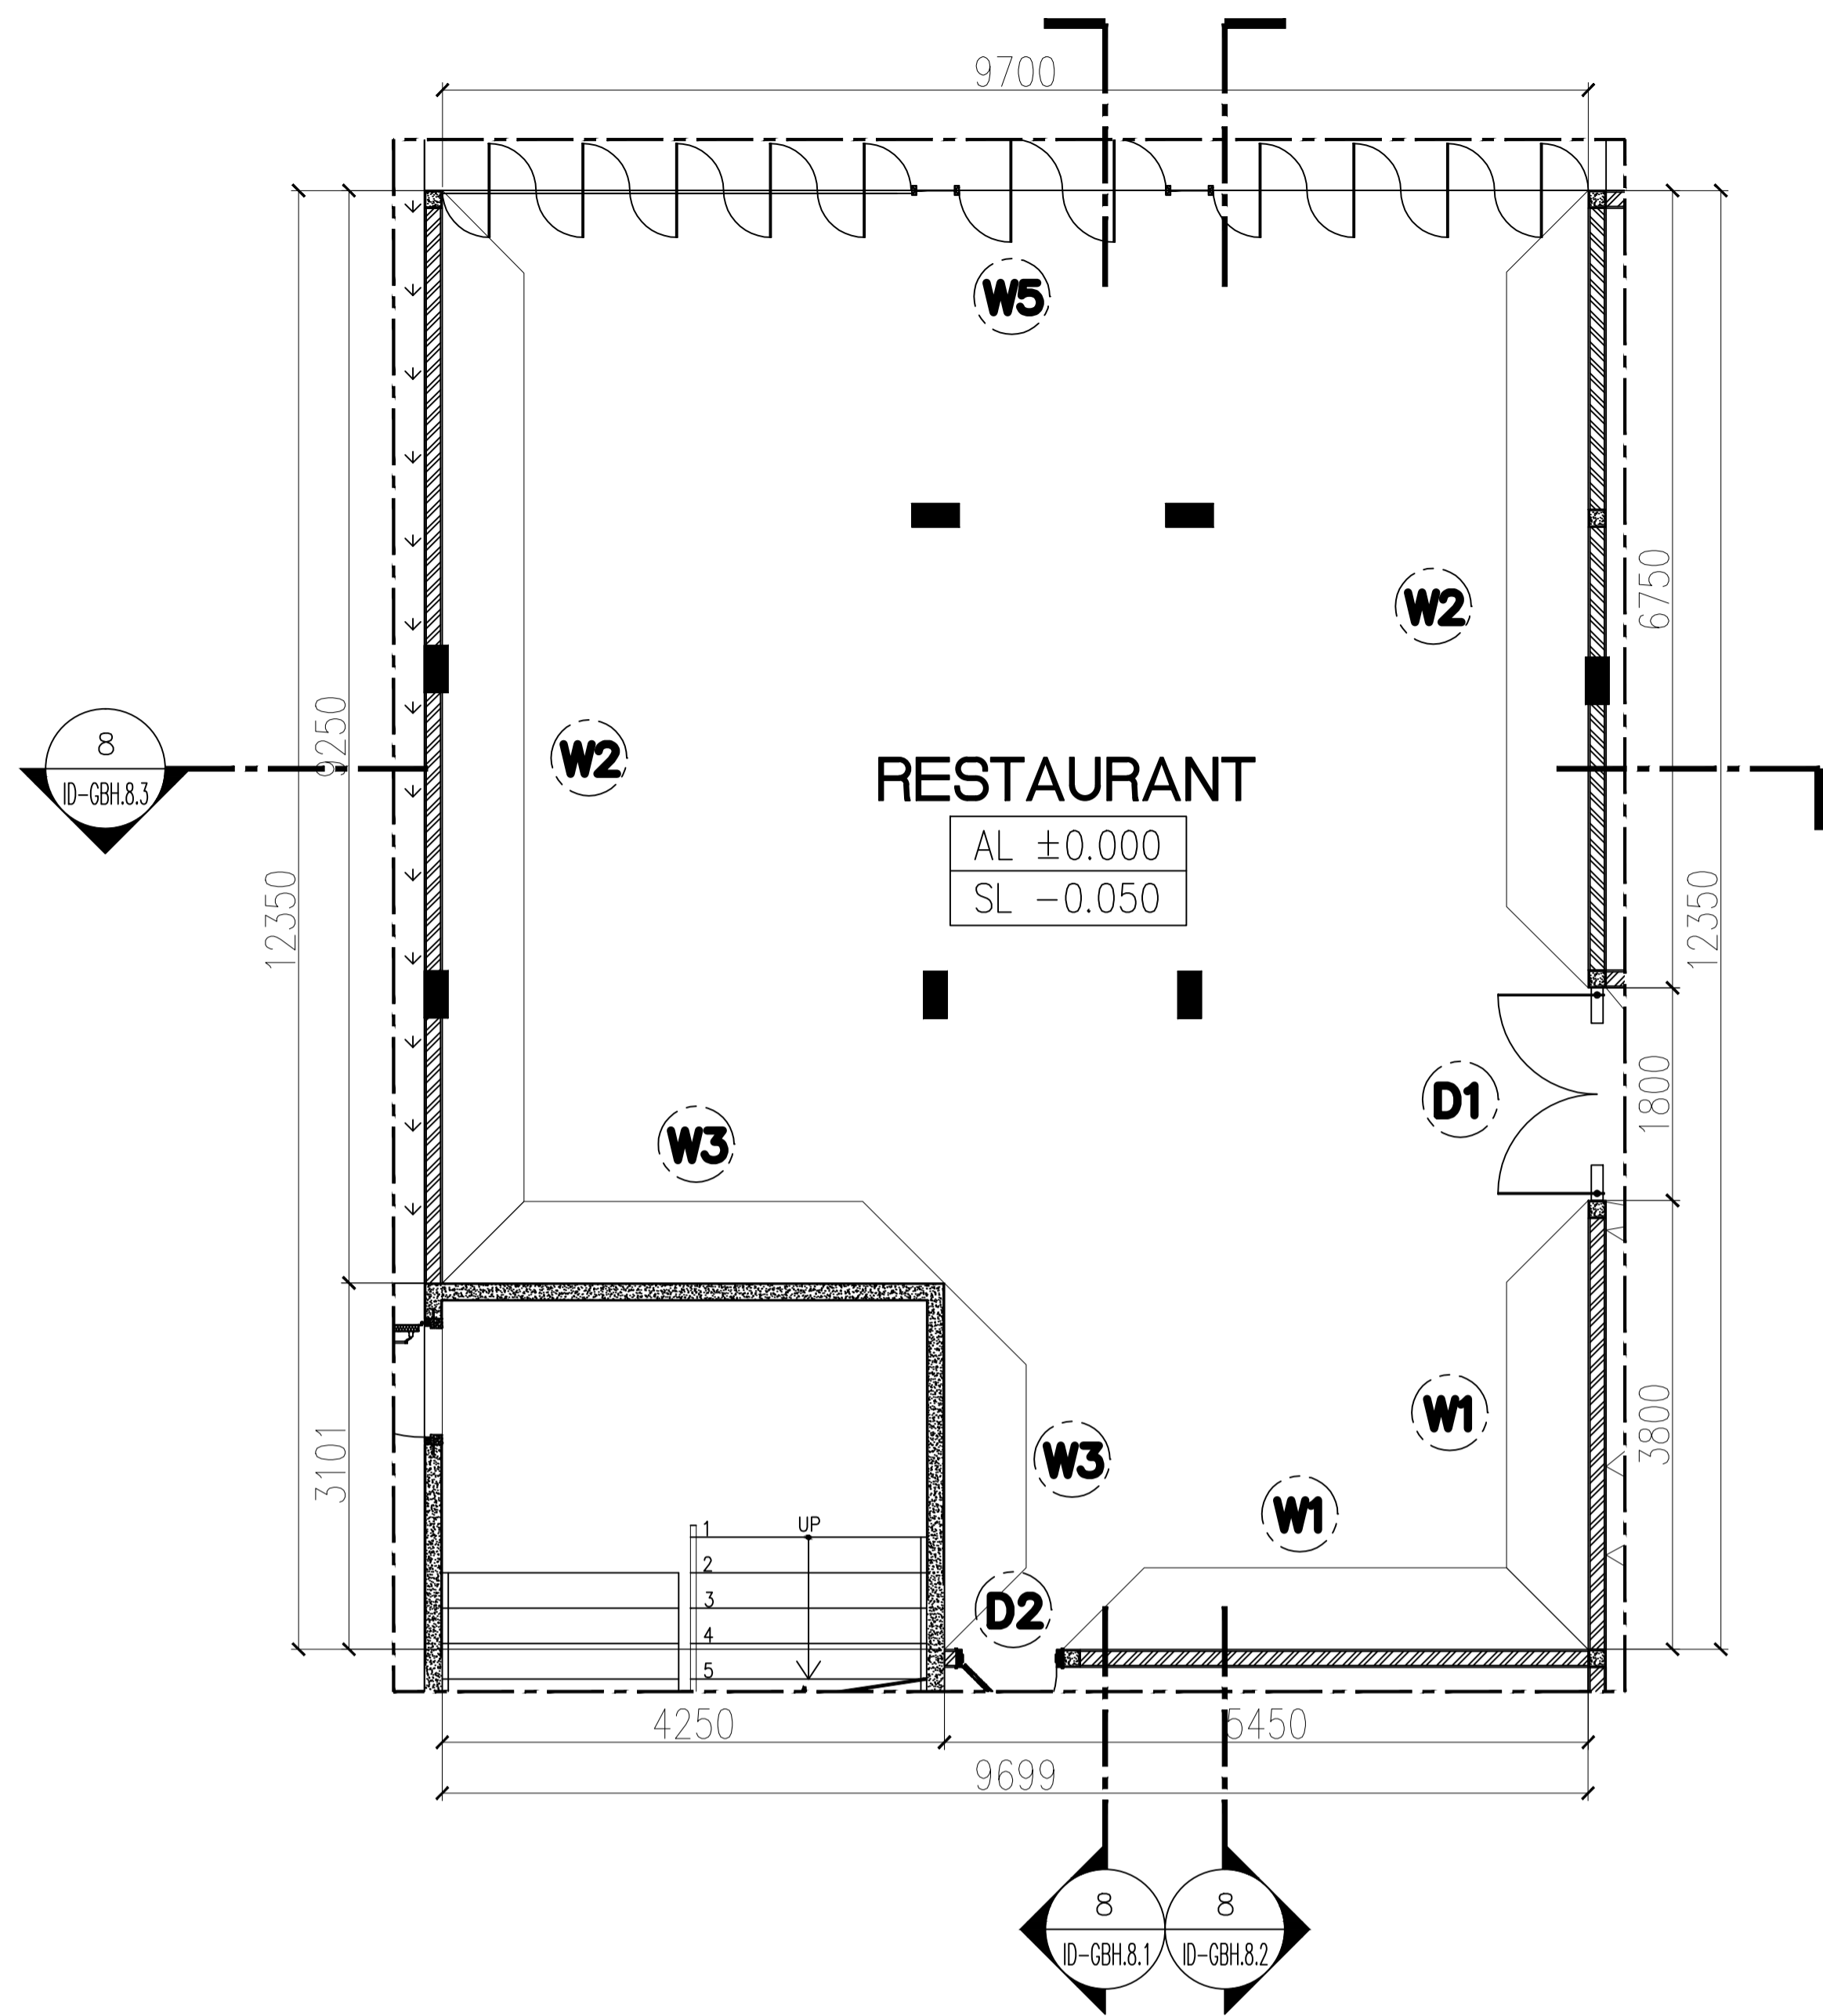

7
ID-GHB.7.0
GROUND FLOOR
WALL TREATMENT PLAN
SCALE 1:50

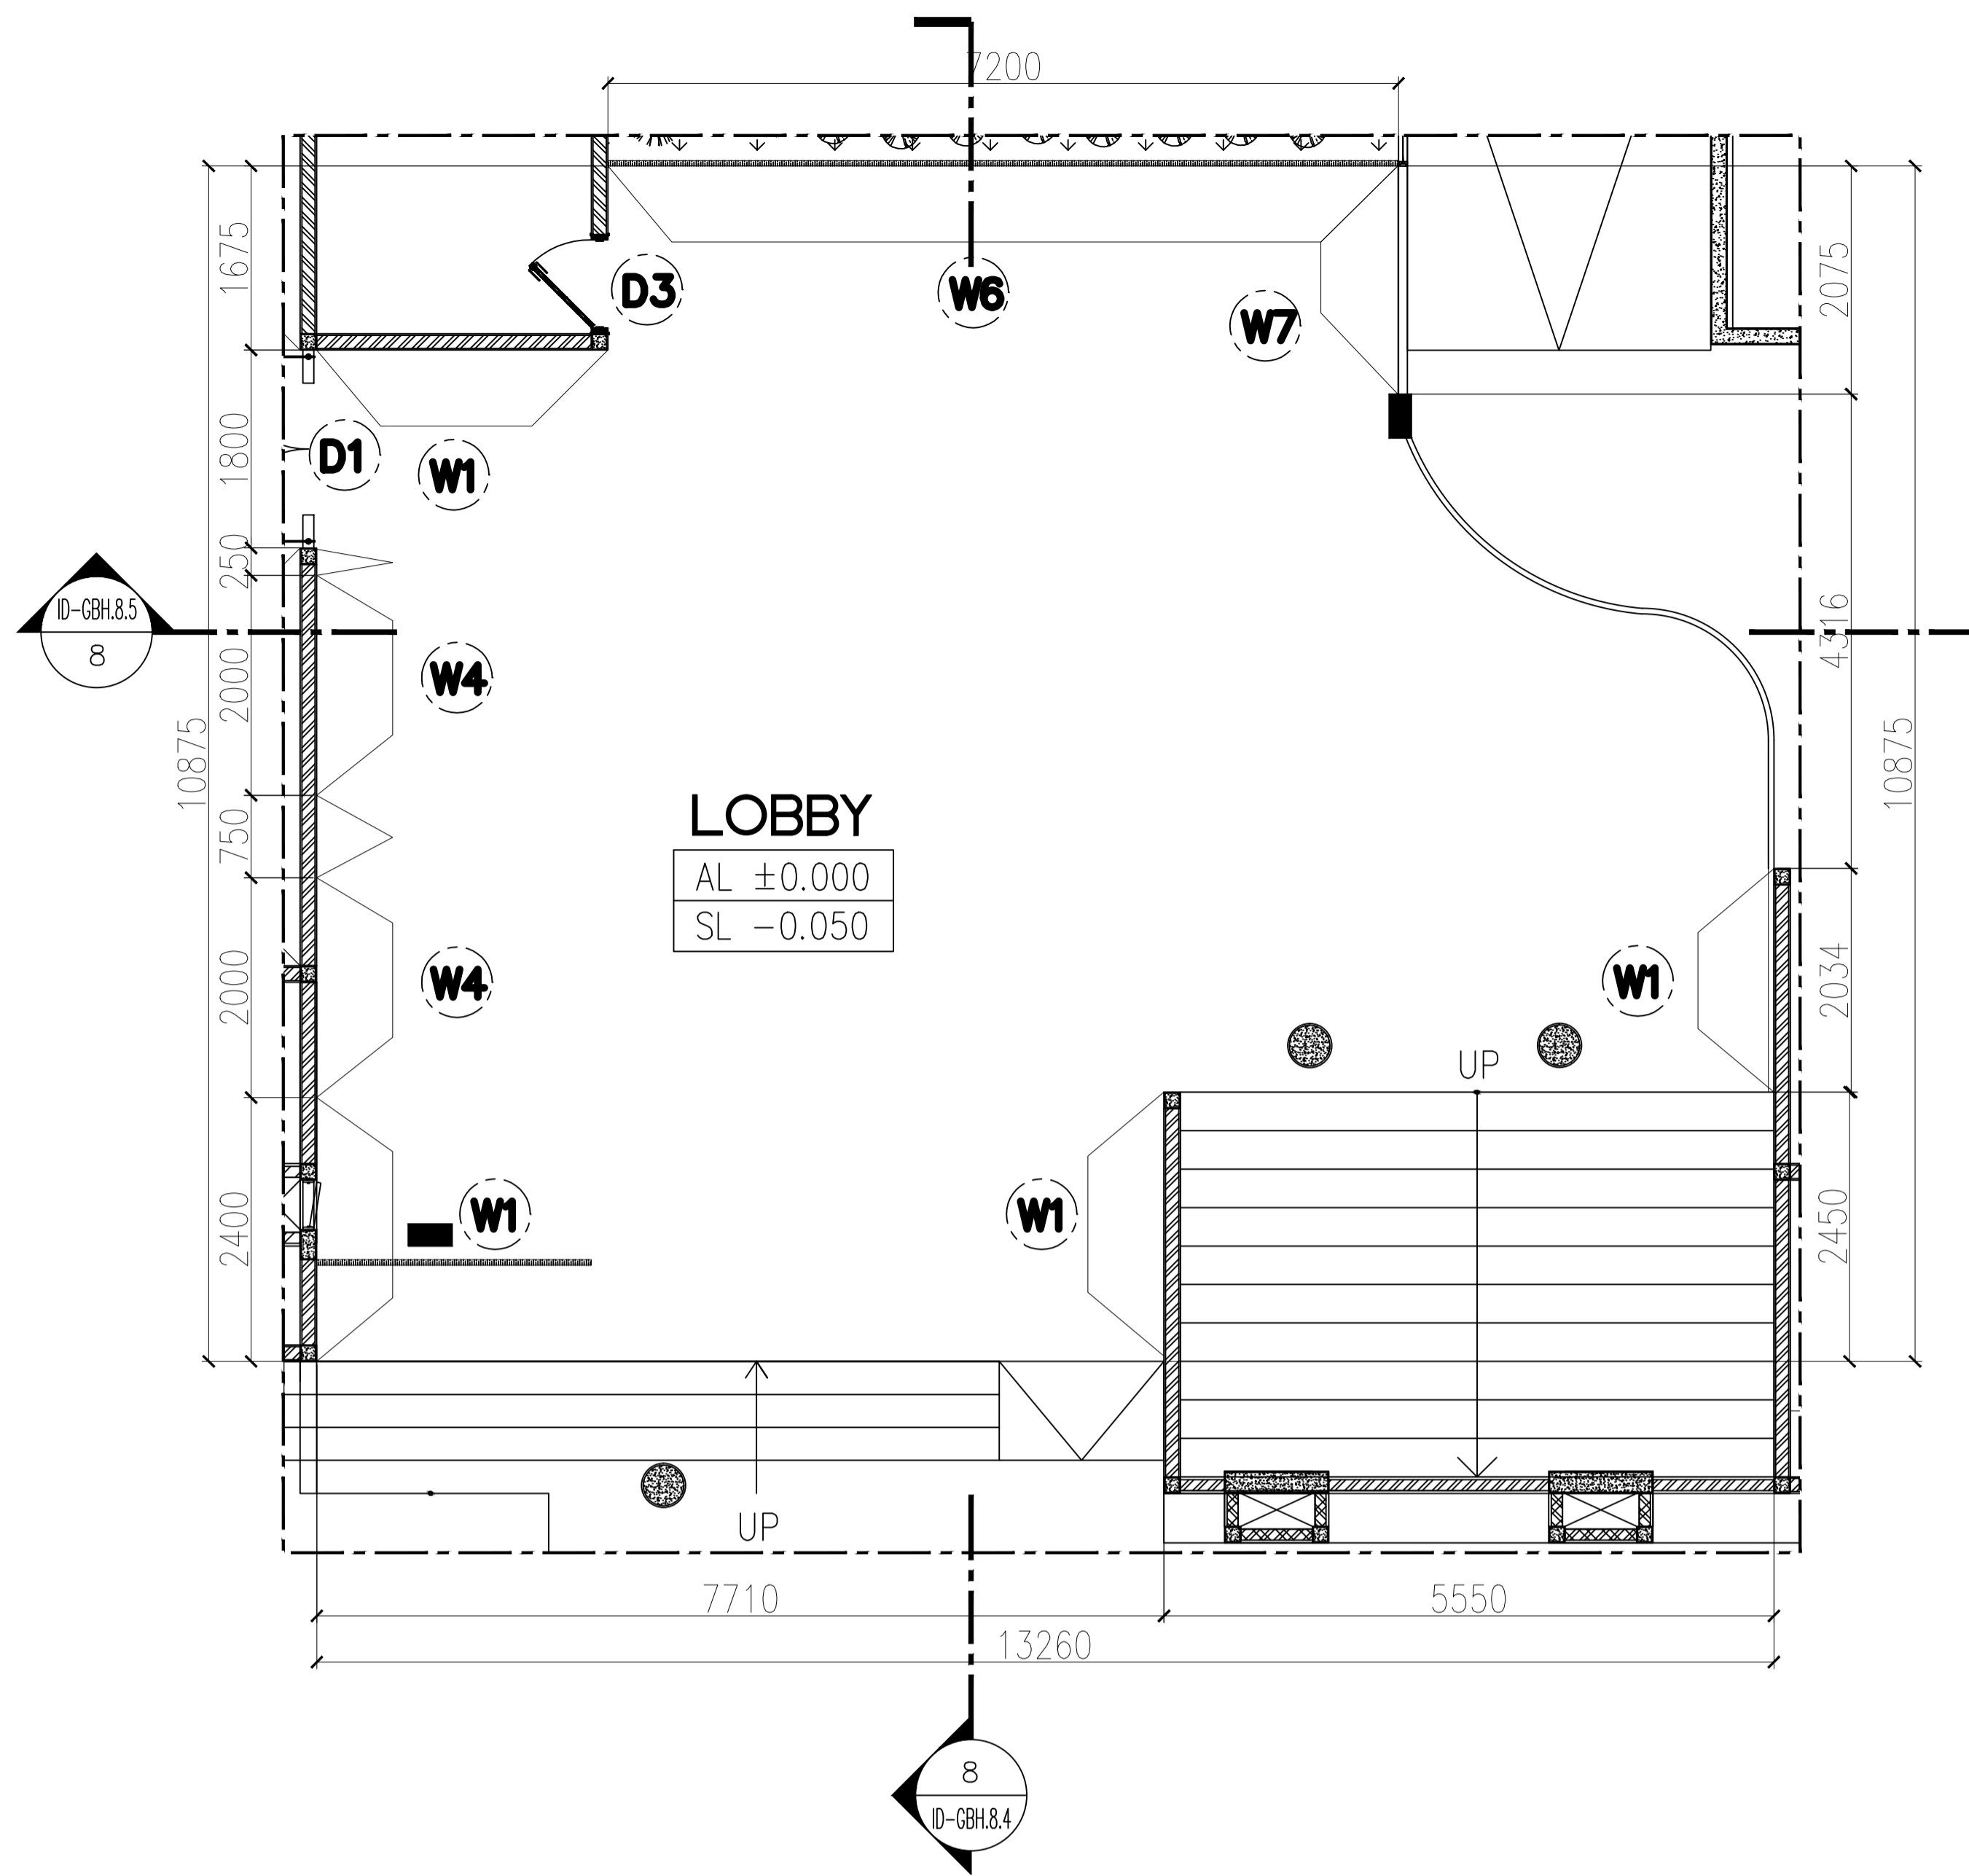


7
ID-GHB.7.1
GROUND FLOOR
WALL TREATMENT PLAN
SCALE 1:50

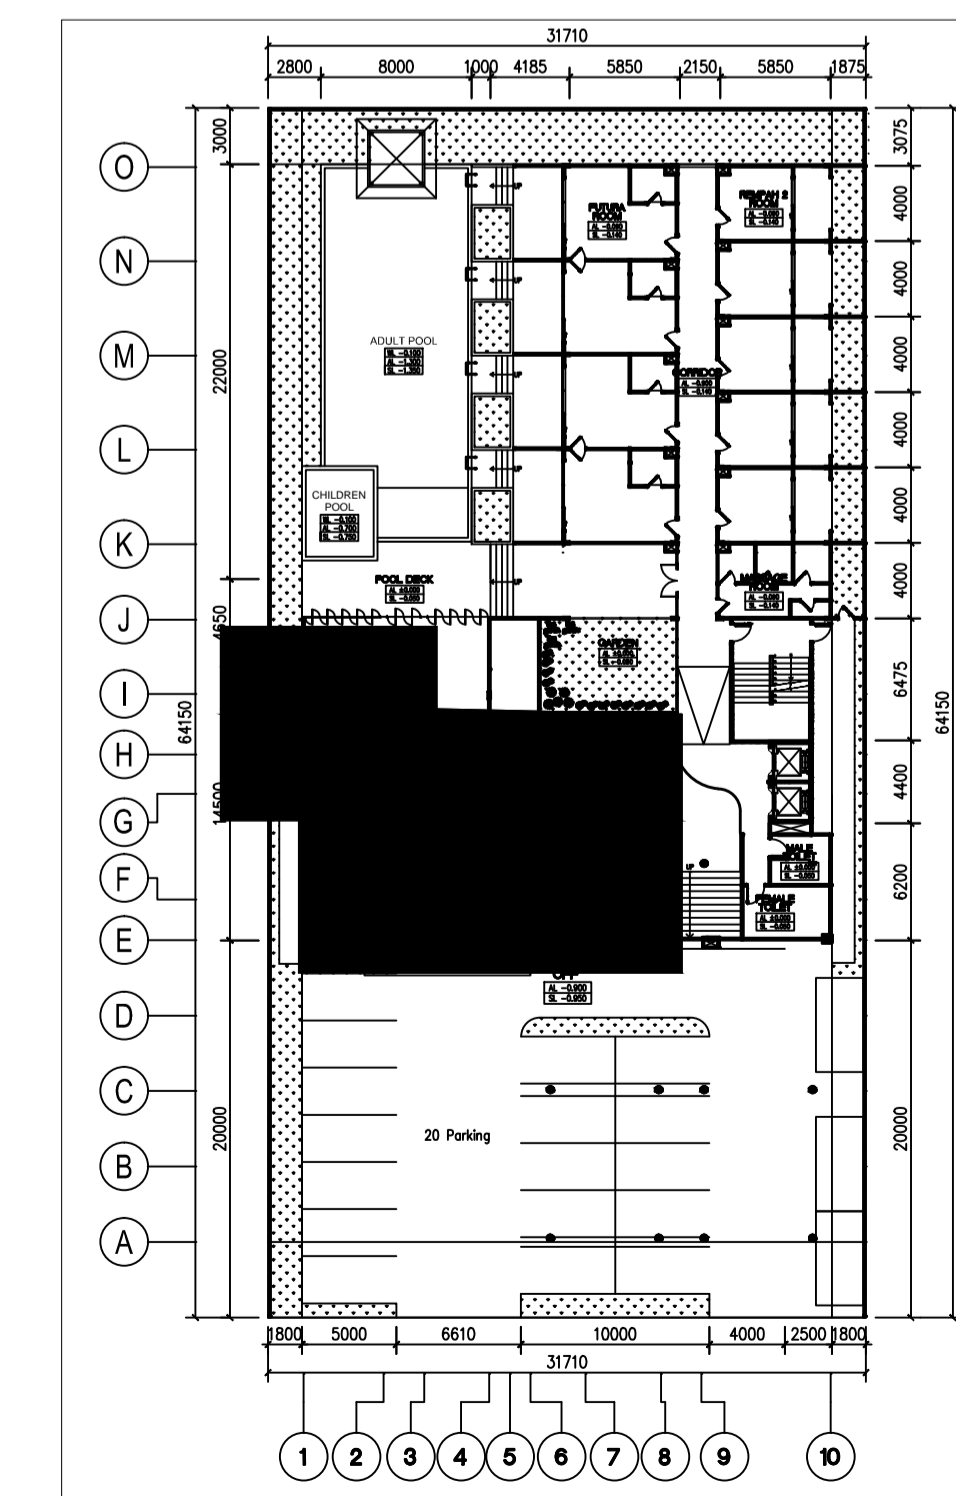

LEGEND

- W1 : PLESTER HALUS FIN. EPOXY CLEAR
- W2 : KAYU PALET FIN. PLITUR COKLAT
- W3 : ARTWORK KENDI SUSUN
- W4 : ARTWORK BATANG KAYU
- W5 : JENDELA FRAMLES FIN. DUCO BLACK
- W6 : PARTISI BESI MOTIF BATIK KAWUNG FIN. DUCO GOLD
- W7 : PAGAR TRALIS FIN. DUCO BLACK

- D1 : PINTU GEBYOK JEPARA
- D2 : PINTU KITCHEN RESTORAN
- D3 : PINTU KAYU BACK OFFICE HOTEL

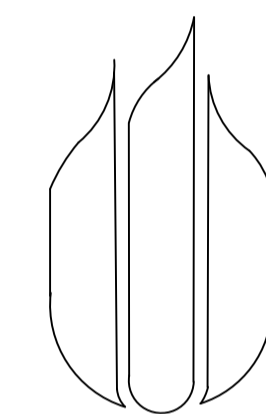

UNIVERSITAS
MERCU BUANA

NAMA PROYEK :

PERANCANGAN INTERIOR
GREENHOST BOUTIQUE HOTEL

JUDUL GAMBAR :

WALL TREATMENT PLAN LT. GROUND
(RESTAURANT & RECEPTIONIST)

NAMA :

FARID FADILAH

NIM :

41714010020

DOSEN PEMBIMBING :

YOHANES NUGROHO UTOMO, Drs, M.Ds

SKALA : 1 : 50


JUMLAH GAMBAR : NOMOR GAMBAR :

13/21

ID-GBH.7.0
ID-GBH.7.1


NILAI :

PARAF :

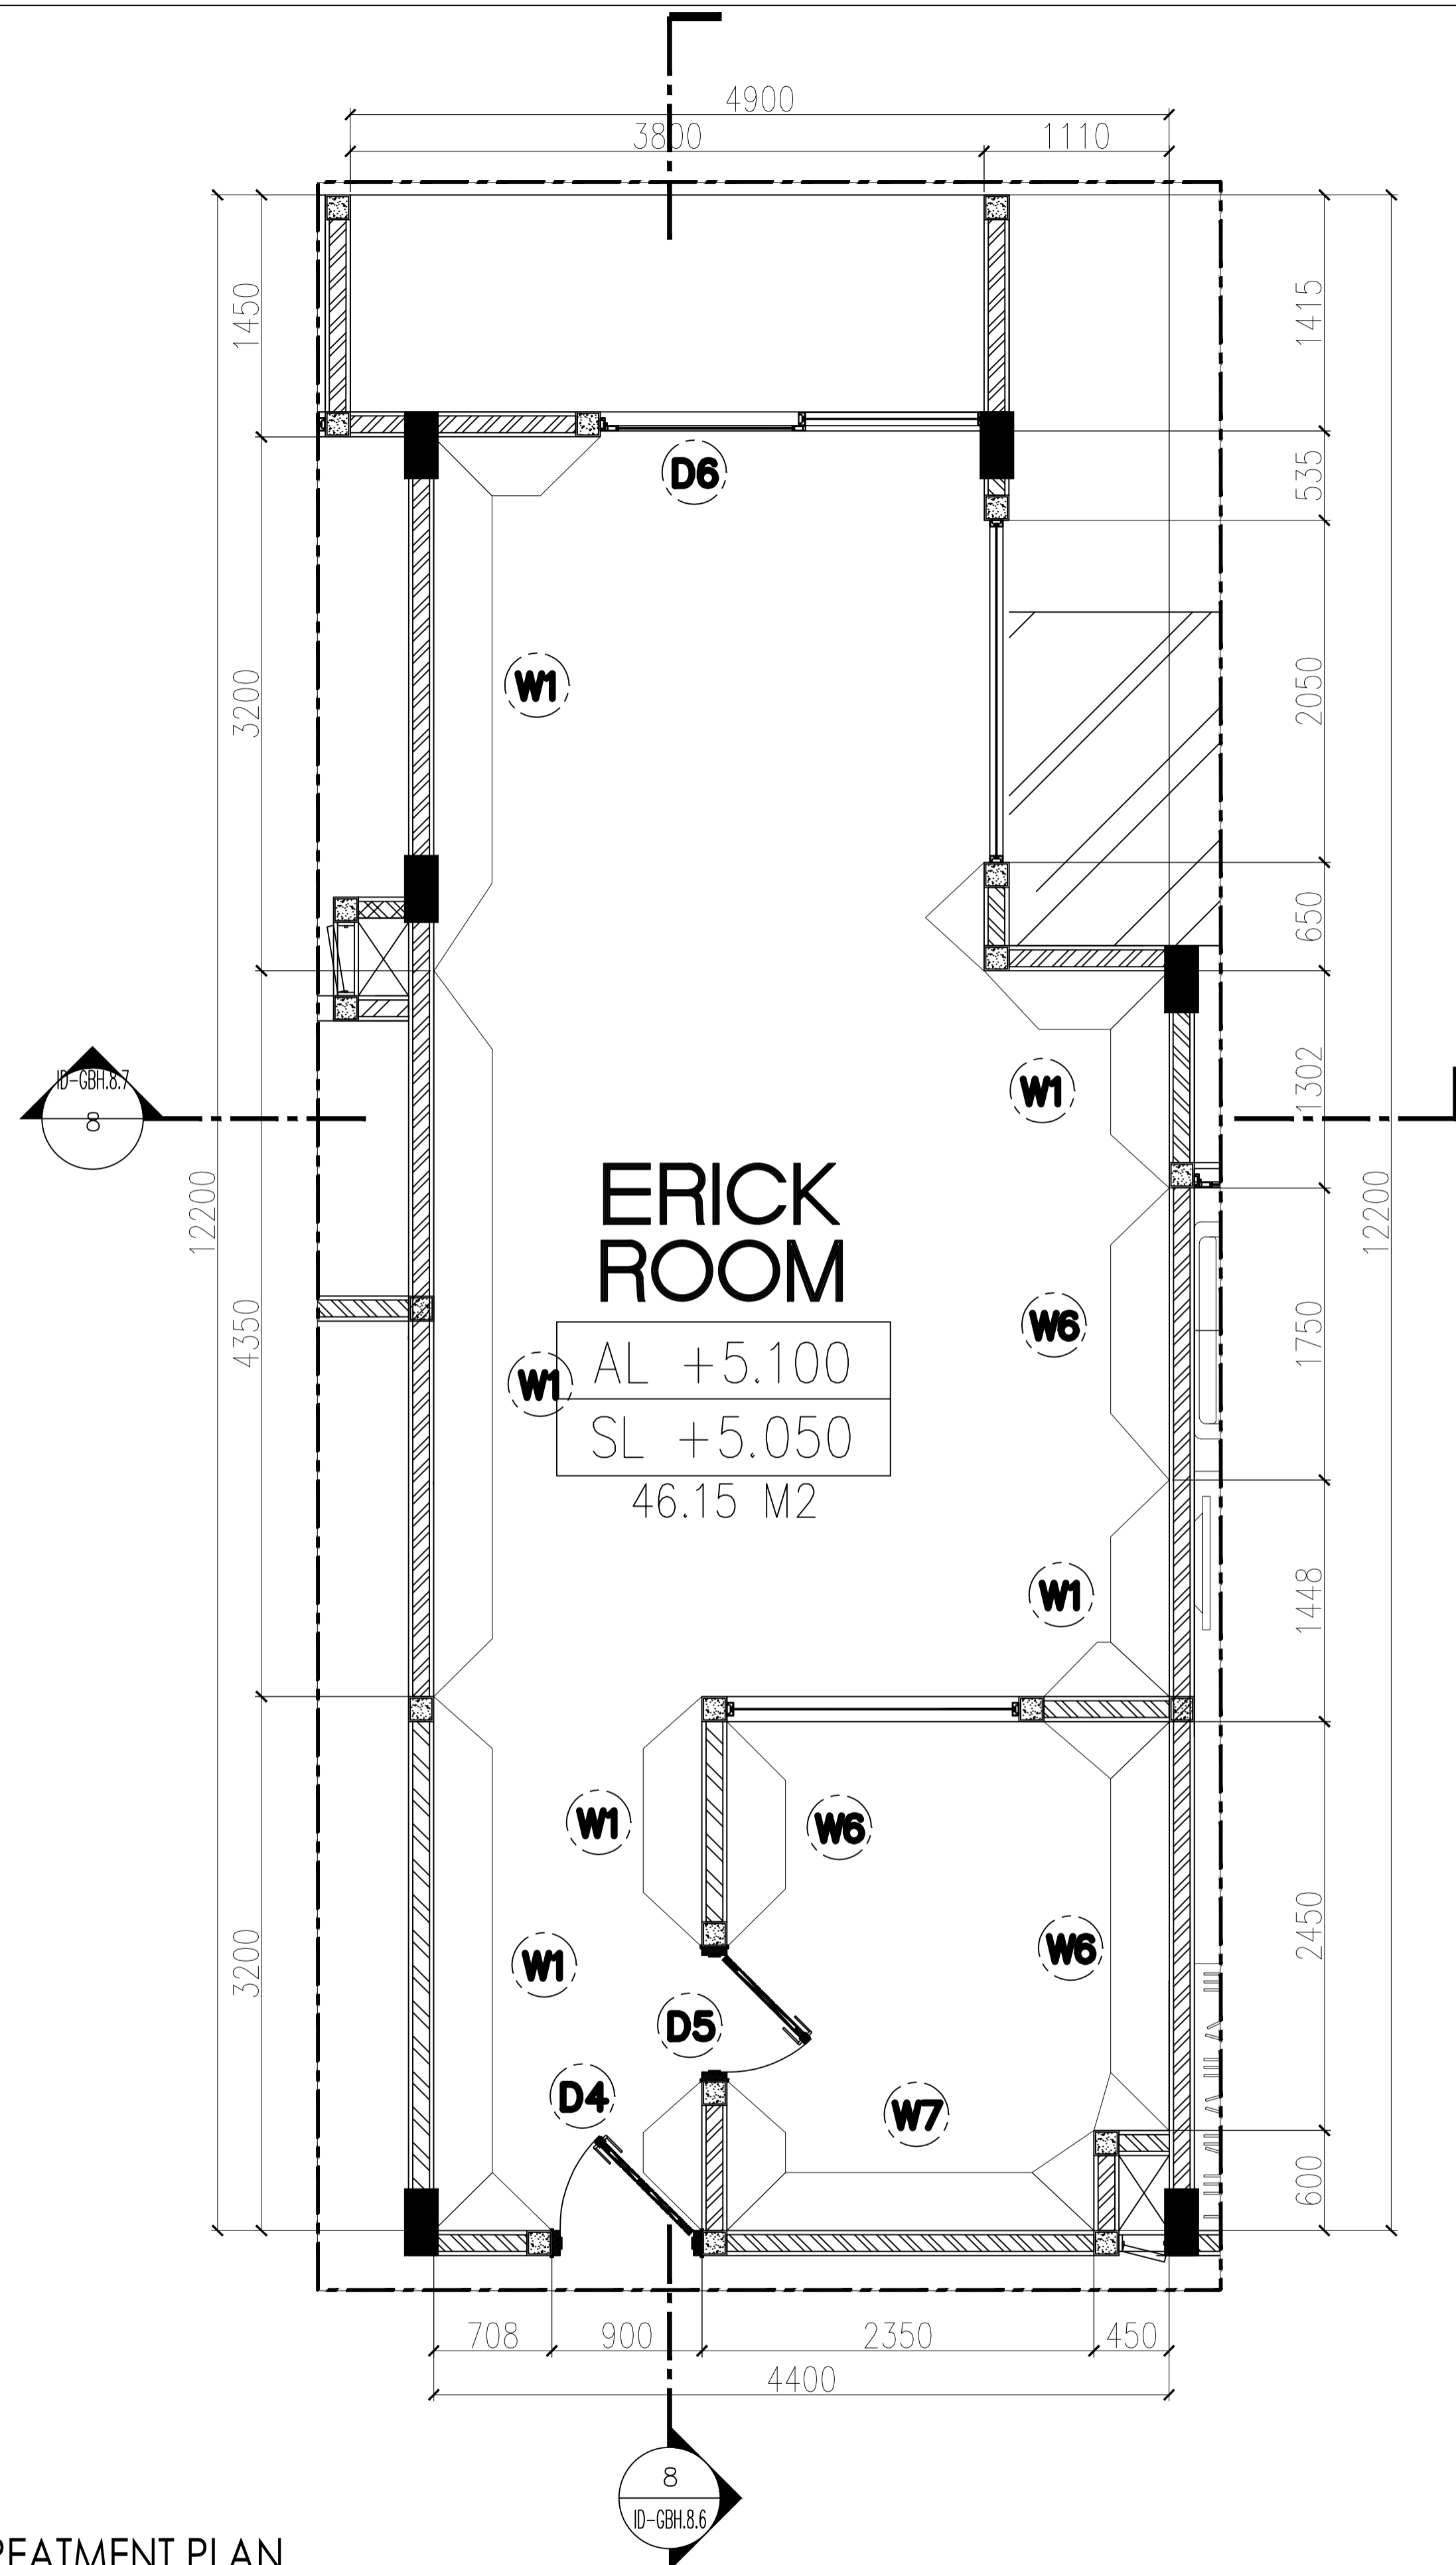


7
ID-GHB.7.2

THIRD FLOOR
WALL TREATMENT PLAN
SCALE 1:30

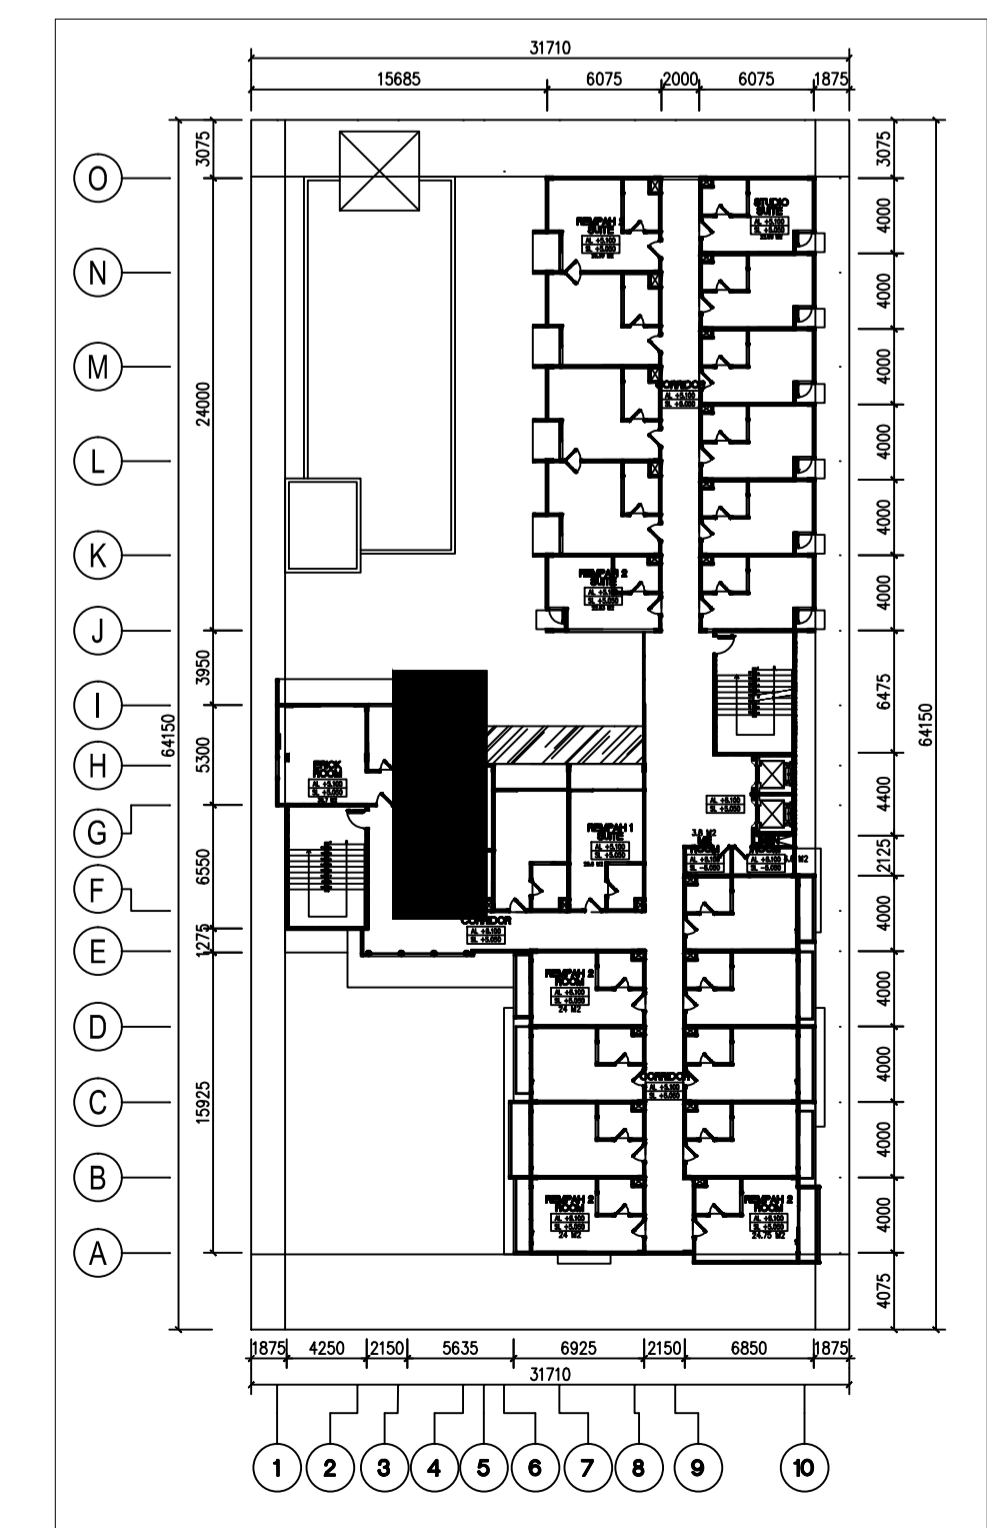

LEGEND	
W1	: PLESTER HALUS FIN. EPOXY CLEAR
W2	: KAYU PALET FIN. PLITUR COKLAT
W3	: ARTWORK KENDI SUSUN
W4	: ARTWORK BATANG KAYU
W5	: JENDELA FRAMLES FIN. DUCO BLACK
W6	: PARTISI BESI MOTIF BATIK KAWUNG FIN. DUCO GOLD
W7	: PAGAR TRALIS FIN. DUCO BLACK
W8	: ARTWORK PINTU GEBYOK
W9	: KACA FRAMLES FIN DUCO.BLACK
D1	: PINTU GEBYOK JEPARA
D2	: PINTU KITCHEN RESTORAN
D3	: PINTU KAYU BACK OFFICE HOTEL
D4	: PINTU KAMAR KAYU PALET
D5	: PINTU KAMAR MANDI
D6	: SLINDING DOOR KACA FRAMLES BALKON KAMAR
 UNIVERSITAS MERCU BUANA	
NAMA PROYEK :	
PERANCANGAN INTERIOR GREENHOST BOUTIQUE HOTEL	
JUDUL GAMBAR :	
WALL TREATMENT PLAN LT. TIGA (ERICK ROOM)	
NAMA :	
FARID FADILAH	
NIM :	
41714010020	
DOSEN PEMBIMBING :	
YOHANES NUGROHO UTOMO, Drs, M.Ds	
SKALA :	1 : 30
JUMLAH GAMBAR :	NOMOR GAMBAR :
14/21	ID-GBH.7.2
NILAI :	PARAF :

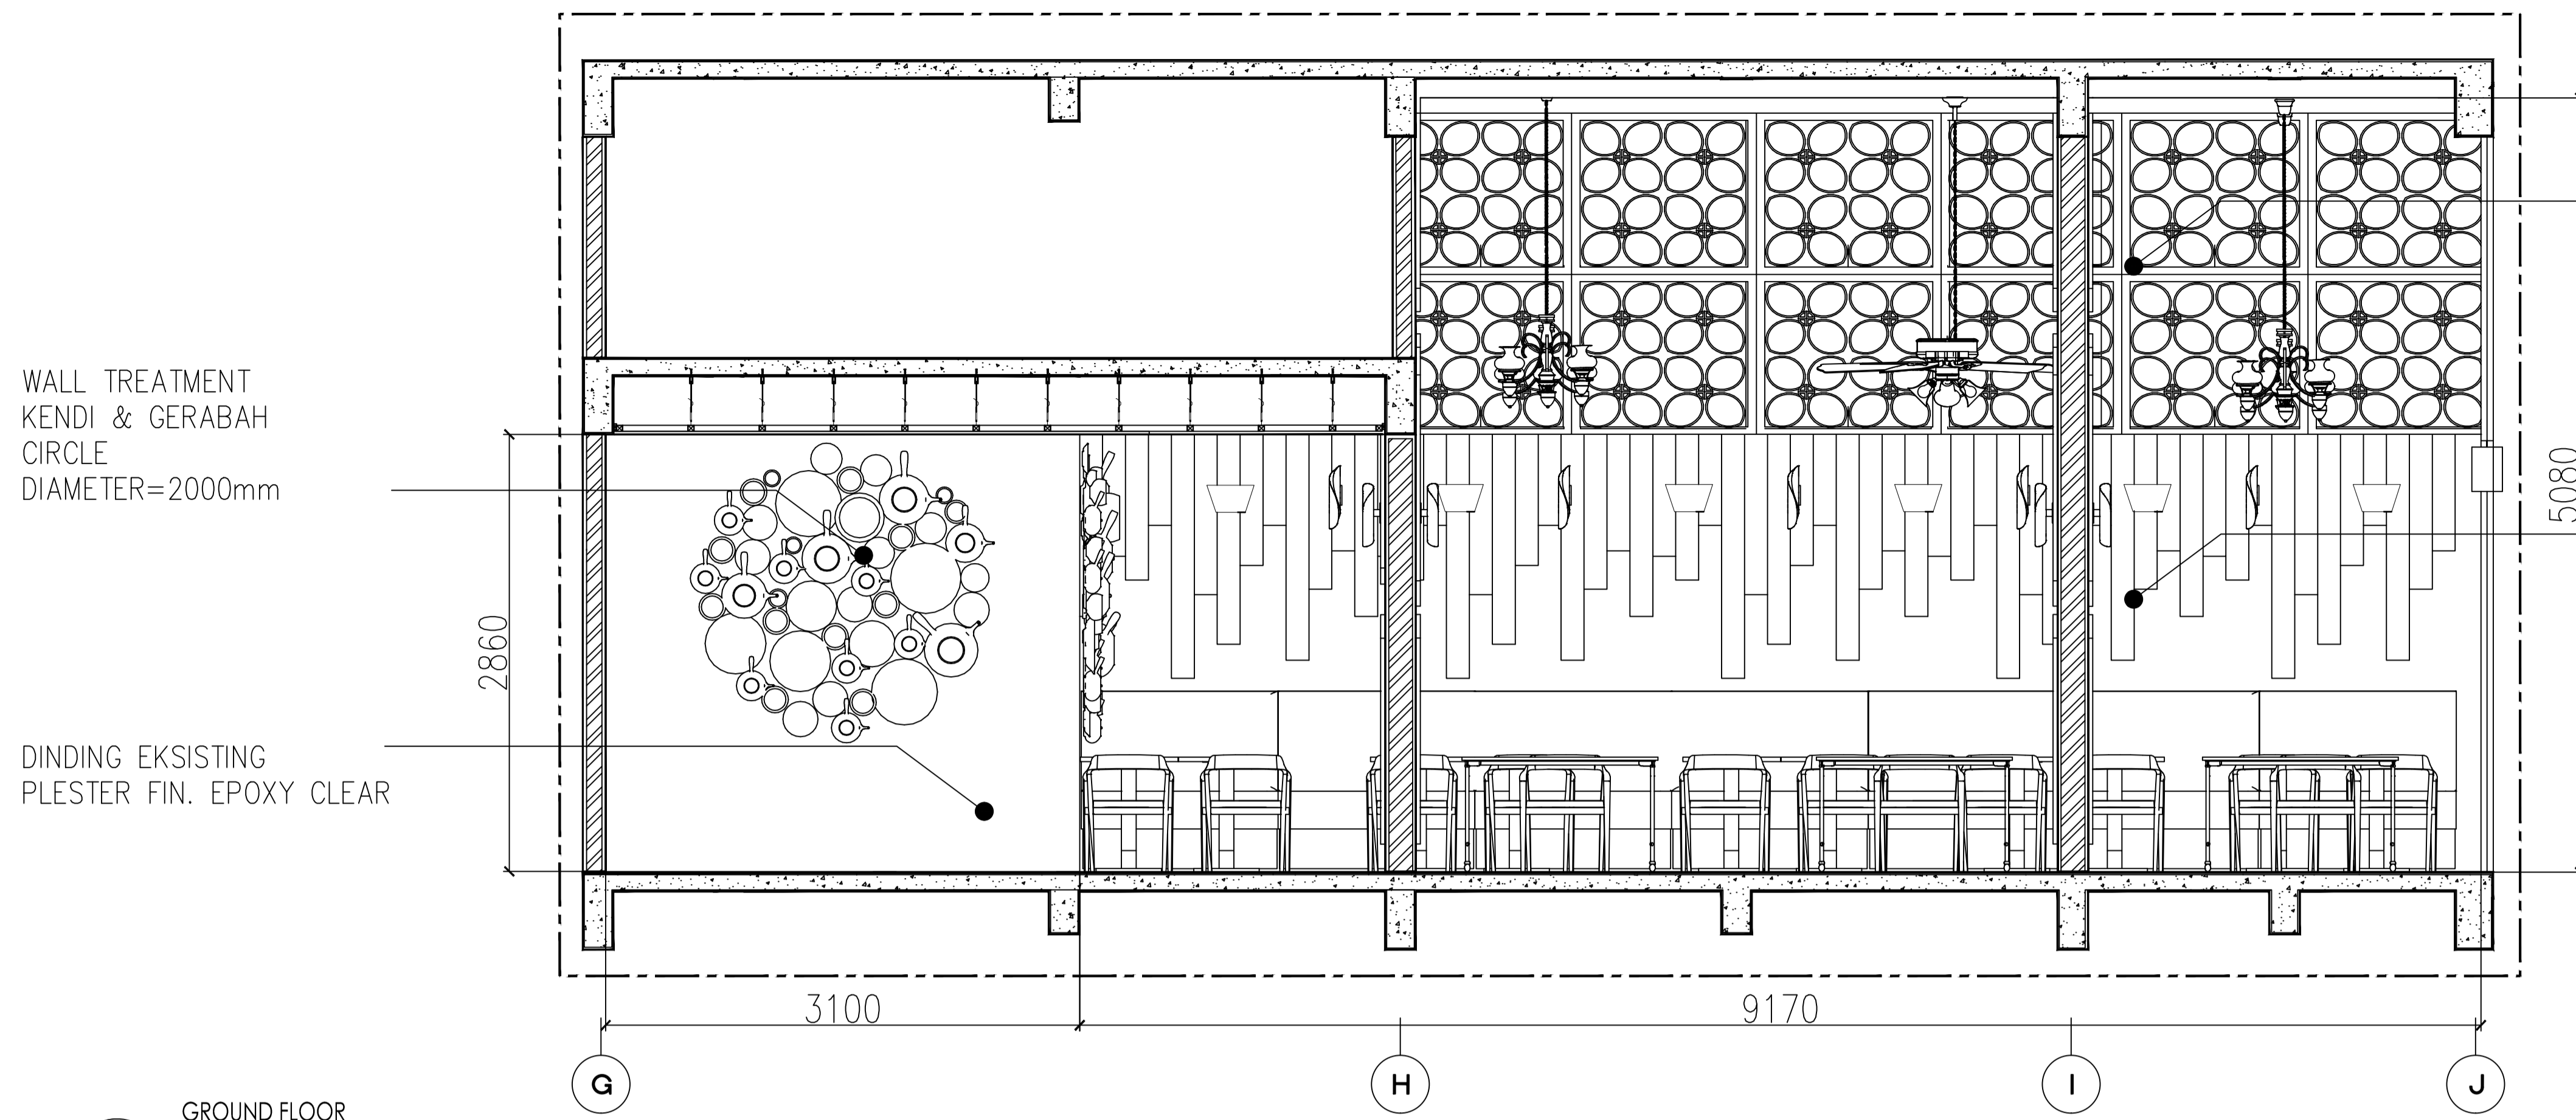


WALL TREATMENT
KENDI & GERABAH
CIRCLE
DIAMETER=2000mm

DINDING EKSTING
PLESTER FIN. EPOXY CLEAR

DINDING EKSTING
BESI CUTTING
MOTIF BATIK KAWUNG
960x960mm
FIN. COATING GOLD T=10mm

DINDING EKSTING
KAYU PALET FIN. PLITUR CLEAR
T=10mm

8
ID-GBH.8.0
GROUND FLOOR
POTONGAN A-A
SCALE 1:30

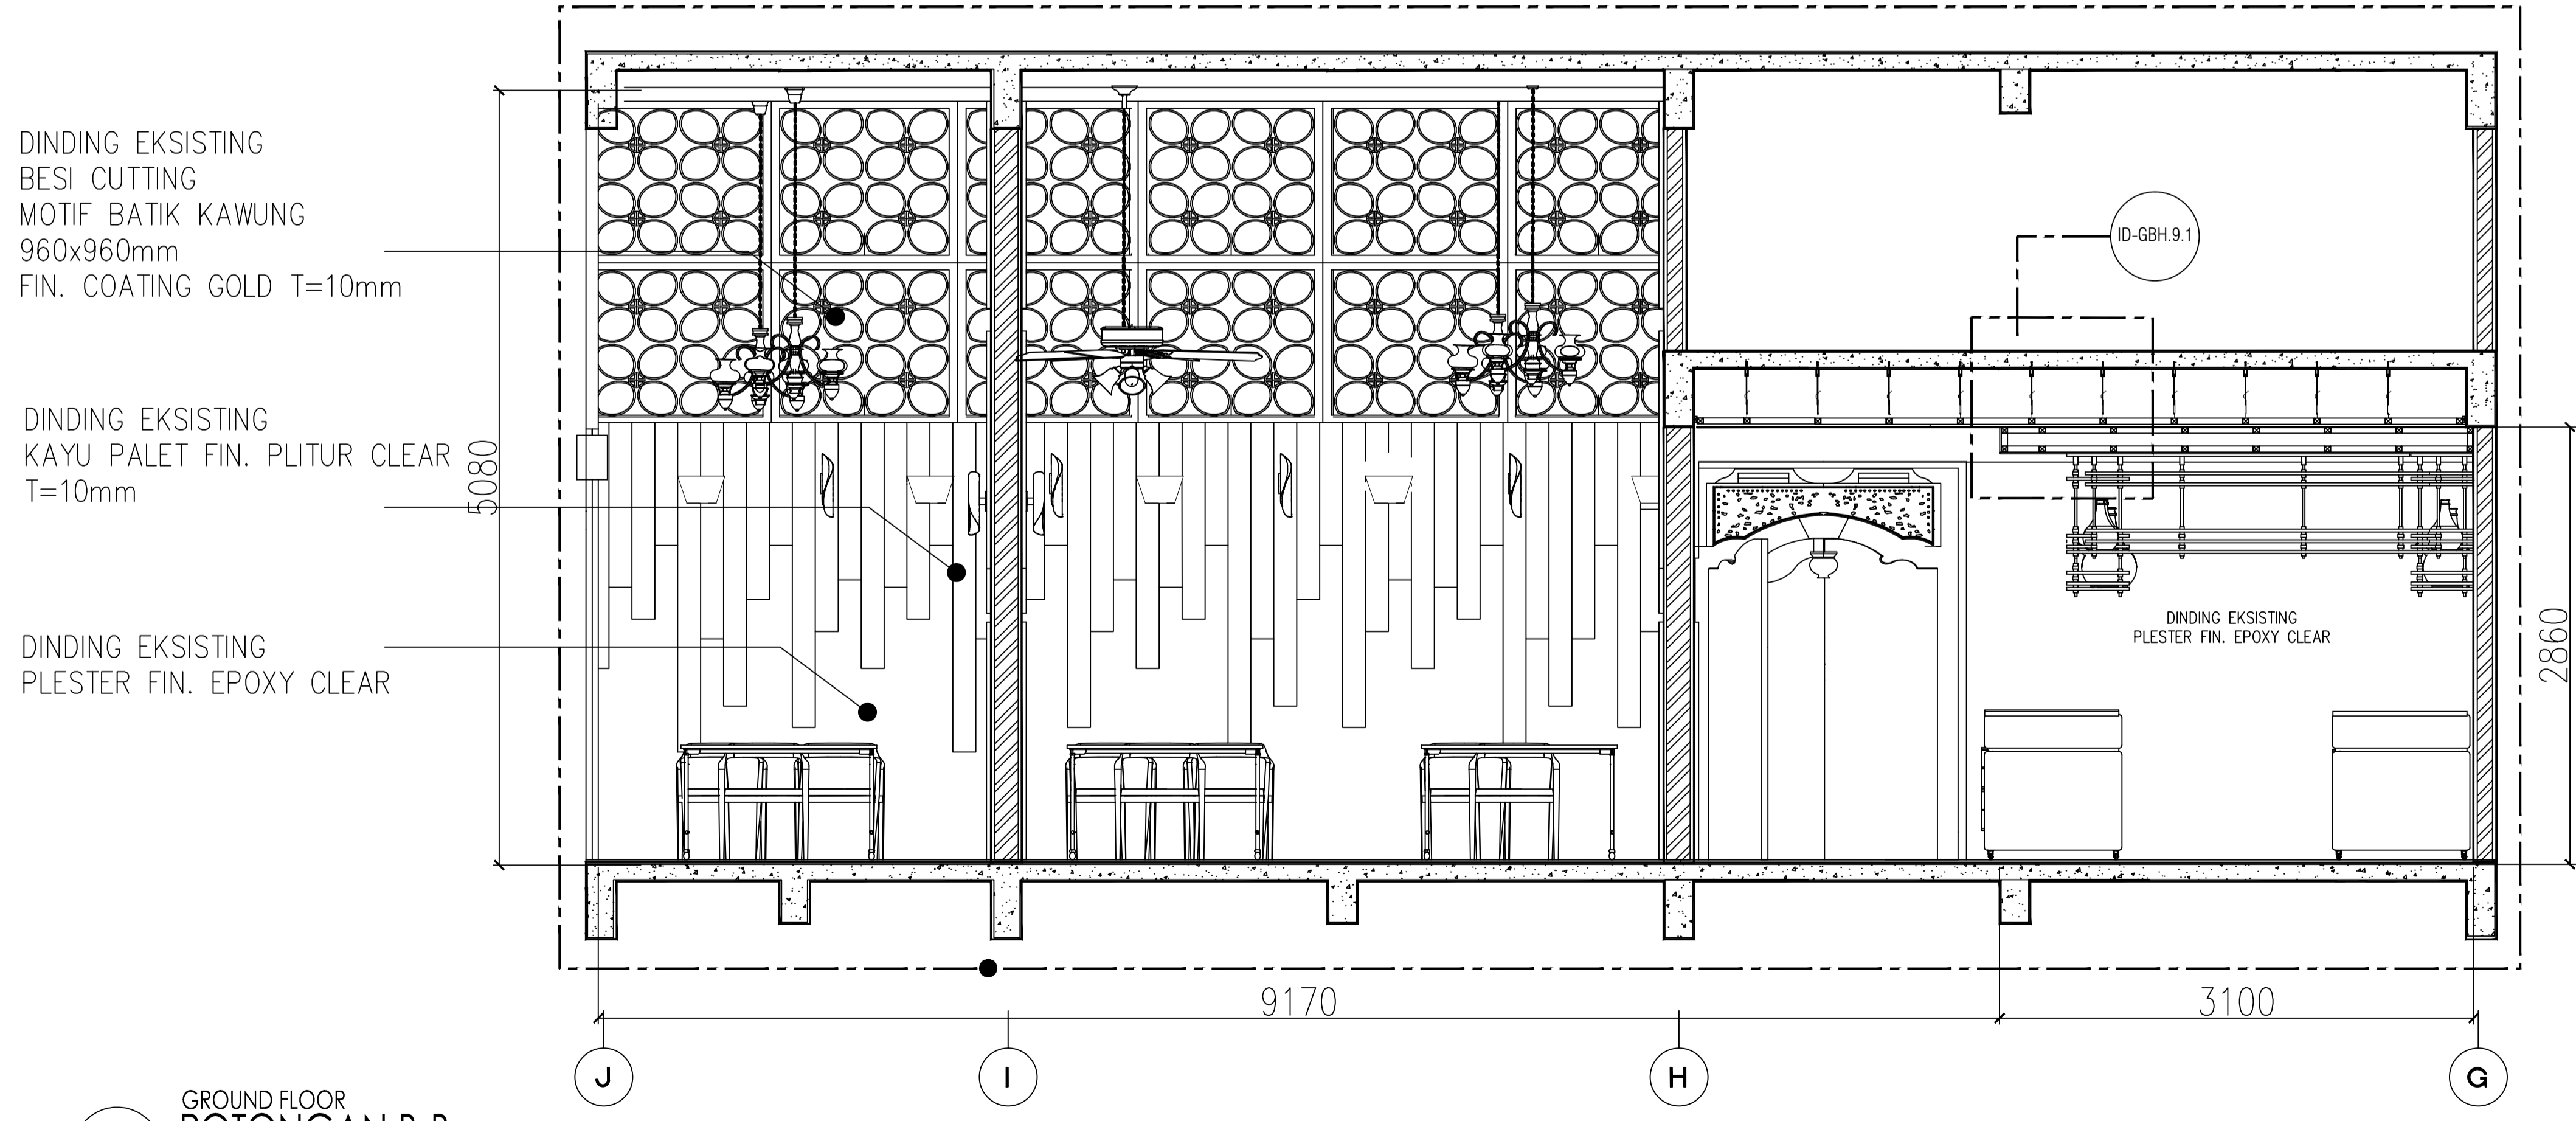

DINDING EKSTING
BESI CUTTING
MOTIF BATIK KAWUNG
960x960mm
FIN. COATING GOLD T=10mm

DINDING EKSTING
KAYU PALET FIN. PLITUR CLEAR
T=10mm


DINDING EKSTING
PLESTER FIN. EPOXY CLEAR

DINDING EKSTING
PLESTER FIN. EPOXY CLEAR

ID-GBH.9.1

8
ID-GBH.8.1
GROUND FLOOR
POTONGAN B-B
SCALE 1:30

LEGEND

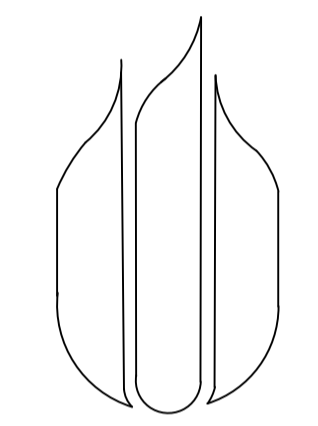

UNIVERSITAS
MERCU BUANA

NAMA PROYEK :

PERANCANGAN INTERIOR
GREENHOST BOUTIQUE HOTEL

JUDUL GAMBAR :

POTONGAN A-A & B-B LT. GROUND
(RESTAURANT AREA)

NAMA :

FARID FADILAH

NIM :

41714010020

DOSEN PEMBIMBING :

YOHANES NUGROHO UTOMO, Drs, M.Ds

SKALA : 1 : 30

JUMLAH GAMBAR : NOMOR GAMBAR :


16/21

ID-GBH.8.0
ID-GBH.8.1

NILAI :

PARAF :

LEGEND

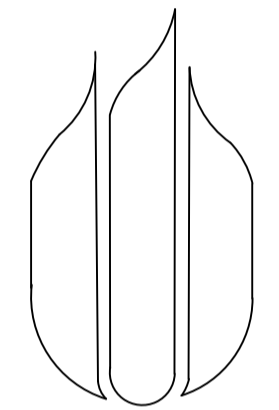

UNIVERSITAS
MERCU BUANA

NAMA PROYEK :

PERANCANGAN INTERIOR
GREENHOST BOUTIQUE HOTEL

JUDUL GAMBAR :

POTONGAN C-C & D-D LT. GROUND
(RESTAURANT & RECEPTIONIST AREA)

NAMA :

FARID FADILAH

NIM :

41714010020

DOSEN PEMBIMBING :

YOHANES NUGROHO UTOMO, Drs, M.Ds

SKALA : 1 : 30


JUMLAH GAMBAR : NOMOR GAMBAR :

17/21


ID-GBH.8.2
ID-GBH.8.3

NILAI :

PARAF :

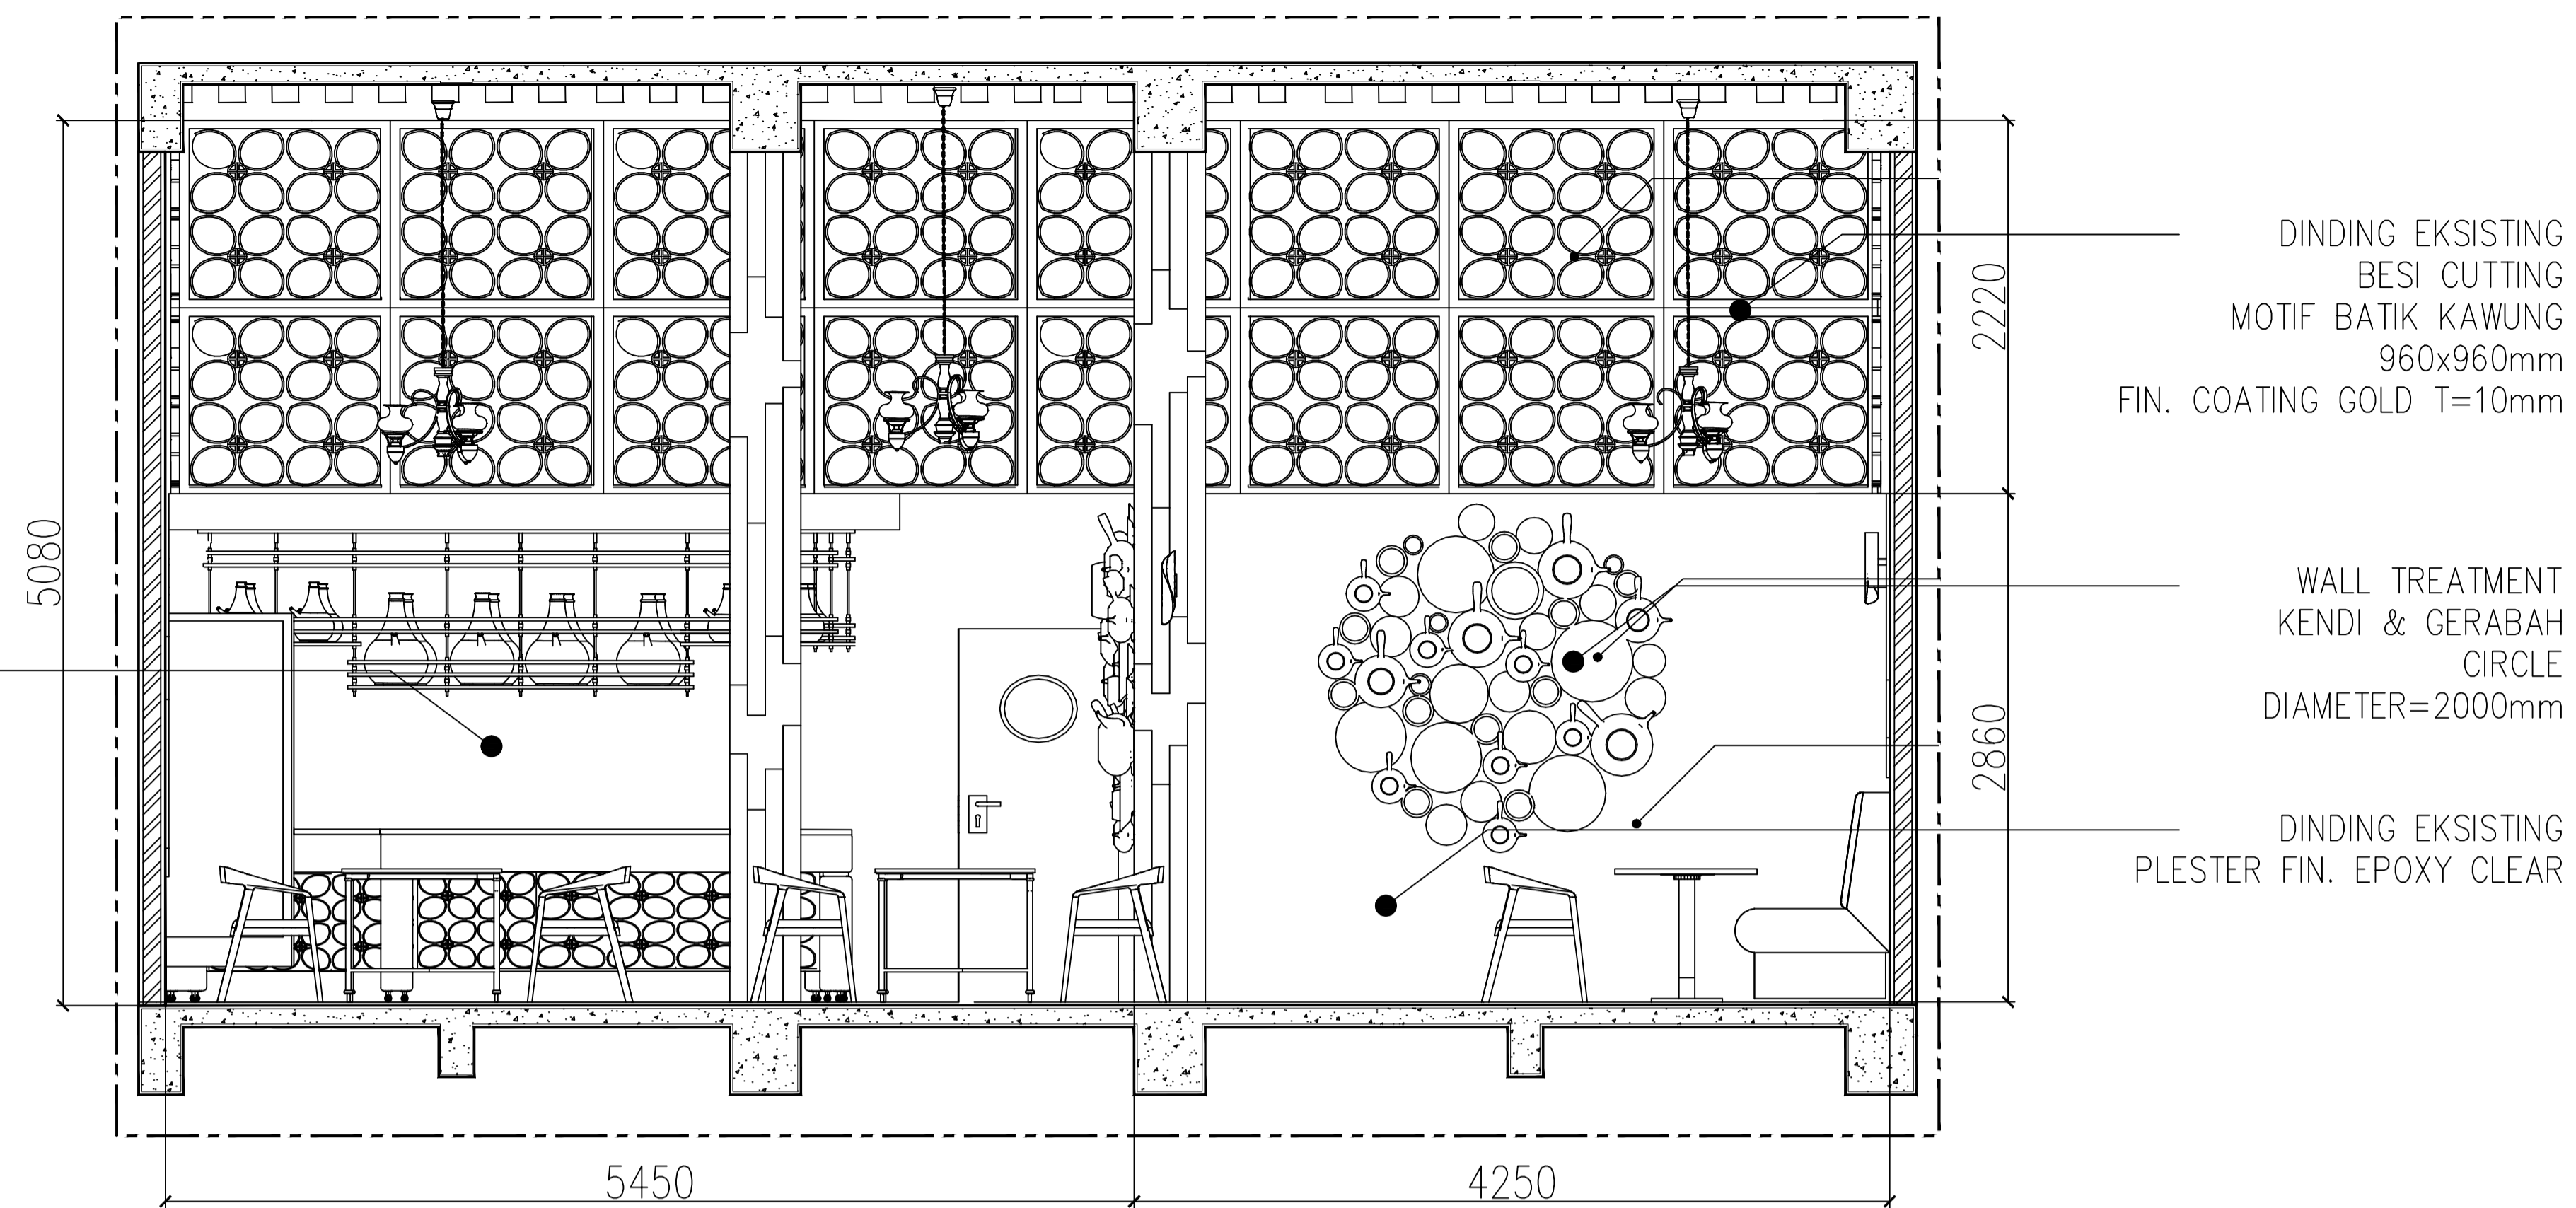

8
ID-GBH.8.2
GROUND FLOOR
POTONGAN C-C
SCALE 1:30

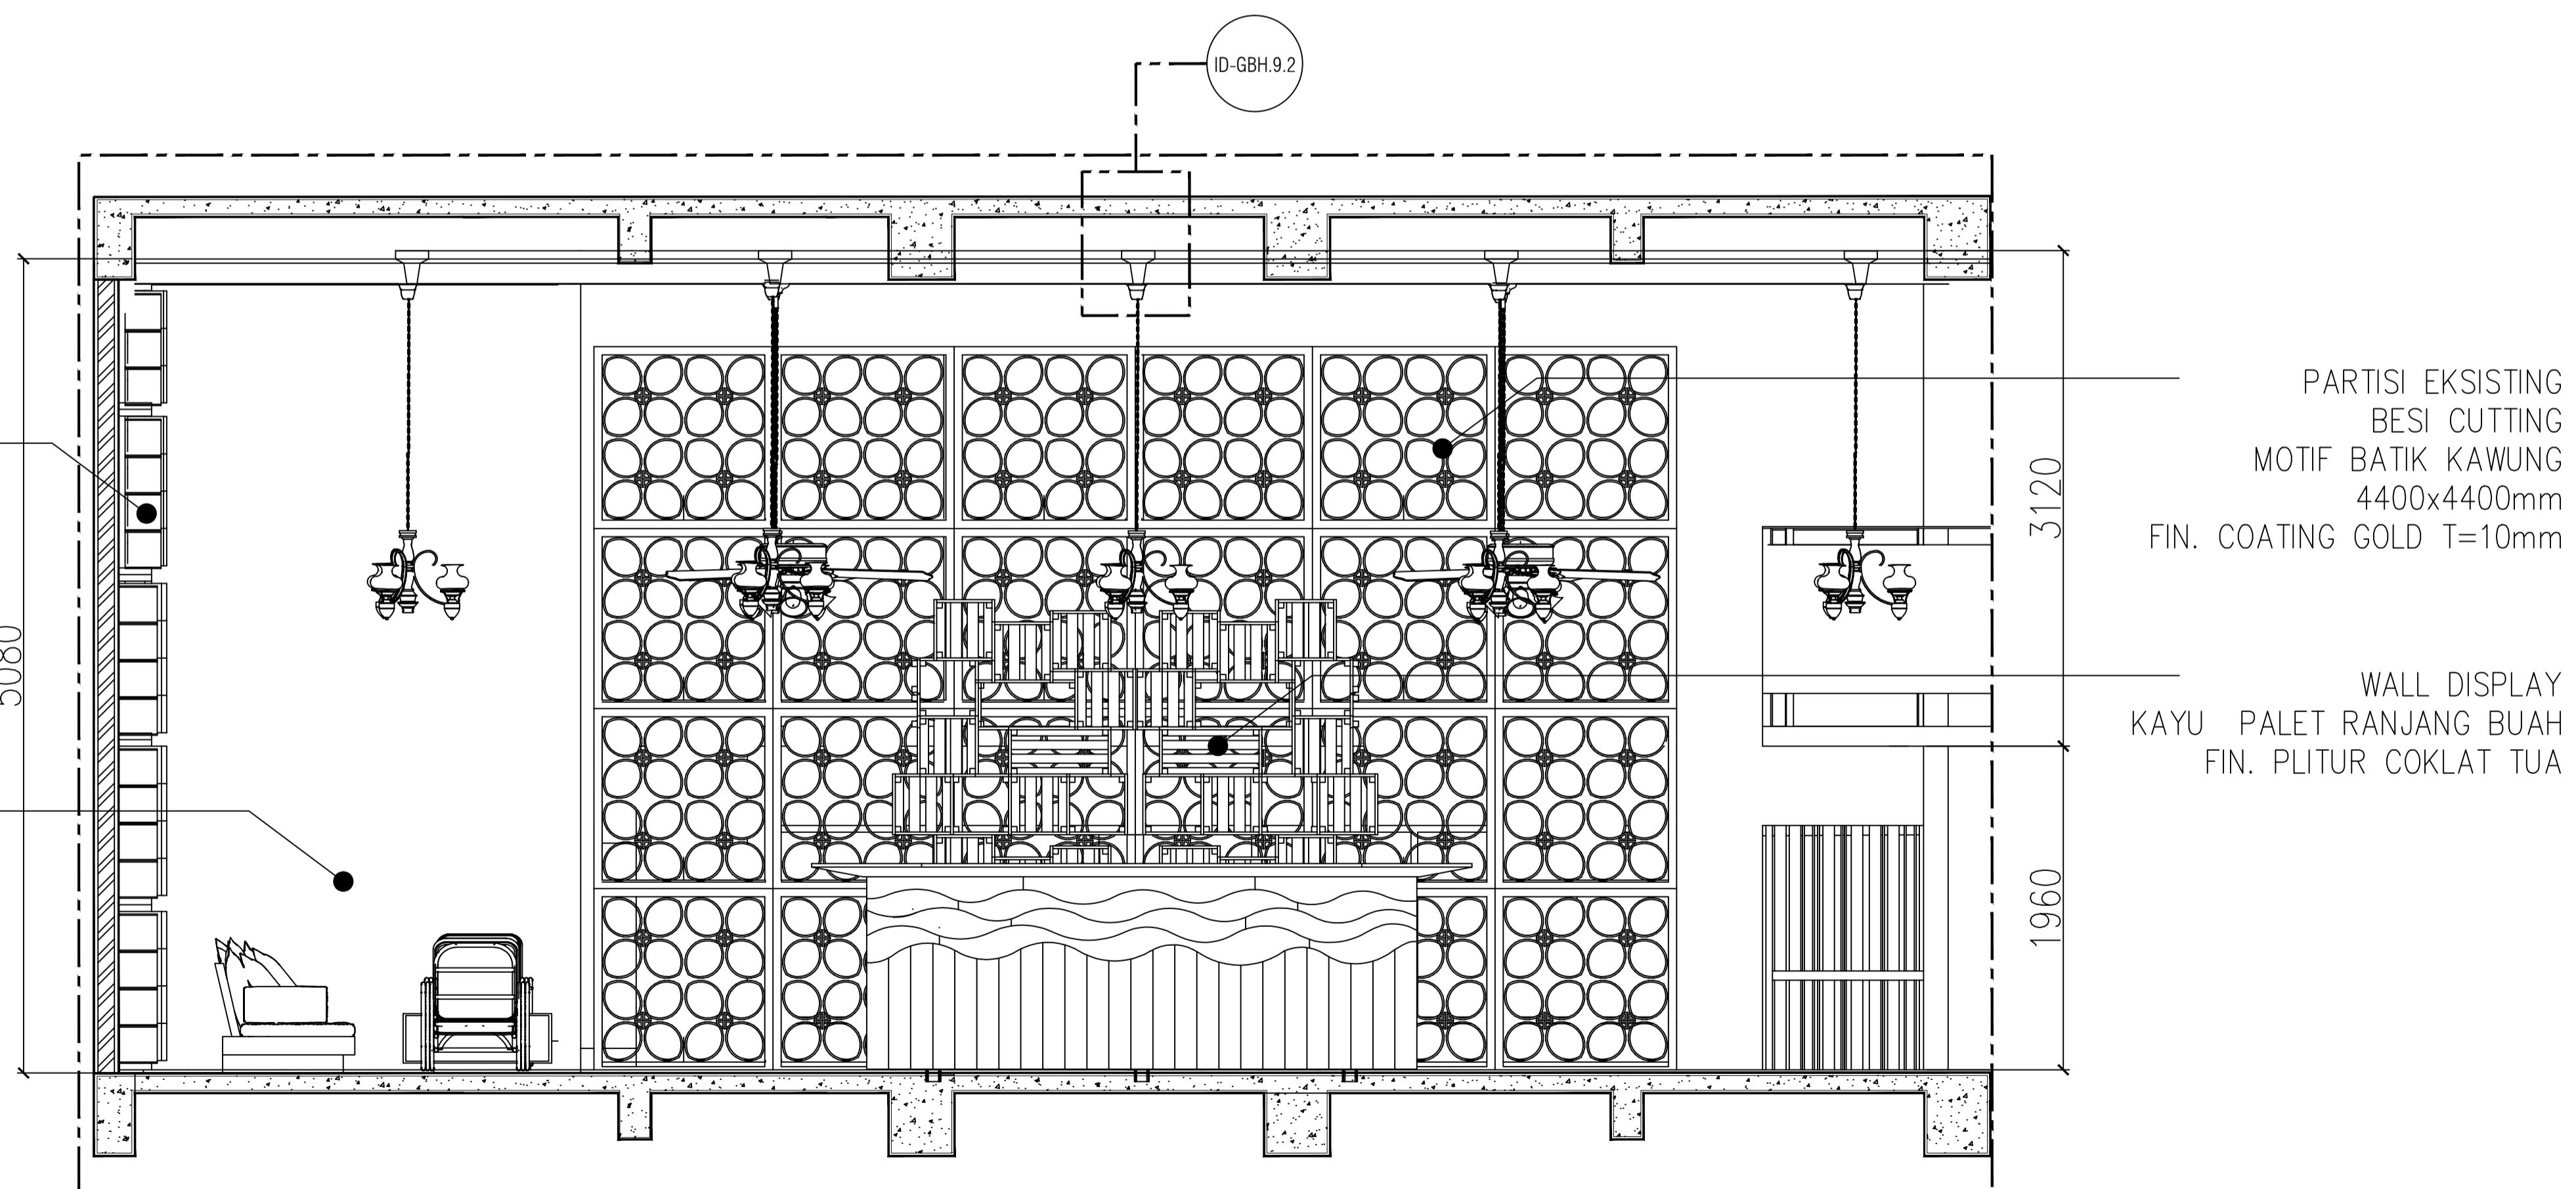


8
ID-GBH.8.3
GROUND FLOOR
POTONGAN D-D
SCALE 1:30

WALL TREATMENT
RANGKA HOLLOW
1250mm X 1250mm
FIN. COATING BLACK
AKSEN POTONGAN
BATANG KAYU

DINDING EKSTING
PLESTER FIN. EPOXY CLEAR

PARTISI EKSTING
BESI CUTTING
MOTIF BATIK KAWUNG
960x960mm
FIN. COATING GOLD T=10mm

WALL DISPLAY
KAYU PALET RANJANG BUAH
FIN. PLITUR COKLAT TUA

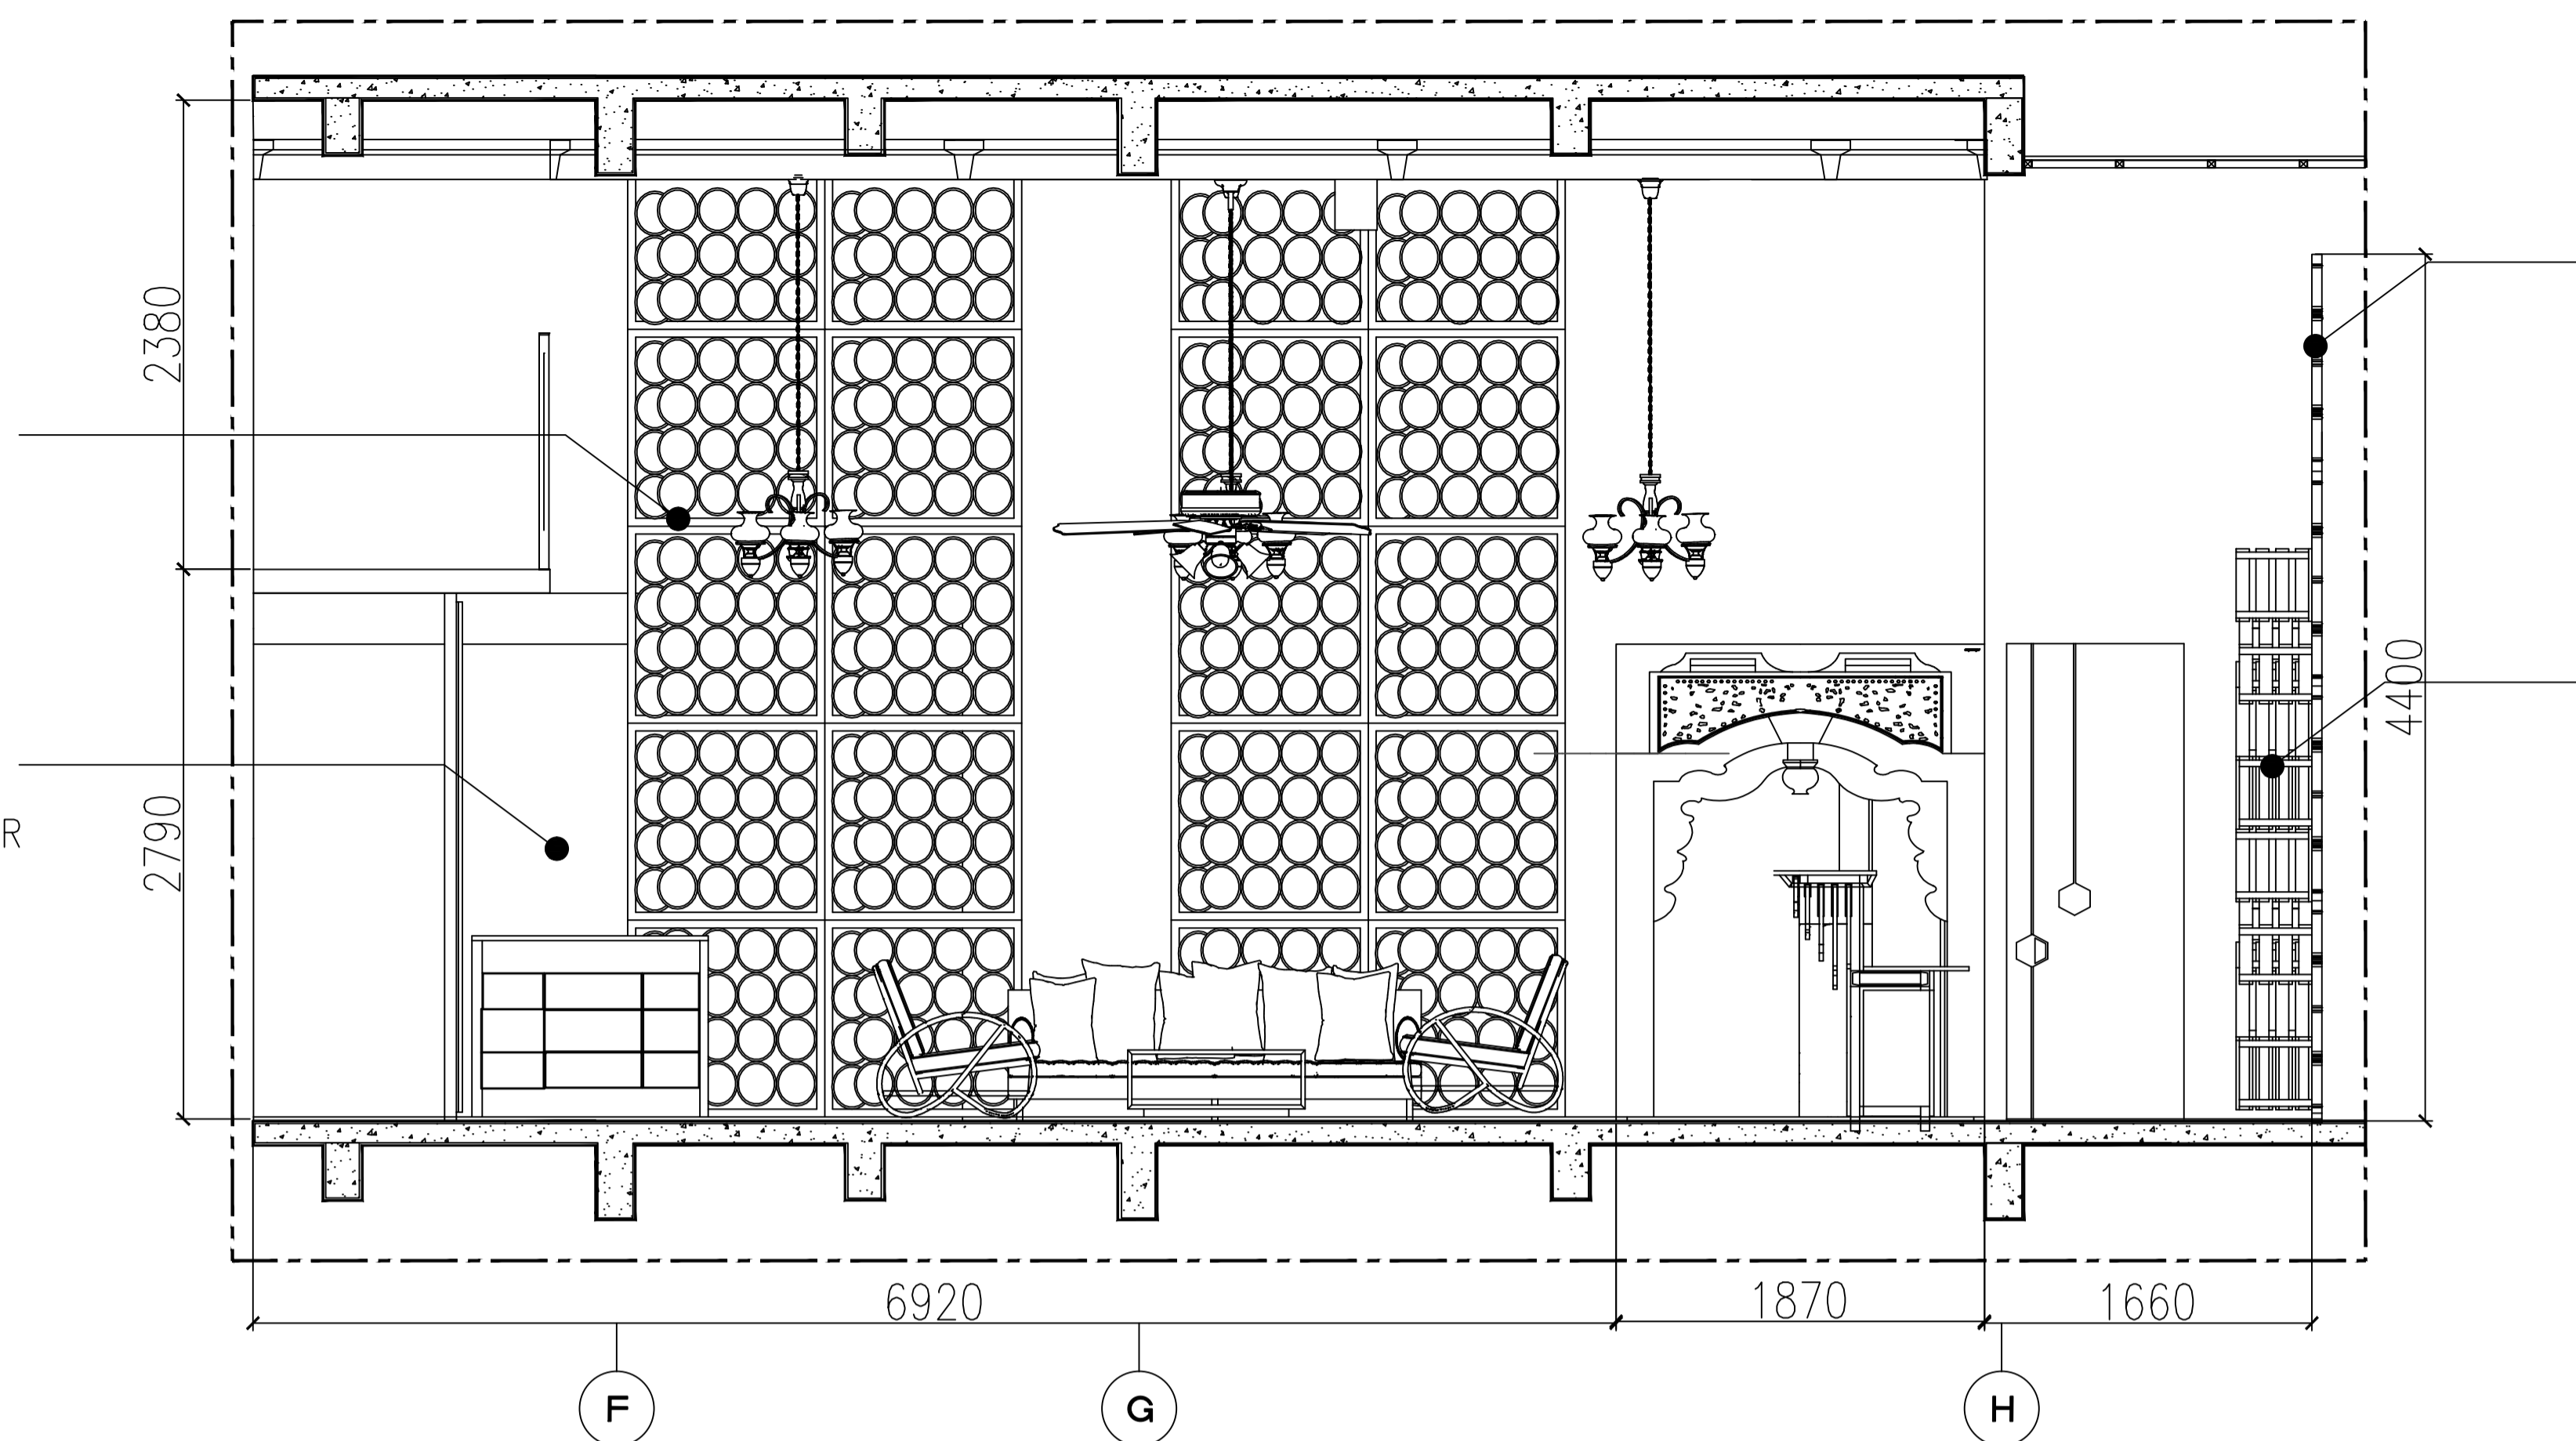



8
ID-GBH.8.4
GROUND FLOOR
POTONGAN E-E
SCALE 1:30

JENDELA KACA FRAMLES
2000mm X 660mm
FIN. COATING DUCO BLACK

DINDING EKSTING
PLESTER FIN. EPOXY CLEAR

WALL TREATMENT
PINTU GEYOK JEPARA
2100mmX1900mm
FIN. PLITUR COKLAT TUA


DINDING EKSTING
PLESTER FIN. EPOXY CLEAR

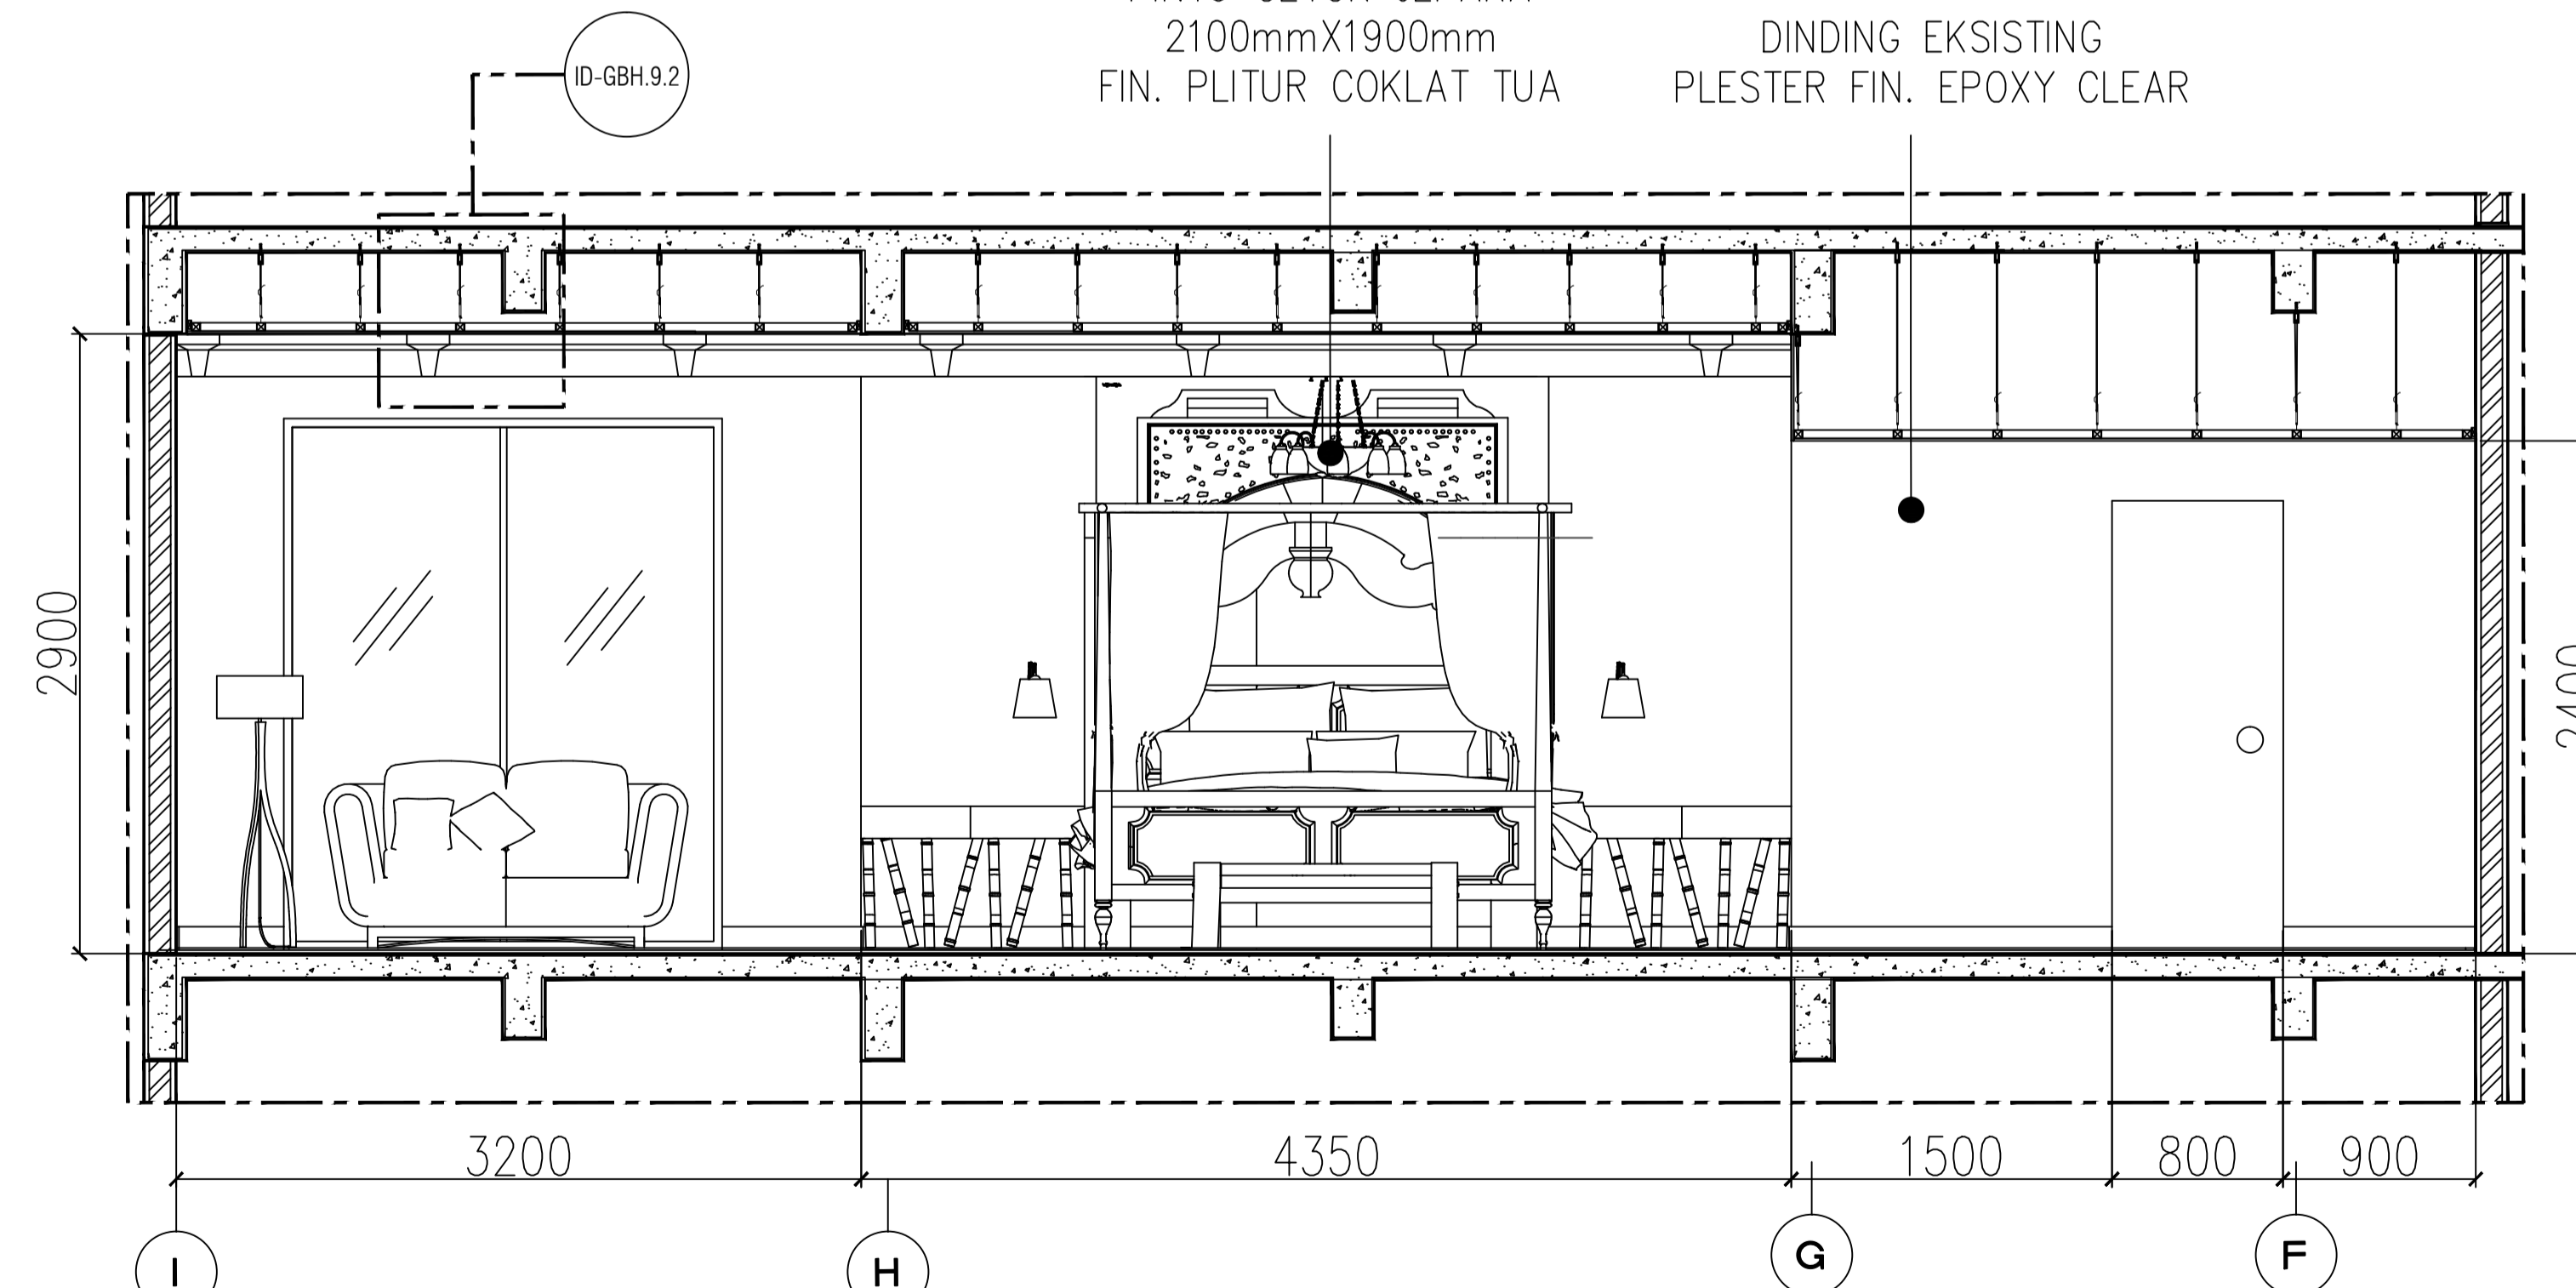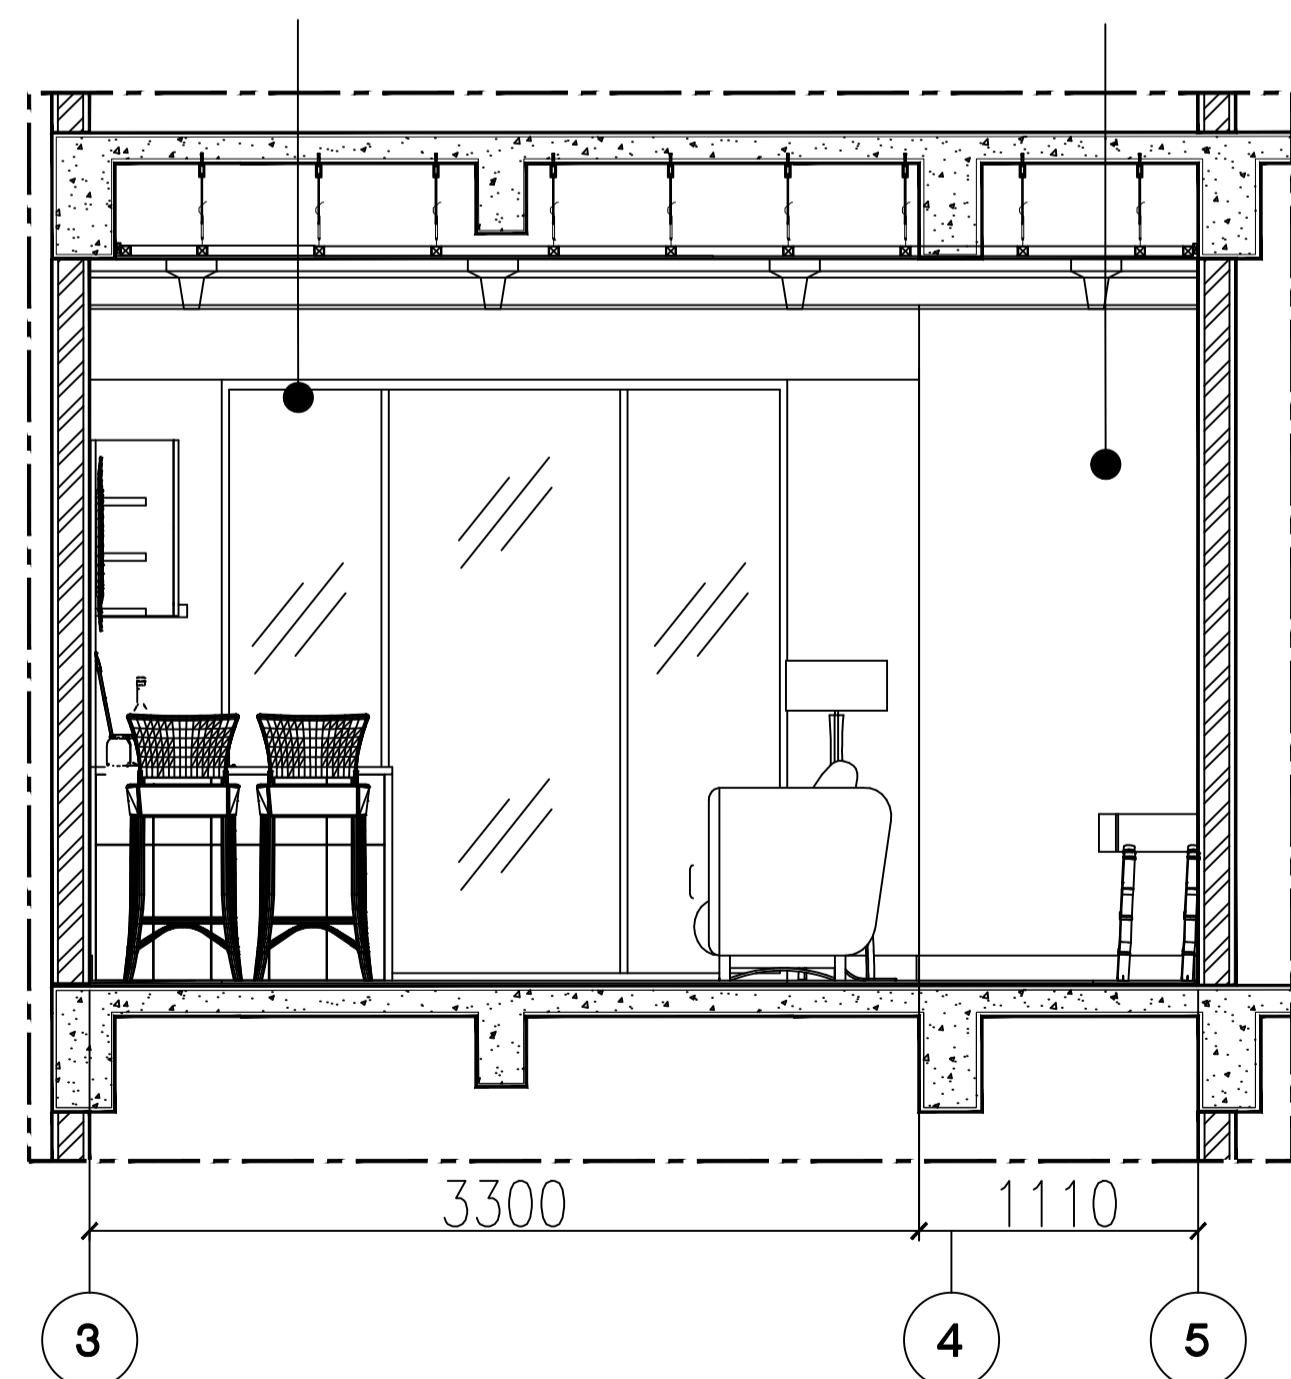

8
ID-GBH.8.6
GROUND FLOOR
POTONGAN G-G
SCALE 1:30

8
ID-GBH.8.5
GROUND FLOOR
POTONGAN F-F
SCALE 1:30

LEGEND

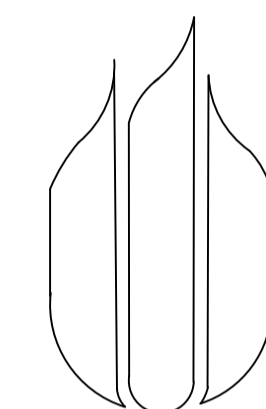

UNIVERSITAS
MERCU BUANA

NAMA PROYEK :

PERANCANGAN INTERIOR
GREENHOST BOUTIQUE HOTEL

JUDUL GAMBAR :

POTONGAN E-E, F-F, G-G
LT GROUND & LT. TIGA
(RECEPTIONIST & ERICK ROOM AREA)

NAMA :

FARID FADILAH

NIM :

41714010020

DOSEN PEMBIMBING :

YOHANES NUGROHO UTOMO, Drs, M.Ds

SKALA : 1 : 30


JUMLAH GAMBAR : NOMOR GAMBAR :

18/21

ID-GBH.8.4
ID-GBH.8.5
ID-GBH.8.6


NILAI :

PARAF :

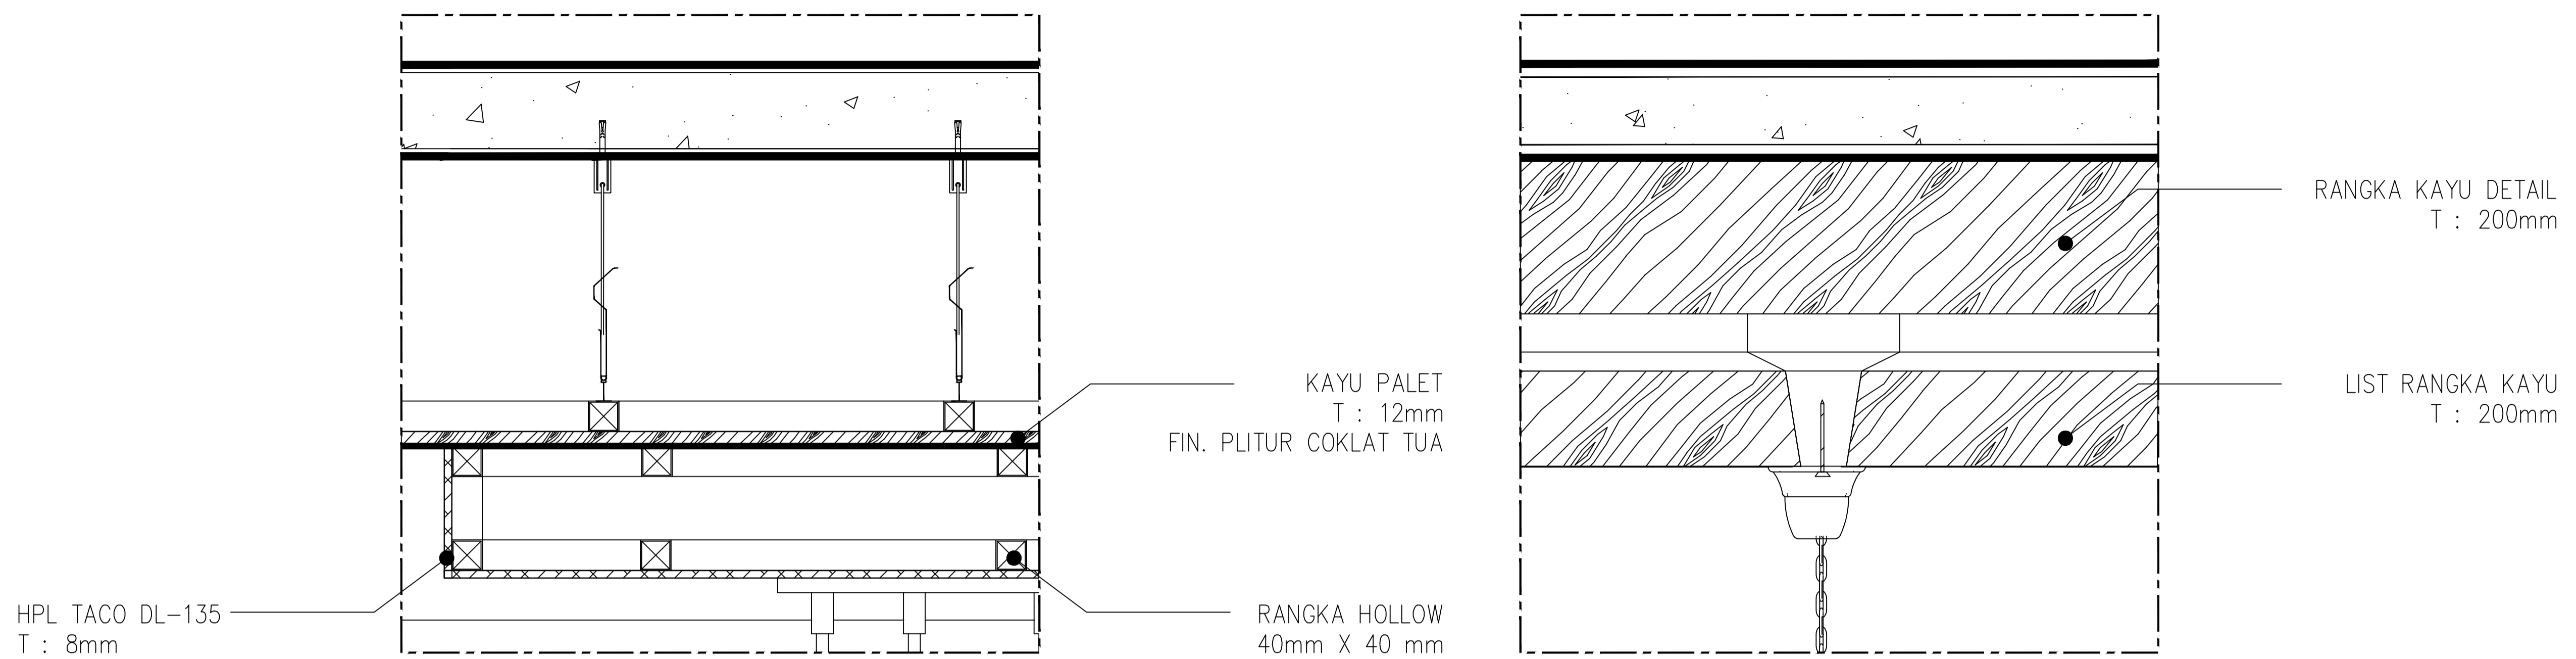


9
ID-GBH.9.0
SCALE 1:5
DETAIL PLAFON BUFFET

9
ID-GBH.9.1
SCALE 1:5
DETAIL PLAFON RESEPSIONIS

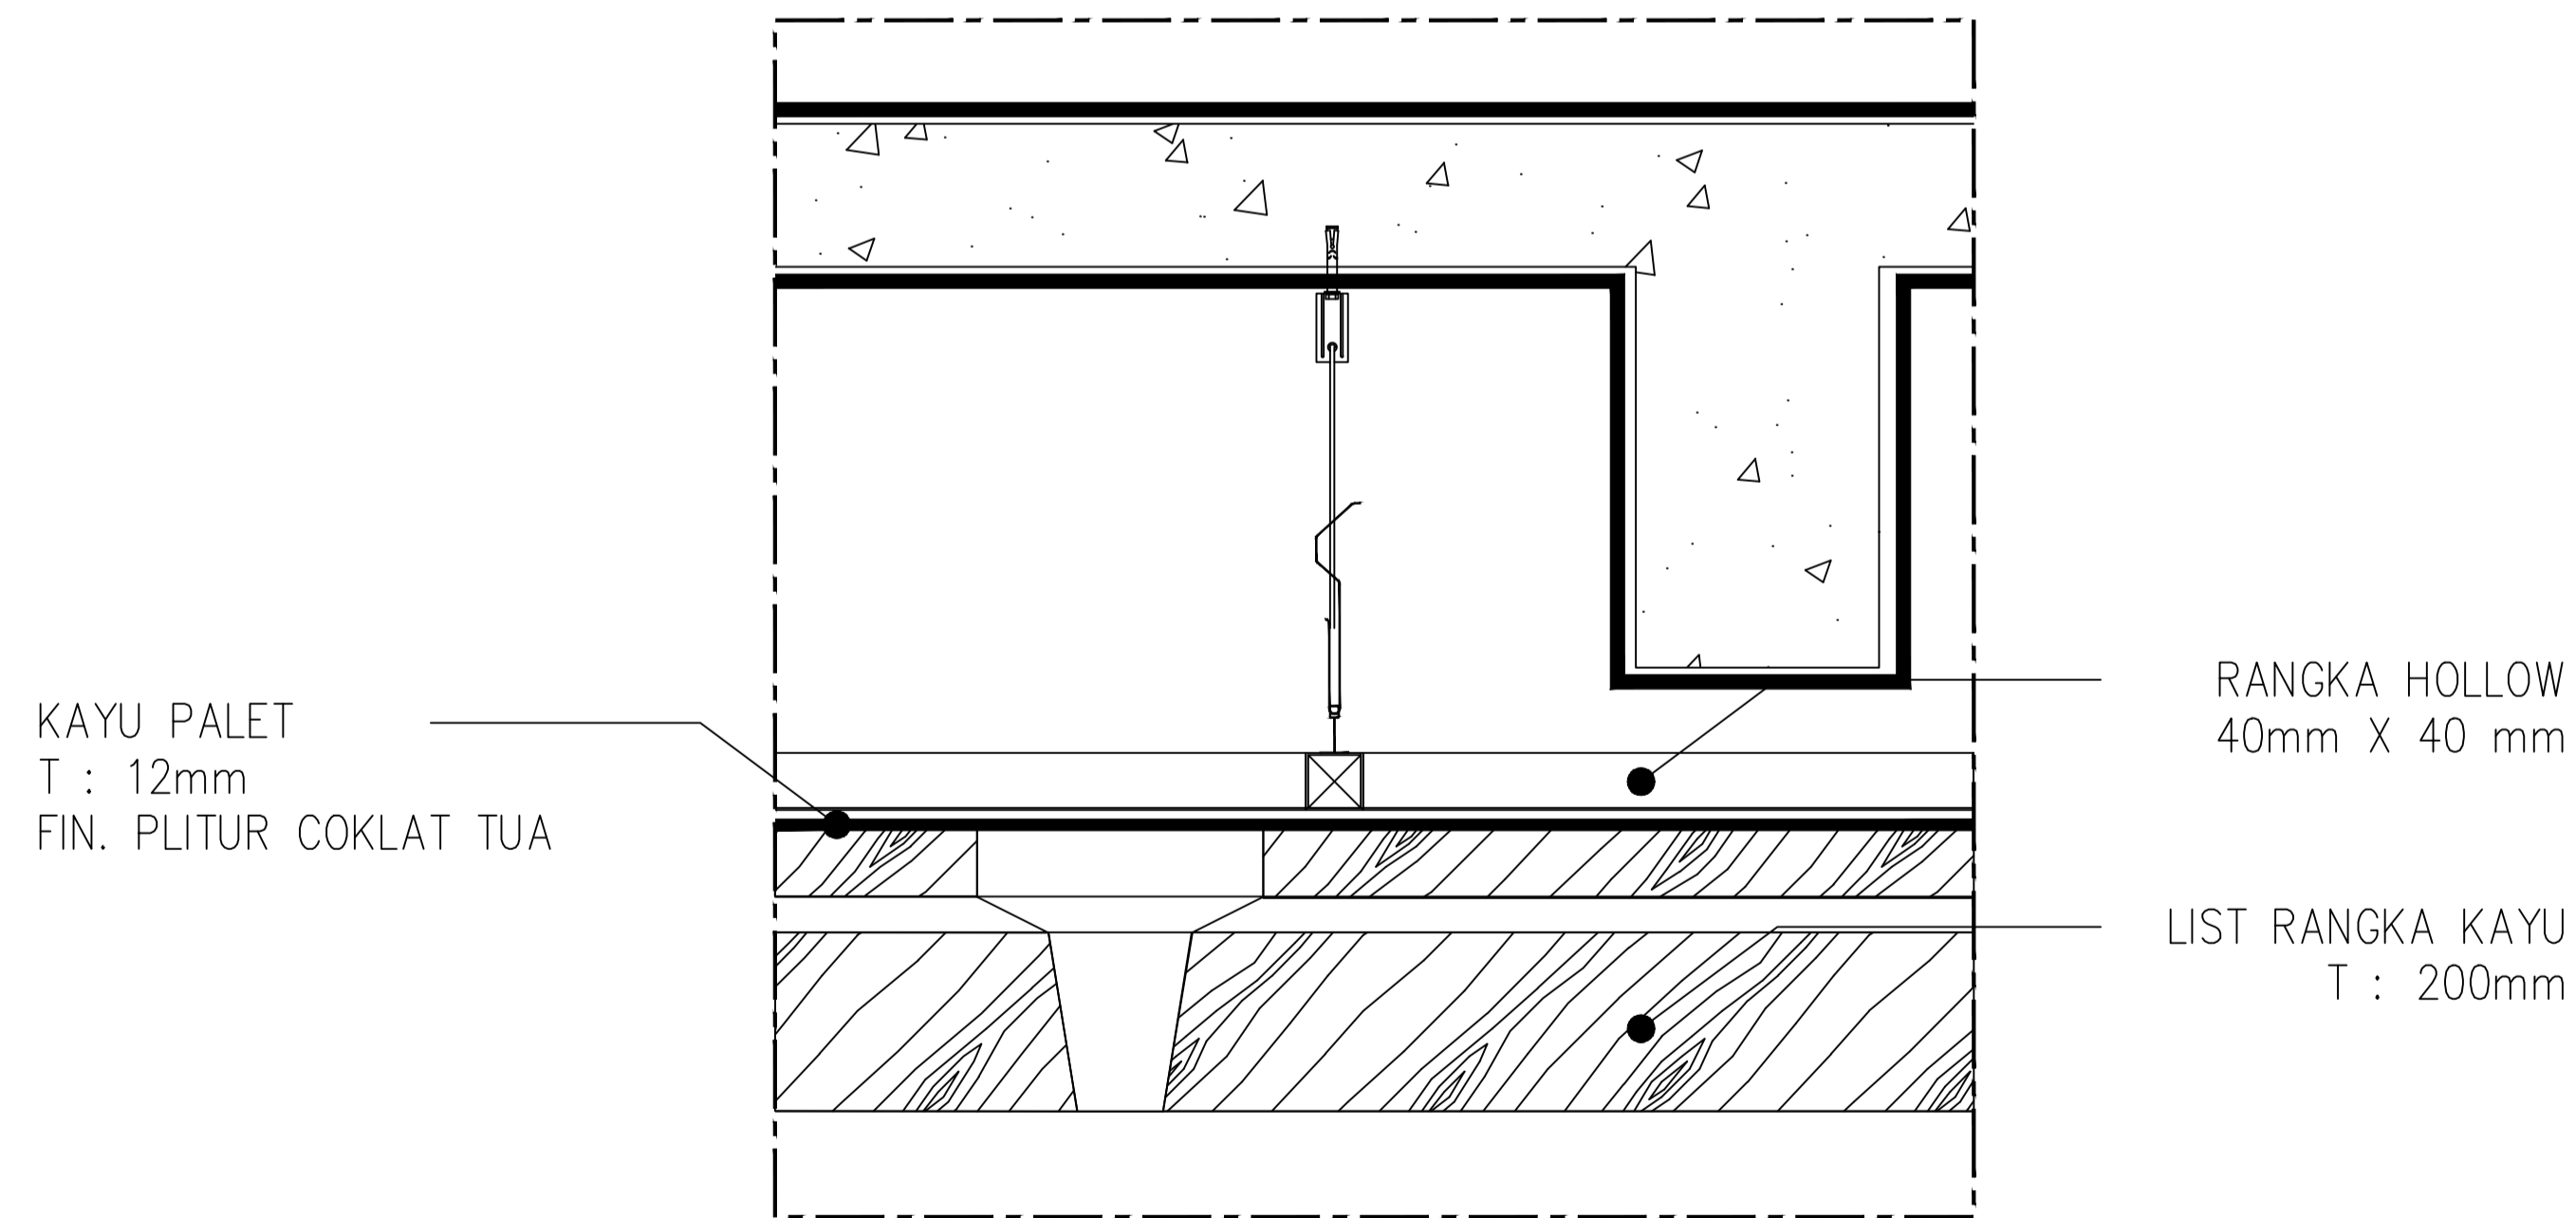

9
ID-GBH.9.2
SCALE 1:5
DETAIL PLAFON ERICK ROOM

LEGEND

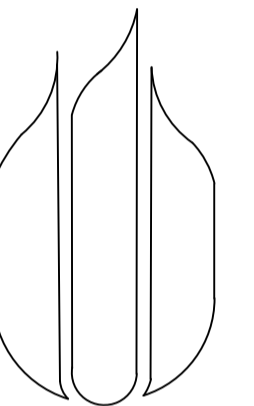

UNIVERSITAS
MERCU BUANA

NAMA PROYEK :
PERANCANGAN INTERIOR
GREENHOST BOUTIQUE HOTEL

JUDUL GAMBAR :
DETAIL POTONGAN
(RECEPTIONIST, ERICK ROOM
& ERICK ROOM AREA)


NAMA :
FARID FADILAH

NIM :
41714010020

DOSEN PEMBIMBING :
YOHANES NUGROHO UTOMO, Drs, M.Ds

SKALA : 1 : 5


JUMLAH GAMBAR :	NOMOR GAMBAR :
19/21	ID-GBH.9.0 ID-GBH.9.1 ID-GBH.9.2
NILAI :	PARAF :

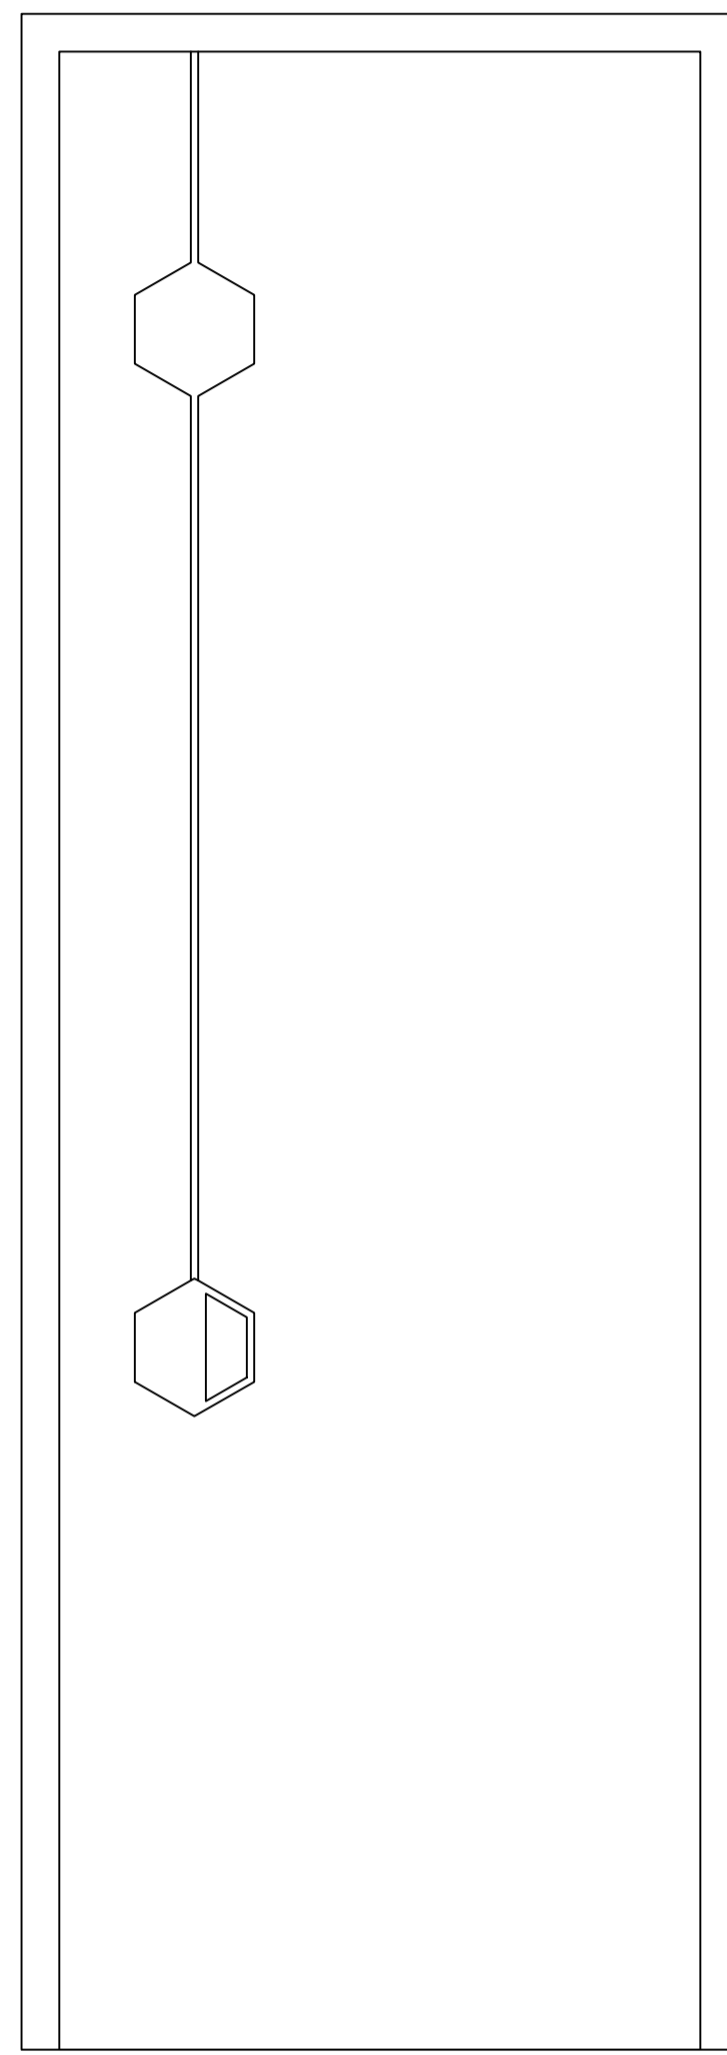

10 TAMPAK DEPAN
ID-GHB.10.0 SCALE 1:20



10 DETAIL PLAFON RESEPSIONIS
ID-GHB.10.1 SCALE 1:20

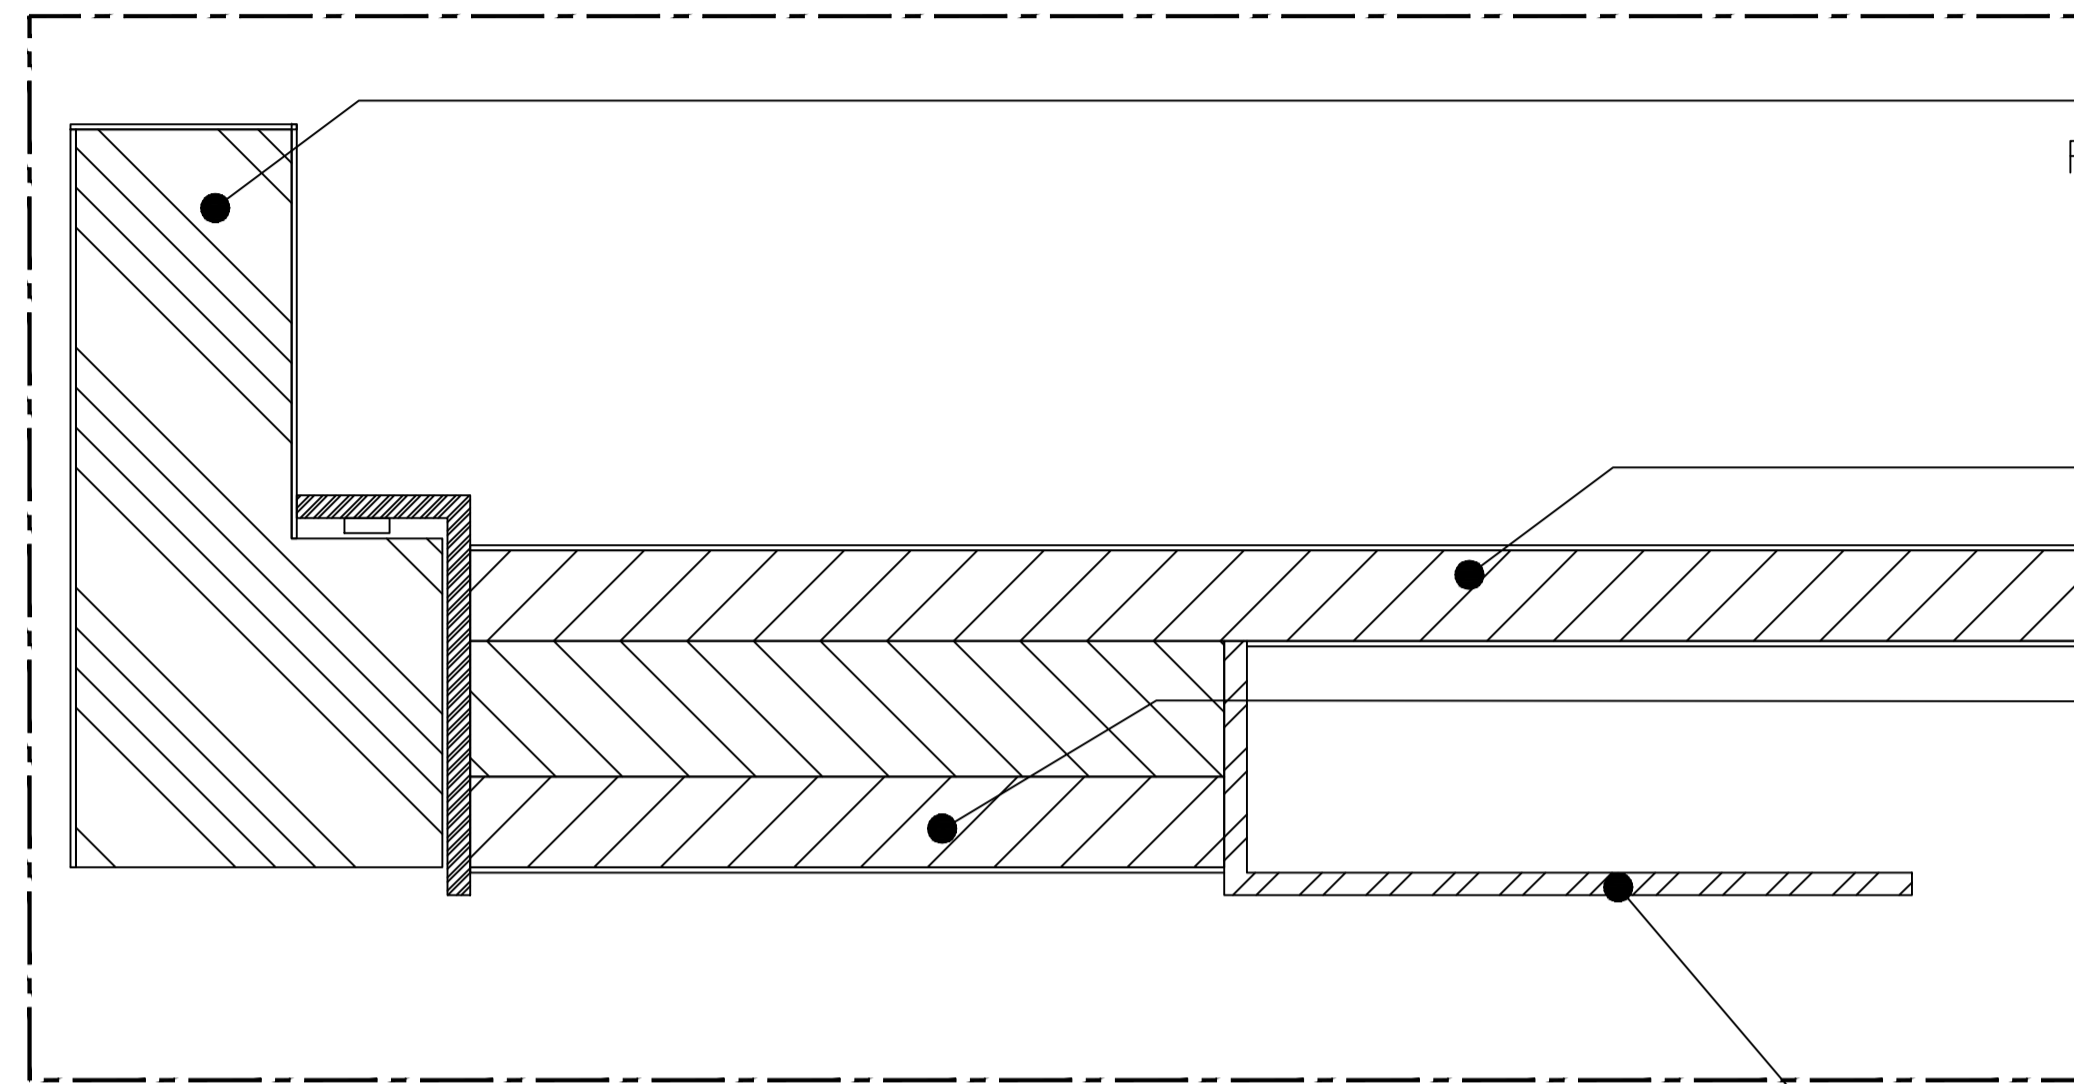


KAYU SOLID KAMPER
FIN. VENNER OAK FIN MELAMIK NATURAL
TOP COATING SEMI DOFF
EX. MILES!

PALET 12mm
FIN. MELAMIK NATURAL
TOP COATING SEMIDOFF

PLYWOOD 12mm

RANGKA PALET 12mm
FIN. MELAMIK NATURAL
TOP COATING SEMIDOFF

10 DETAIL PINTU
ID-GHB.10.3 SCALE 1:1

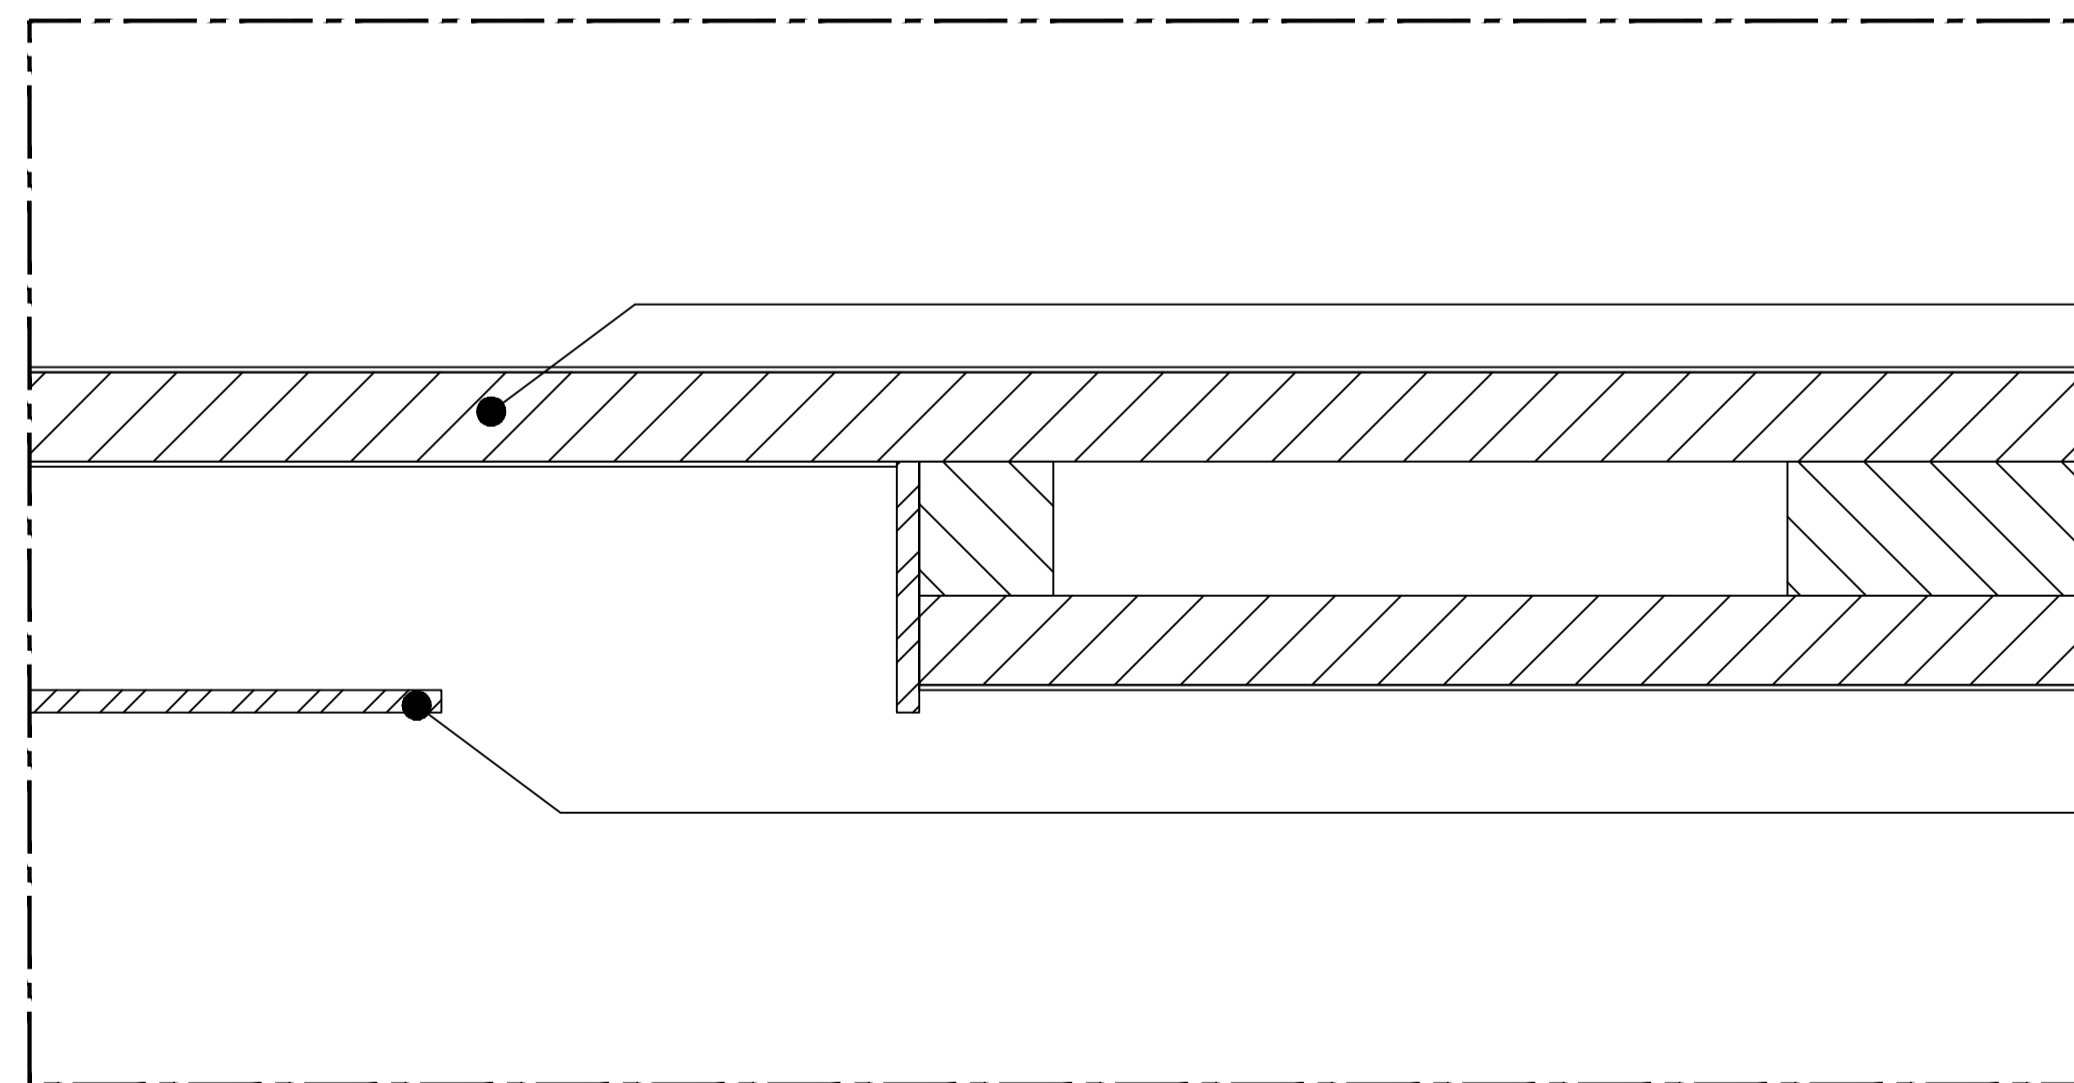


PALET 12mm
FIN. MELAMIK NATURAL
TOP COATING SEMIDOFF

RANGKA PALET 12mm
FIN. MELAMIK NATURAL
TOP COATING SEMIDOFF

10 DETAIL PINTU
ID-GHB.10.4 SCALE 1:1

LEGEND

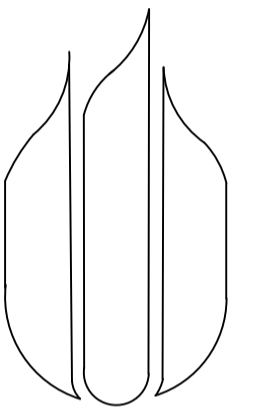

UNIVERSITAS
MERCU BUANA

NAMA PROYEK :

PERANCANGAN INTERIOR
GREENHOST BOUTIQUE HOTEL

JUDUL GAMBAR :

RENCANA PINTU & DETAIL
ERICK ROOM

NAMA :

FARID FADILAH

NIM :

41714010020

DOSEN PEMBIMBING :

YOHANES NUGROHO UTOMO, Drs, M.Ds

SKALA : 1 : 20 , 1 : 1


JUMLAH GAMBAR : NOMOR GAMBAR :

20/21


ID-GBH.10.0
ID-GBH.10.1
ID-GBH.10.2
ID-GBH.10.3

NILAI :


PARAF :

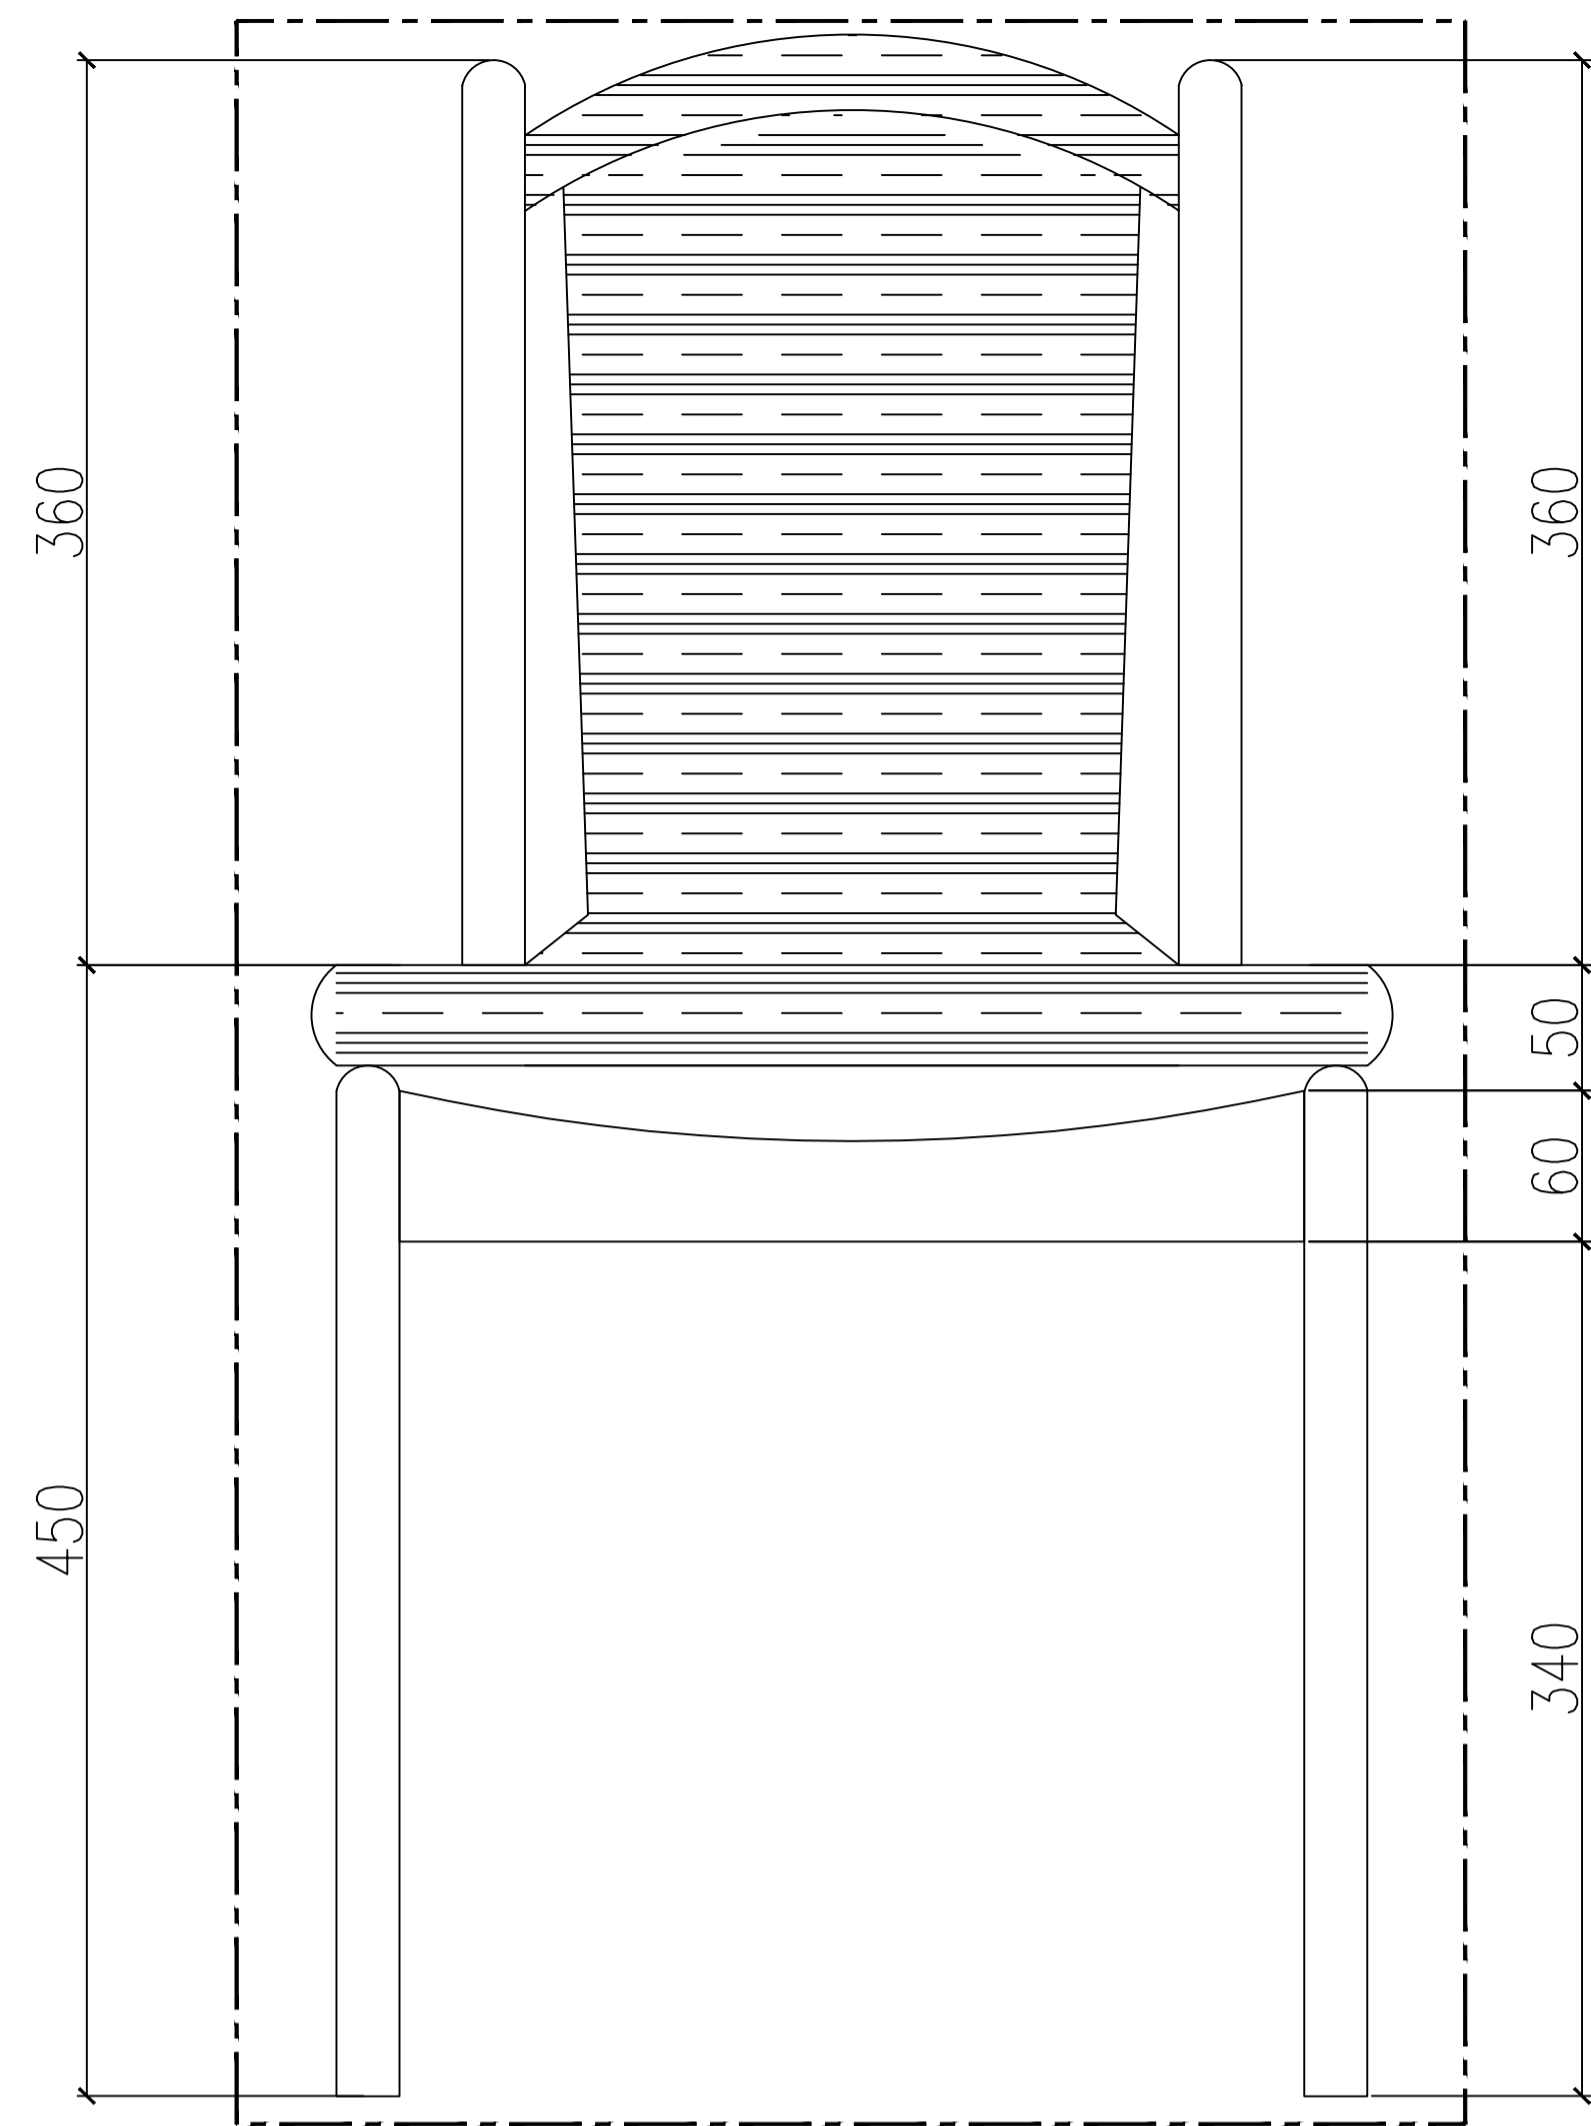

11
ID-GHB.11.0
TAMPAK DEPAN KURSI
SCALE 1:3

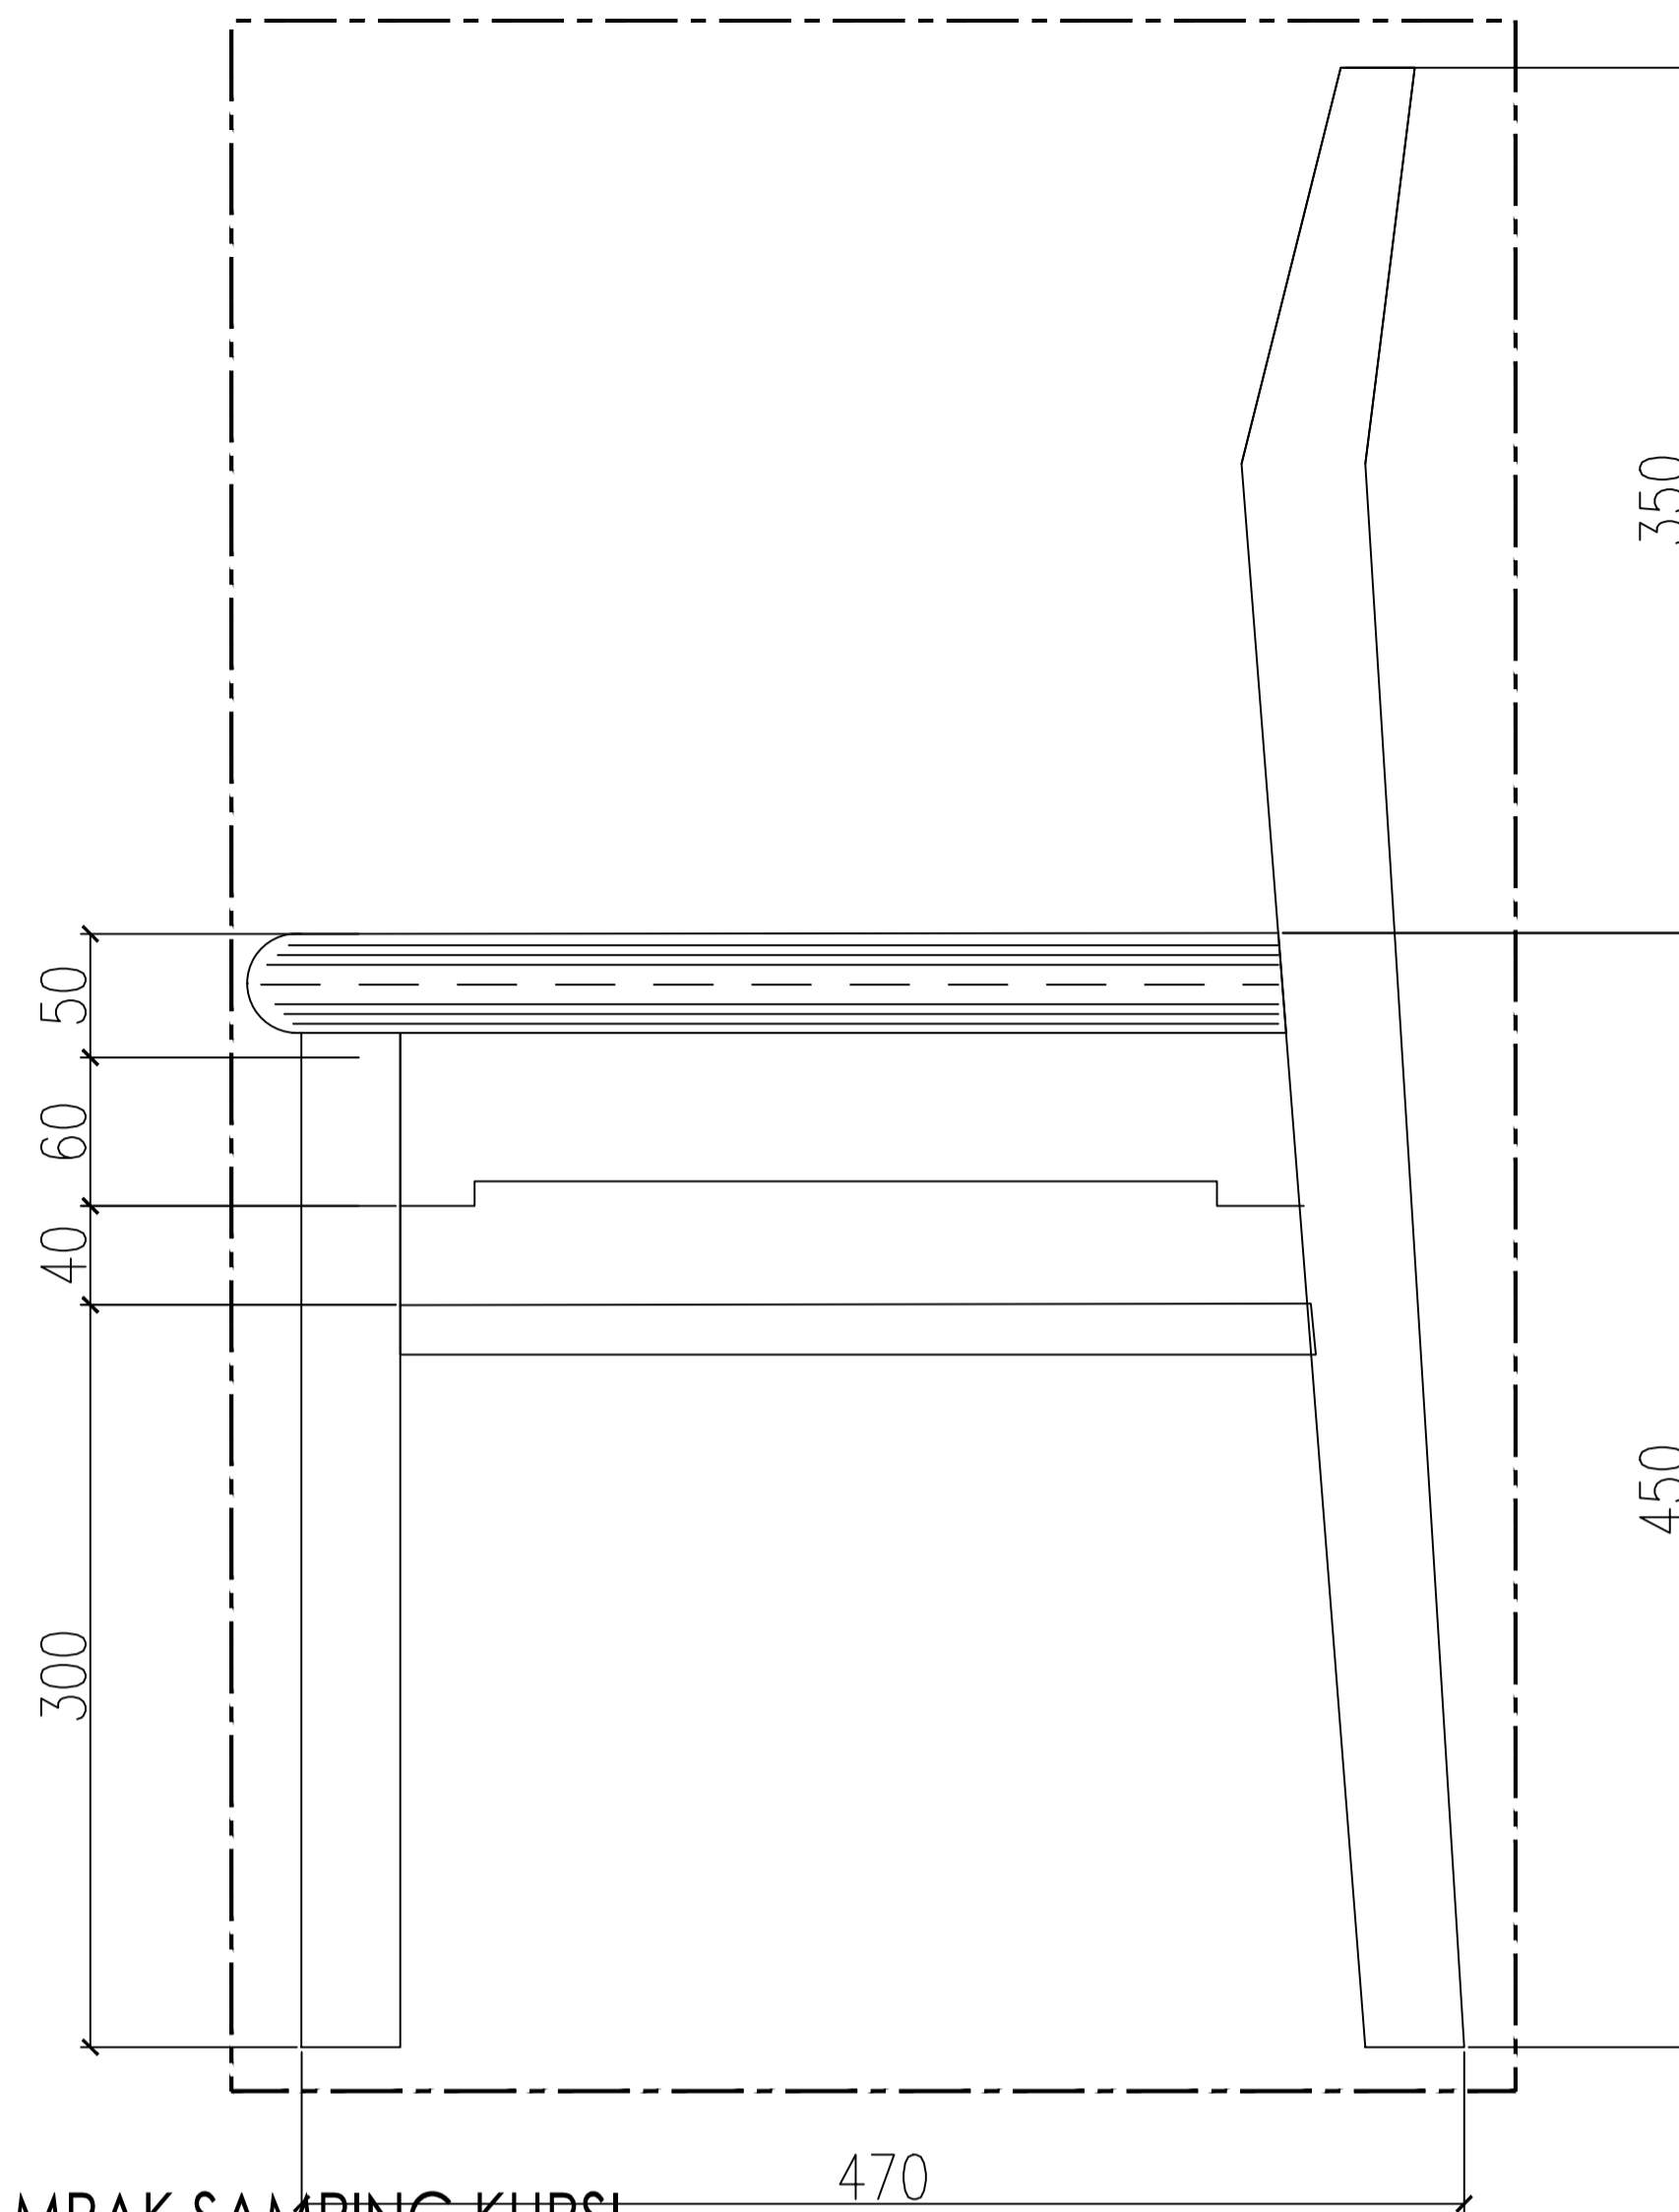


11
ID-GHB.11.1
TAMPAK SAMPING KURSI
SCALE 1:3

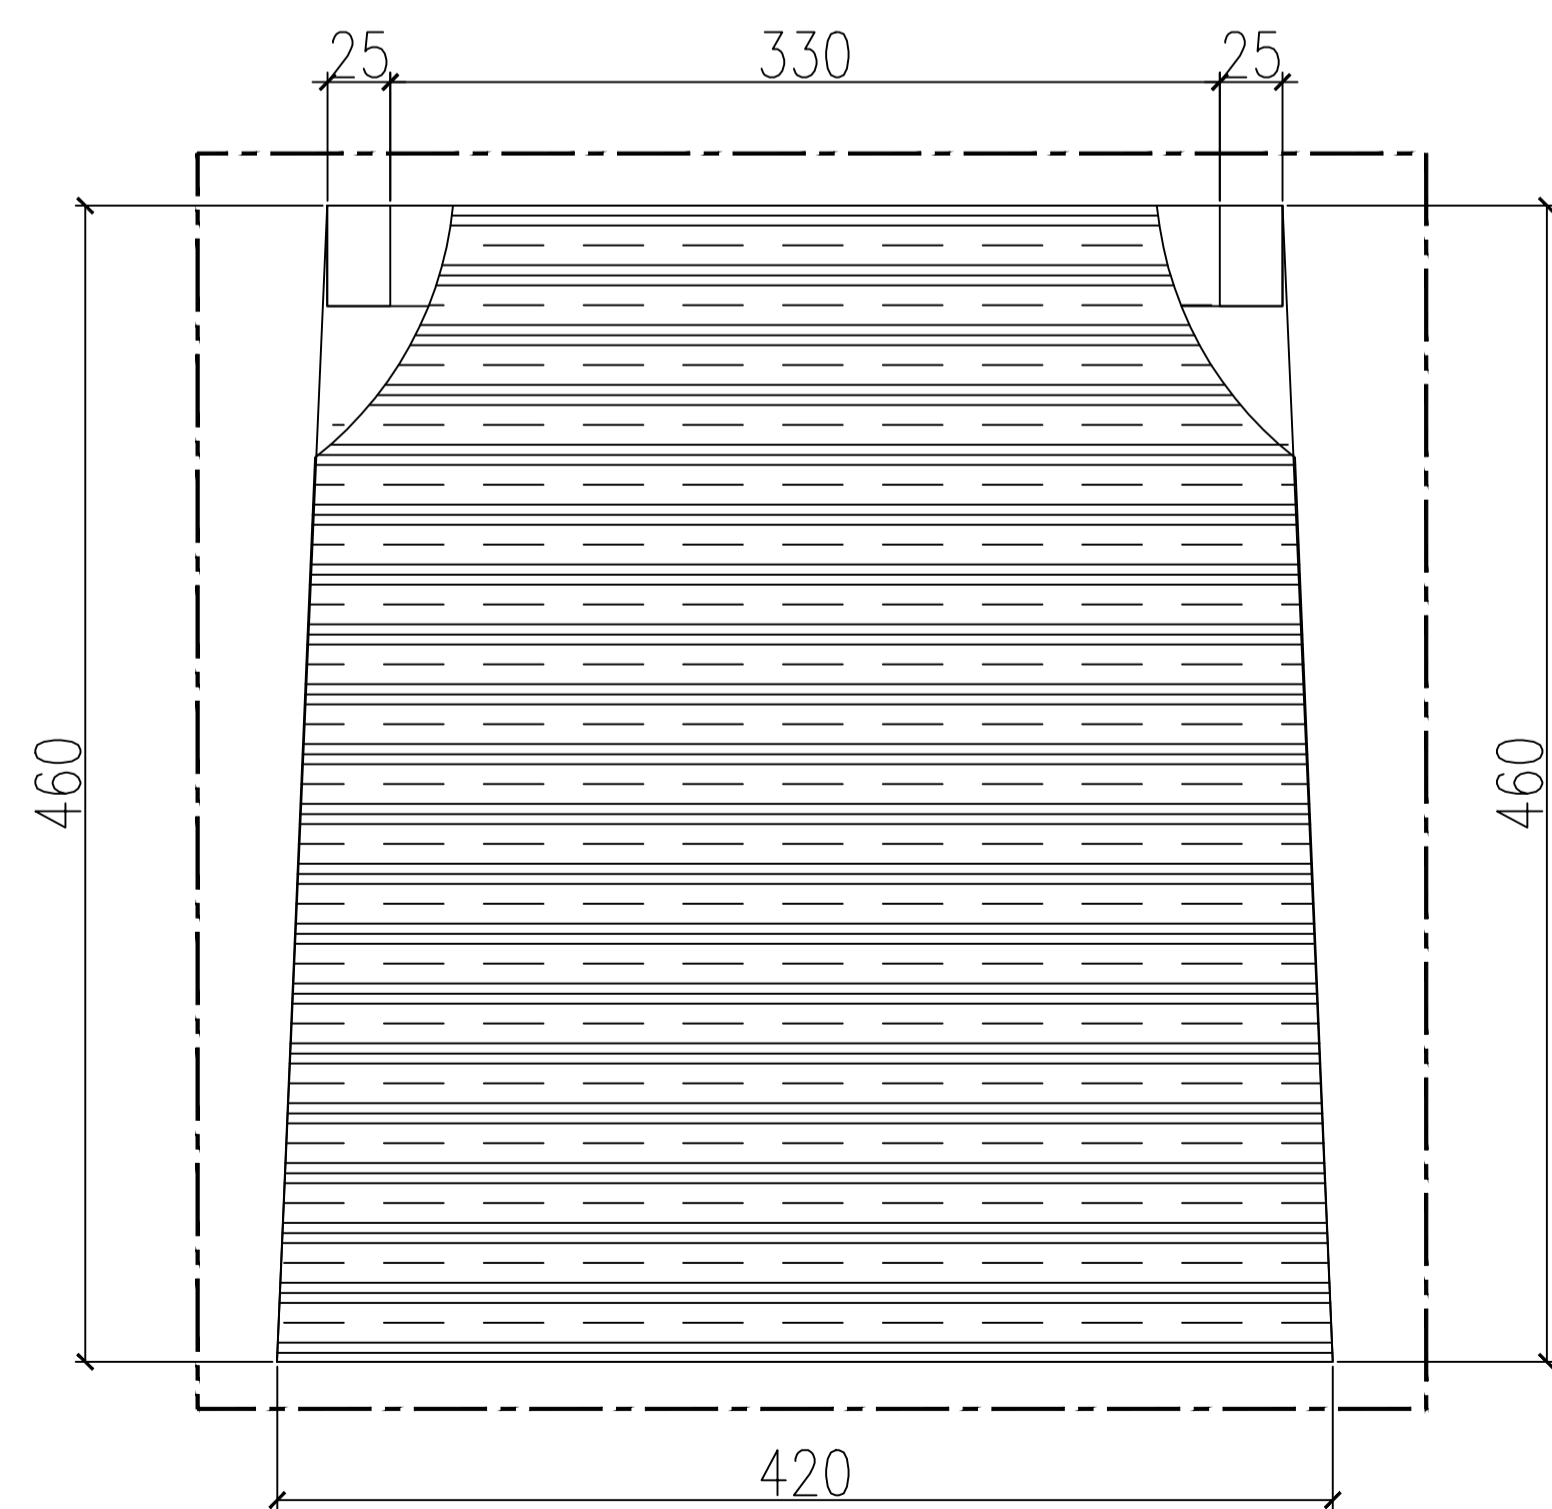

11
ID-GHB.11.2
TAMPAK ATAS KURSI
SCALE 1:3

11
ID-GHB.11.3
PRESSPEKTIF KURSI
SCALE 1:3

LEGEND

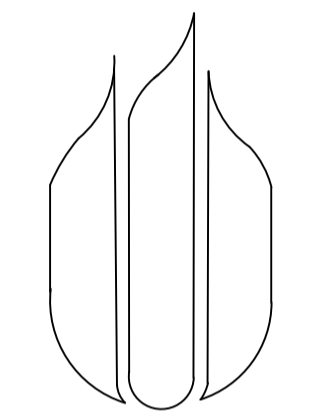

UNIVERSITAS
MERCU BUANA

NAMA PROYEK :

PERANCANGAN INTERIOR
GREENHOST BOUTIQUE HOTEL

JUDUL GAMBAR :

RENCANA FURNITURE
GREEN CHAIR RATTAN WITH TOUCH JAVA

NAMA :

FARID FADILAH

NIM :

41714010020

DOSEN PEMBIMBING :

YOHANES NUGROHO UTOMO, Drs, M.Ds

SKALA : 1 : 3

JUMLAH GAMBAR : NOMOR GAMBAR :

21/21

ID-GBH.11.0
ID-GBH.11.1
ID-GBH.11.2
ID-GBH.11.3

NILAI :

PARAF :



**SURAT KETERANGAN HASIL SIDANG TUGAS AKHIR
PROGRAM STUDI DESAIN INTERIOR
FAKULTAS DESAIN DAN SENI KREATIF
UNIVERSITAS MERCU BUANA**

Q

No. Dokumen	010 423 4 47 00	Distribusi					
Tgl. Efektif	7 MARET 2005						

Berdasarkan hasil Sidang Seminar Konsep Perancangan pada tanggal 24 April 2018 **Semester Genap Tahun Akademik 2017/2018**, maka mahasiswa berikut ini :

Nama / NIM : Farid Fadilah / 41714010020
Judul Tugas Akhir : Perancangan Desain Interior Hotel Greenhost Boutique Yogyakarta
Pembimbing : Nugroho Utomo, Drs, M.Ds

dinyatakan :

- Lulus Langsung, dengan nilai
 Lulus Melengkapi, dengan nilai ... *82,07 (A)* .
 Perbaikan
 Tidak Lulus

Ketua dan Anggota Dewan Penguji :

1.

2.

3.

LEMBAR PENGESAHAN SEMINAR MELENGKAPI / PERBAIKAN

Pembimbing/Ketua Sidang/Penguji I

Penguji II

Mr. Chandraratny P.

Koordinator Tugas Akhir

Mr. Chandraratny P.

Penguji III

Catatan :

- Lembar Pengesahan seminar konsep perancangan Melengkapi/Perbaikan ini ditanda tangani apabila mahasiswa telah melengkapi/memperbaiki seminar sesuai catatan Dewan Penguji pada saat Sidang seminar konsep perancangan.
- Lembar Pengesahan ini harus telah ditandatangani oleh Pembimbing, Penguji dan Ketua Sidang pada seminar konsep perancangan yang telah dilengkapi/diperbaiki dikumpulkan.
- Jadwal pengumpulan seminar konsep perancangan **Melengkapi : 1 minggu dari jadwal Sidang** mak jam 16.⁰⁰ WIB. Jadwal pengumpulan seminar konsep perancangan **Perbaikan : 2 minggu dari jadwal Sidang** mak jam 16.⁰⁰ WIB.
- Apabila mahasiswa tidak memasukkan seminar konsep perancangan Melengkapi/Perbaikan sesuai jadwal yang telah ditetapkan, maka status kelulusannya diturunkan satu tingkat ke bawah.



**HASIL SIDANG STUDIO TUGAS AKHIR
PROGRAM STUDI S.1 DESAIN INTERIOR
FAKULTAS DESAIN DAN SENI KREATIF
UNIVERSITAS MERCU BUANA**

Q

No.Dokumen	010 423 4 48 00	Distribusi					
Tgl. Efektif	7 MARET 2005						




Berdasarkan hasil Sidang Studio II Tugas Akhir Semester Genap Tahun Akademik 2017/2018 pada tanggal **26 Juni 2018**, maka mahasiswa berikut ini :

Nama : Farid Fadilah
 NIM : 41714010020
 Judul TA : Perancangan Desain Interior Hotel Greenhost Boutique Yogyakarta
 Pembimbing : Nugroho Utomo, Drs, M.Ds

dinyatakan :

- Lulus Langsung, dengan nilai
- Lulus Melengkapi, dengan nilai **A- 81,13**
- Perbaikan
- Tidak Lulus


Ketua dan Anggota Dewan Penguji :

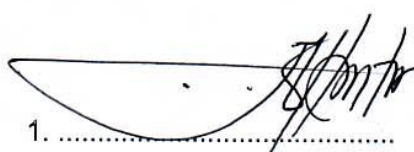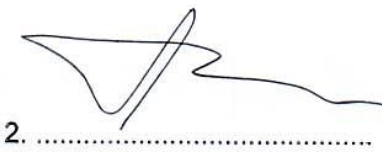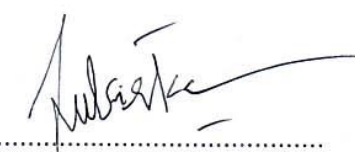1. 
 2. 
 3. 

LEMBAR PENGESAHAN MELENGKAPI/PERBAIKAN

(Lembar Pengesahan TUGAS AKHIR Melengkapi/Perbaikan ini ditanda tangani apabila mahasiswa telah melengkapi/memperbaiki seminar sesuai catatan Dewan Penguji pada saat Sidang Tugas Akhir)

Pembimbing/Ketua Sidang/Penguji I

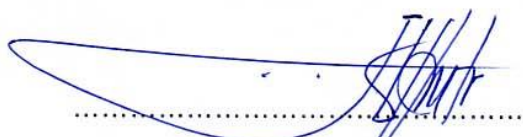


Koordinator Tugas Akhir




Rr. Chandrezky P. S.Sn., M.Ds

Penguji II

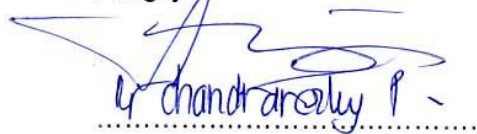
Rr. Chandrezky P.

Penguji III

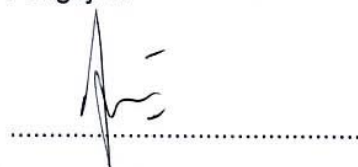

Catatan :

- Lembar Pengesahan ini harus ditanda tangani oleh Pembimbing, Penguji dan Ketua Sidang pada Laporan yang telah dilengkapi/diperbaiki dikumpulkan.
- Jadwal pengumpulan **SIDANG Melengkapi** tanggal (1 Minggu Setelah Tanggal Sidang) maksimum jam 16.00 WIB.
- Jadwal pengumpulan Tugas Akhir **Perbaikan** tanggal (2 Minggu Setelah Tanggal Sidang) maksimum jam 16.00 WIB.
- Apabila mahasiswa tidak memasukkan Melengkapi/Perbaikan sesuai jadwal yang telah ditetapkan, maka status kelulusannya diturunkan satu tingkat ke bawah.